


Order Plans @ [www.LDOnline.com](http://www.LDOnline.com)

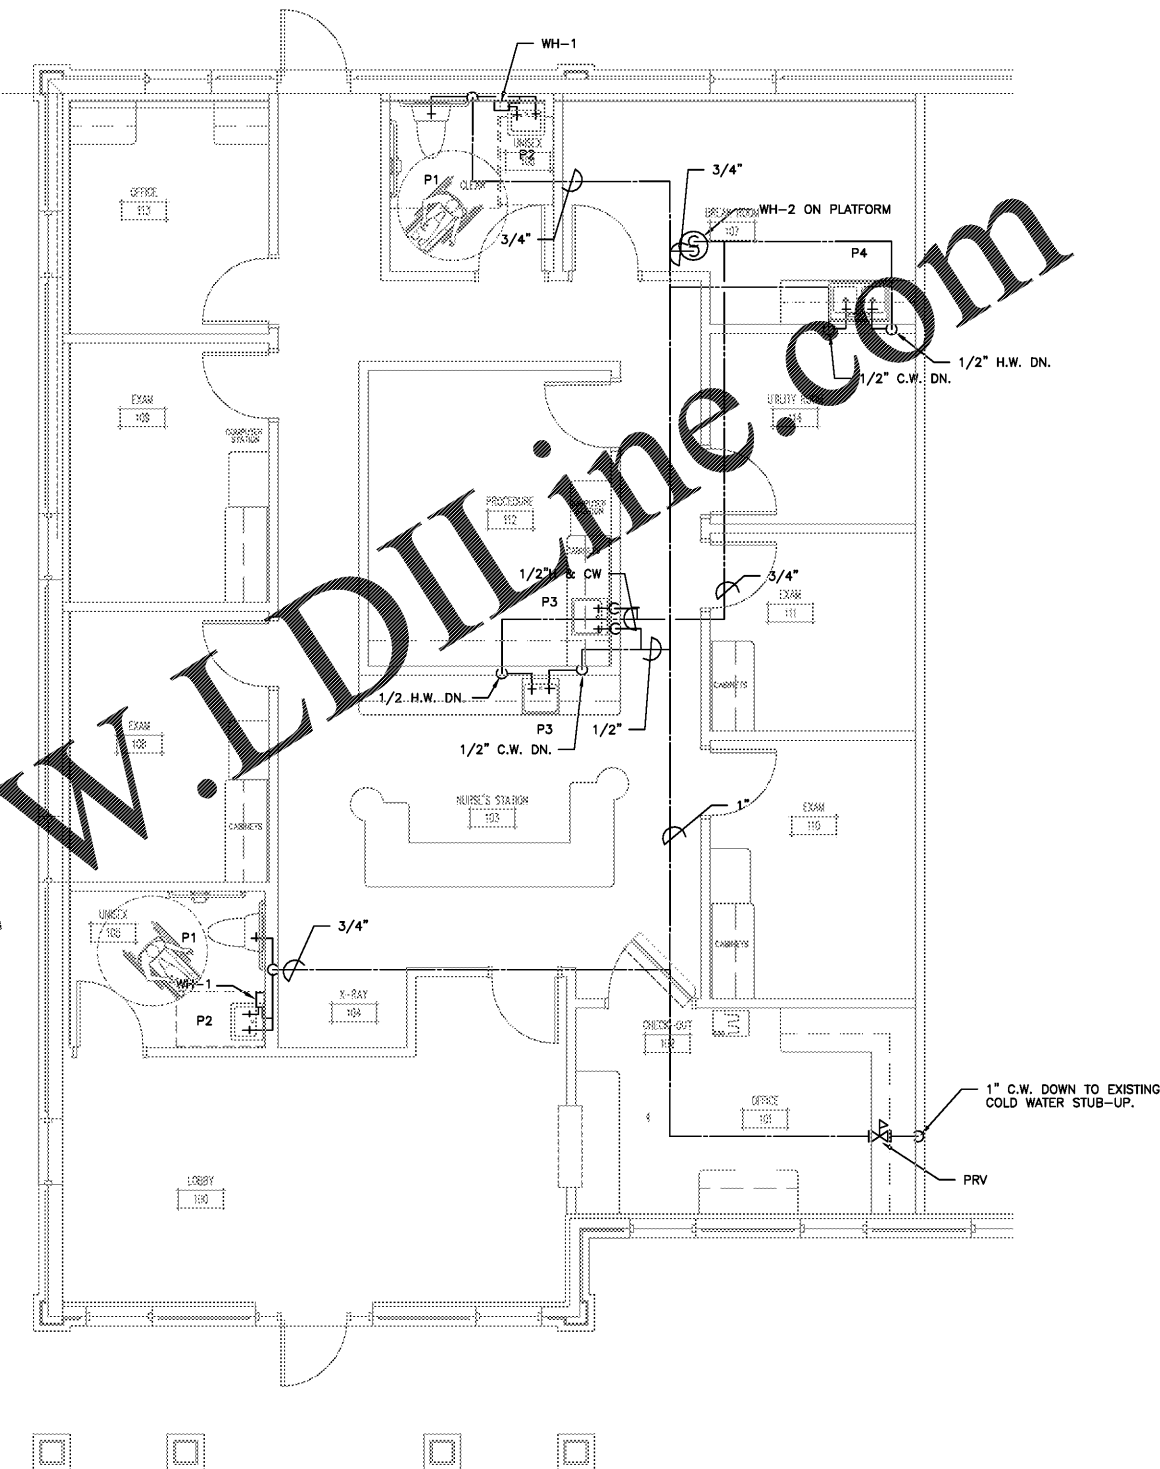

① FLOOR PLAN - HOT & COLD WATER  
Scale: 1/4"=1'-0"



ARCHITECTURE  
ENGINEERING

3680 Pleasant Hill Road  
Suite 200  
Duluth, Georgia 30096  
p 770.622.9858  
f 770.622.9535  
www.hilfoleyrossi.com

© Copyright (as dated below)  
This drawing and all reproductions thereof are the  
property of Hill Foley Rossi & Associates, LLC (HFR).  
It is intended for the sole use of the project named  
herein. Reproduction without the written consent of  
HFR is unlawful. All copies are to be returned to HFR  
upon project completion.

Sealed: 06-12-2020



Suite 101 - Village Podiatry Centers  
Sugar Hill Professional Park,  
4749 Nelson Brogdon Blvd., Bldg. 300 Suite 101  
Sugar Hill, GA, 30518  
Owner:  
DR. CLIFF JOHNSON  
Phone: 678-643-1742

NOT ISSUED FOR  
CONSTRUCTION

ISSUED / REVISIONS:

DATE	DESCRIPTION:

FLOOR PLAN  
HOT & COLD  
WATER

P102

GRANADE ENGINEERING GROUP, LLC  
Consulting Engineers  
12345 Greenmont Walk • Alpharetta, Georgia 30009  
Phone: 678-520-8663 GEG #20117

HFR 20-164.00