

CONVENIENCE STORE for VIPULKUMAR PATEL

RINCON, GEORGIA

4-10-2020



12 A E. GRADY STREET
P.O. BOX 1382
912-764-6288

STATESBORO
GEORGIA 30458


www.dprarch.com

COPYRIGHT 2015 - ALL RIGHTS RESERVED
PRINTED OR ELECTRONIC DRAWINGS AND
DOCUMENTATION MAY NOT BE REPRODUCED
IN ANY FORM WITHOUT WRITTEN PERMISSION
FROM DPR ARCHITECTURE

DESIGN TEAM

ARCHITECTURAL:
DPR ARCHITECTURE
12 A EAST GRADY STREET
STATESBORO, GA 30458
PHONE: (912) 764 - 6288

PERSPECTIVE VIEW

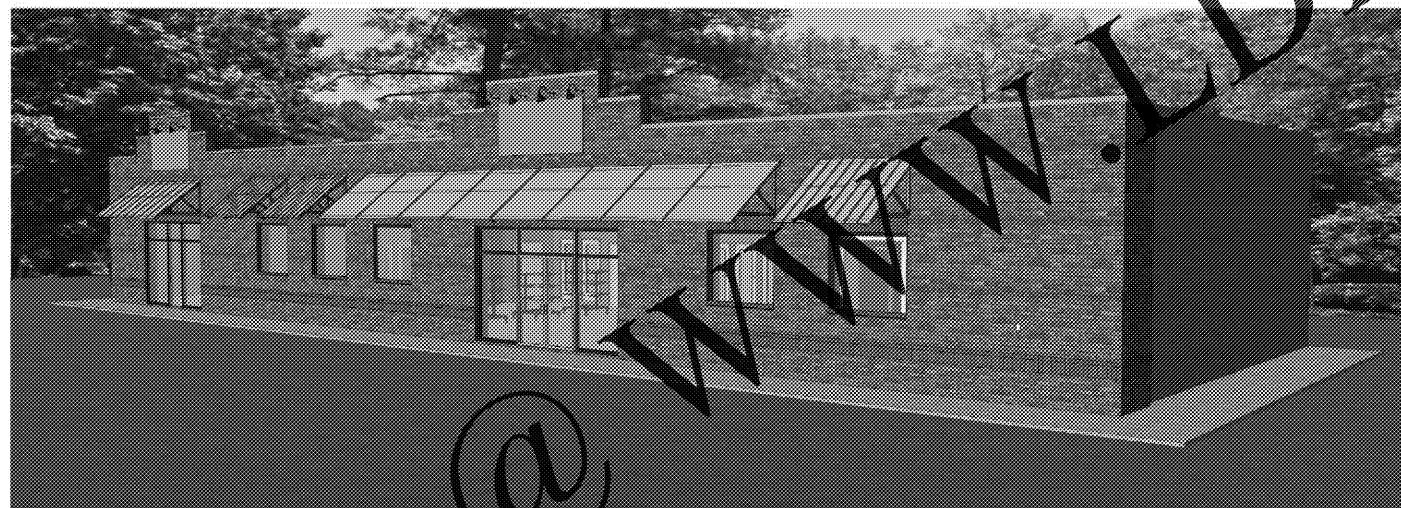

1 3D View 1
00

INDEX OF DRAWING

- 00 TITLE SHEET
- 01 COMERCIAL NOTES
- S1 FOUNDATION PLAN
- A1 FLOOR PLAN
- A1.1 CEILING PLAN
- A2 BUILDING ELEVATIONS
- A3 BUILDING SECTIONS
- A3.1 SECTIONS
- A3.2 DETAILS
- M1 MECHANICAL PLAN
- P1 PLUMBING PLANS
- E1 POWER PLAN
- E2 LIGHTING PLAN

SQUARE FOOTAGE

COOLER	640 SF
STORAGE ROOM	110 SF
OFFICE AND RAISED PLATFORM AREA	245 SF
KITCHEN	220 SF
PRODUCT DISPLAY AREA.	1800 SF

**CONVENIENCE STORE for
VIPULKUMAR PATEL
RINCON, GEORGIA**

SCHEDULE OF REVISIONS

#	DATE

PROJECT NUMBER: 2009
PROJECT DATE: 4-10-2020
DRAWN BY: Author
APPROVED BY: Approver