
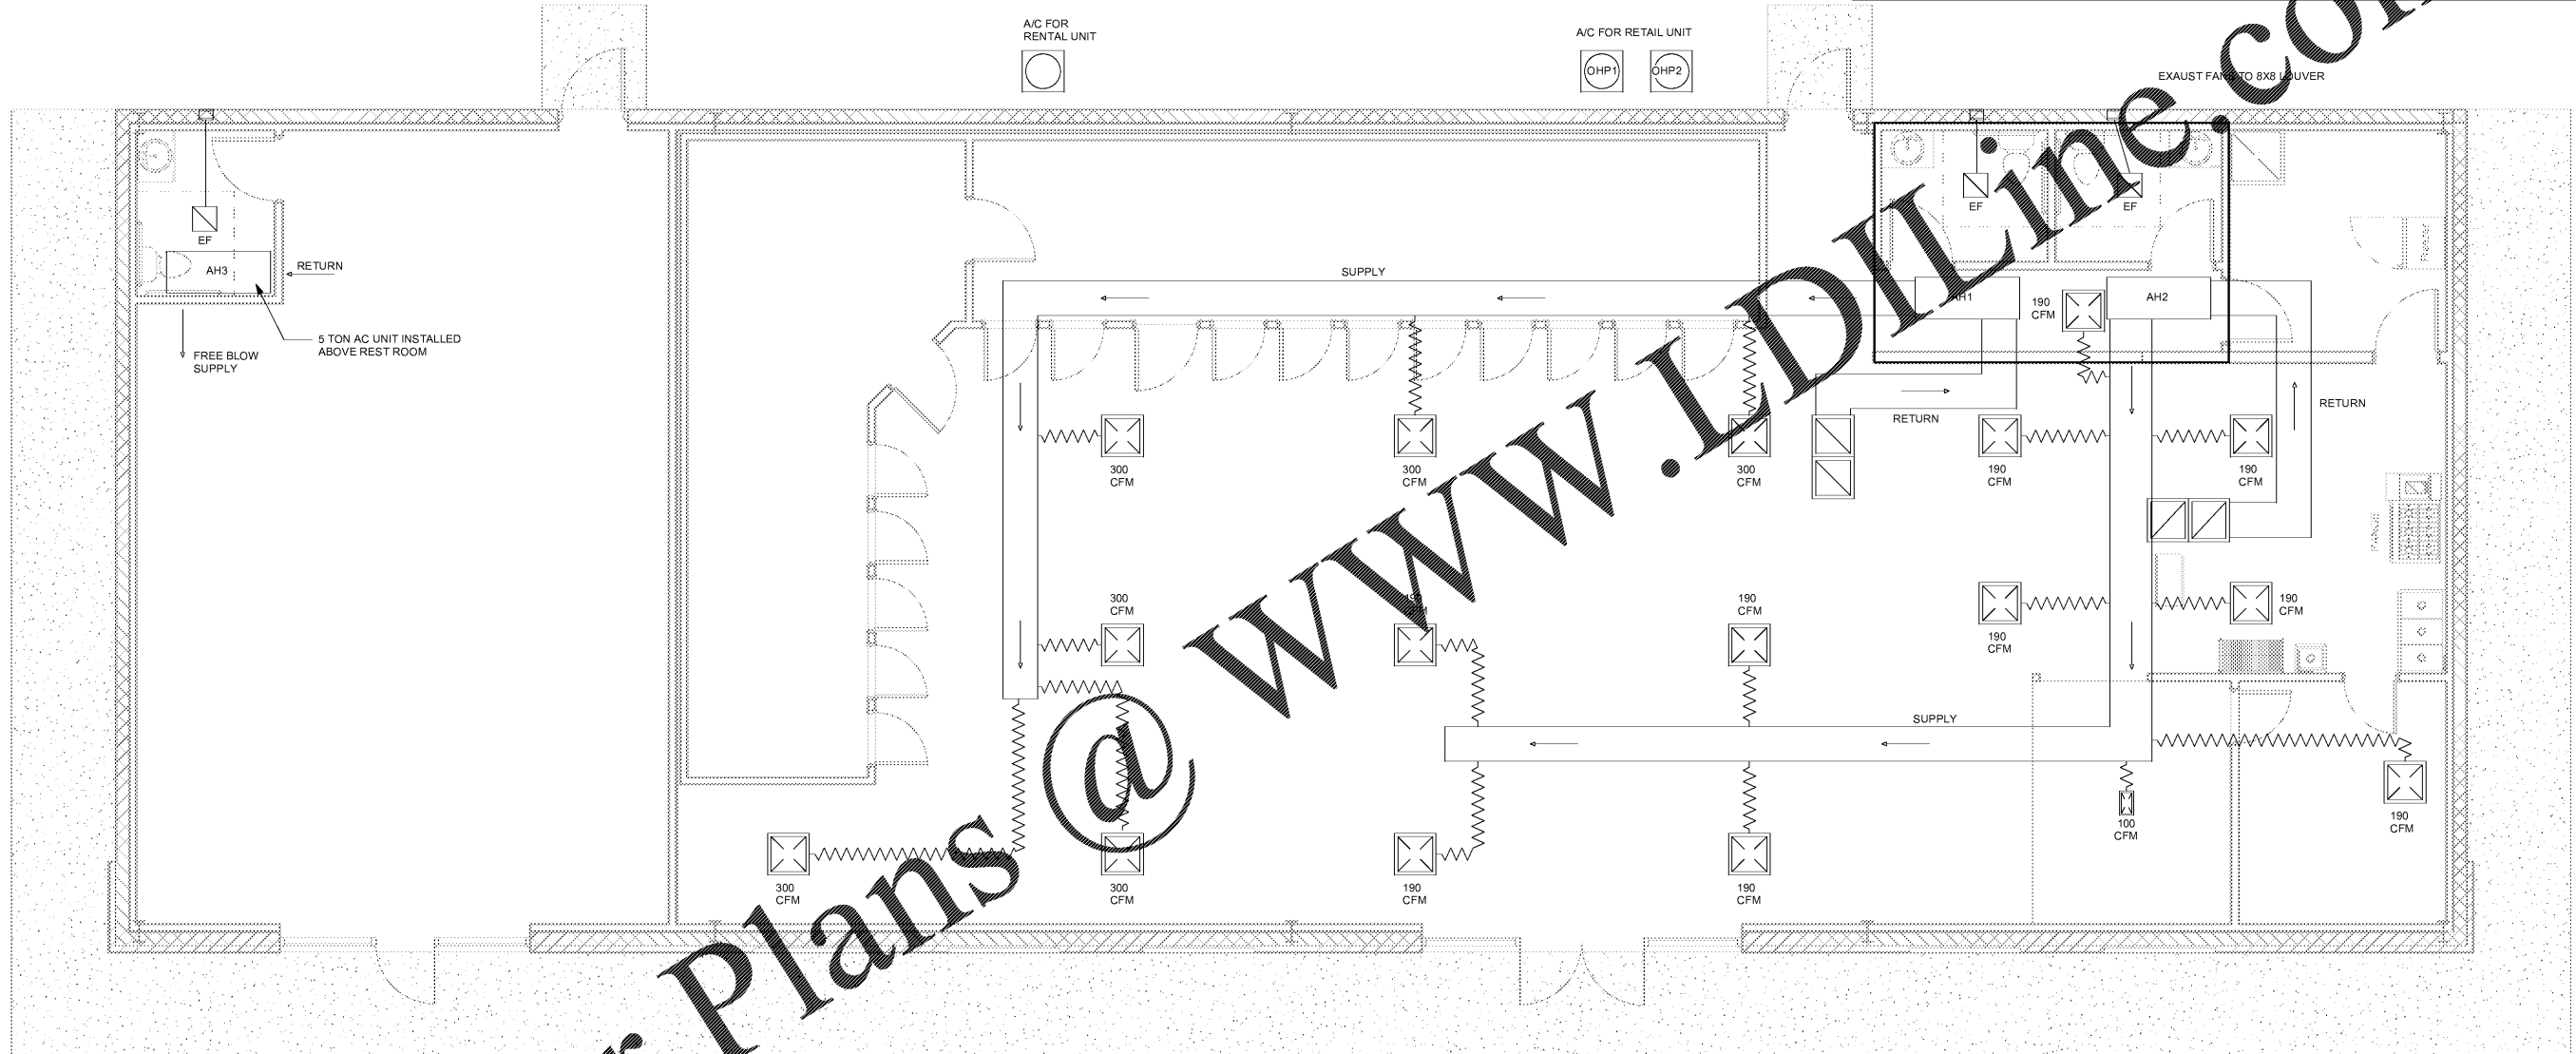


**CONVENIENCE STORE for
VIPULKUMAR PATEL
RINCON, GEORGIA**

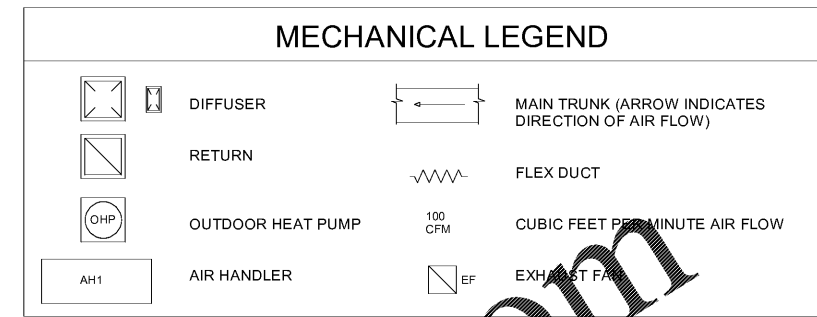

1 MECHANICAL PLAN
M1 1/4" = 1'-0"

SCHEDULE OF REVISIONS

#	DATE

PROJECT NUMBER: 2009
PROJECT DATE: 4-10-2020
DRAWN BY: Author
APPROVED BY: Approver

M1