


**CONVENIENCE STORE for
VIPULKUMAR PATEL
RINCON, GEORGIA**

ELECTRICAL LEGEND

EP	ELECTRIC PANEL
GFI	DUPLEX (GFI INDICATES GROUND FAULT INTERRUPTING)
WP	DUPLEX (WP INDICATES WEATHER PROOF)
9'-8" AFF	DUPLEX MOUNTED AT HEIGHT ABOVE FINISH FLOOR AS NOTED
S	SWITCH
S ₃	3 - WAY SWITCH
JB	JUNCTION BOX
○	SURFACE MOUNTED FIXTURE
HD	HD DISCONNECT

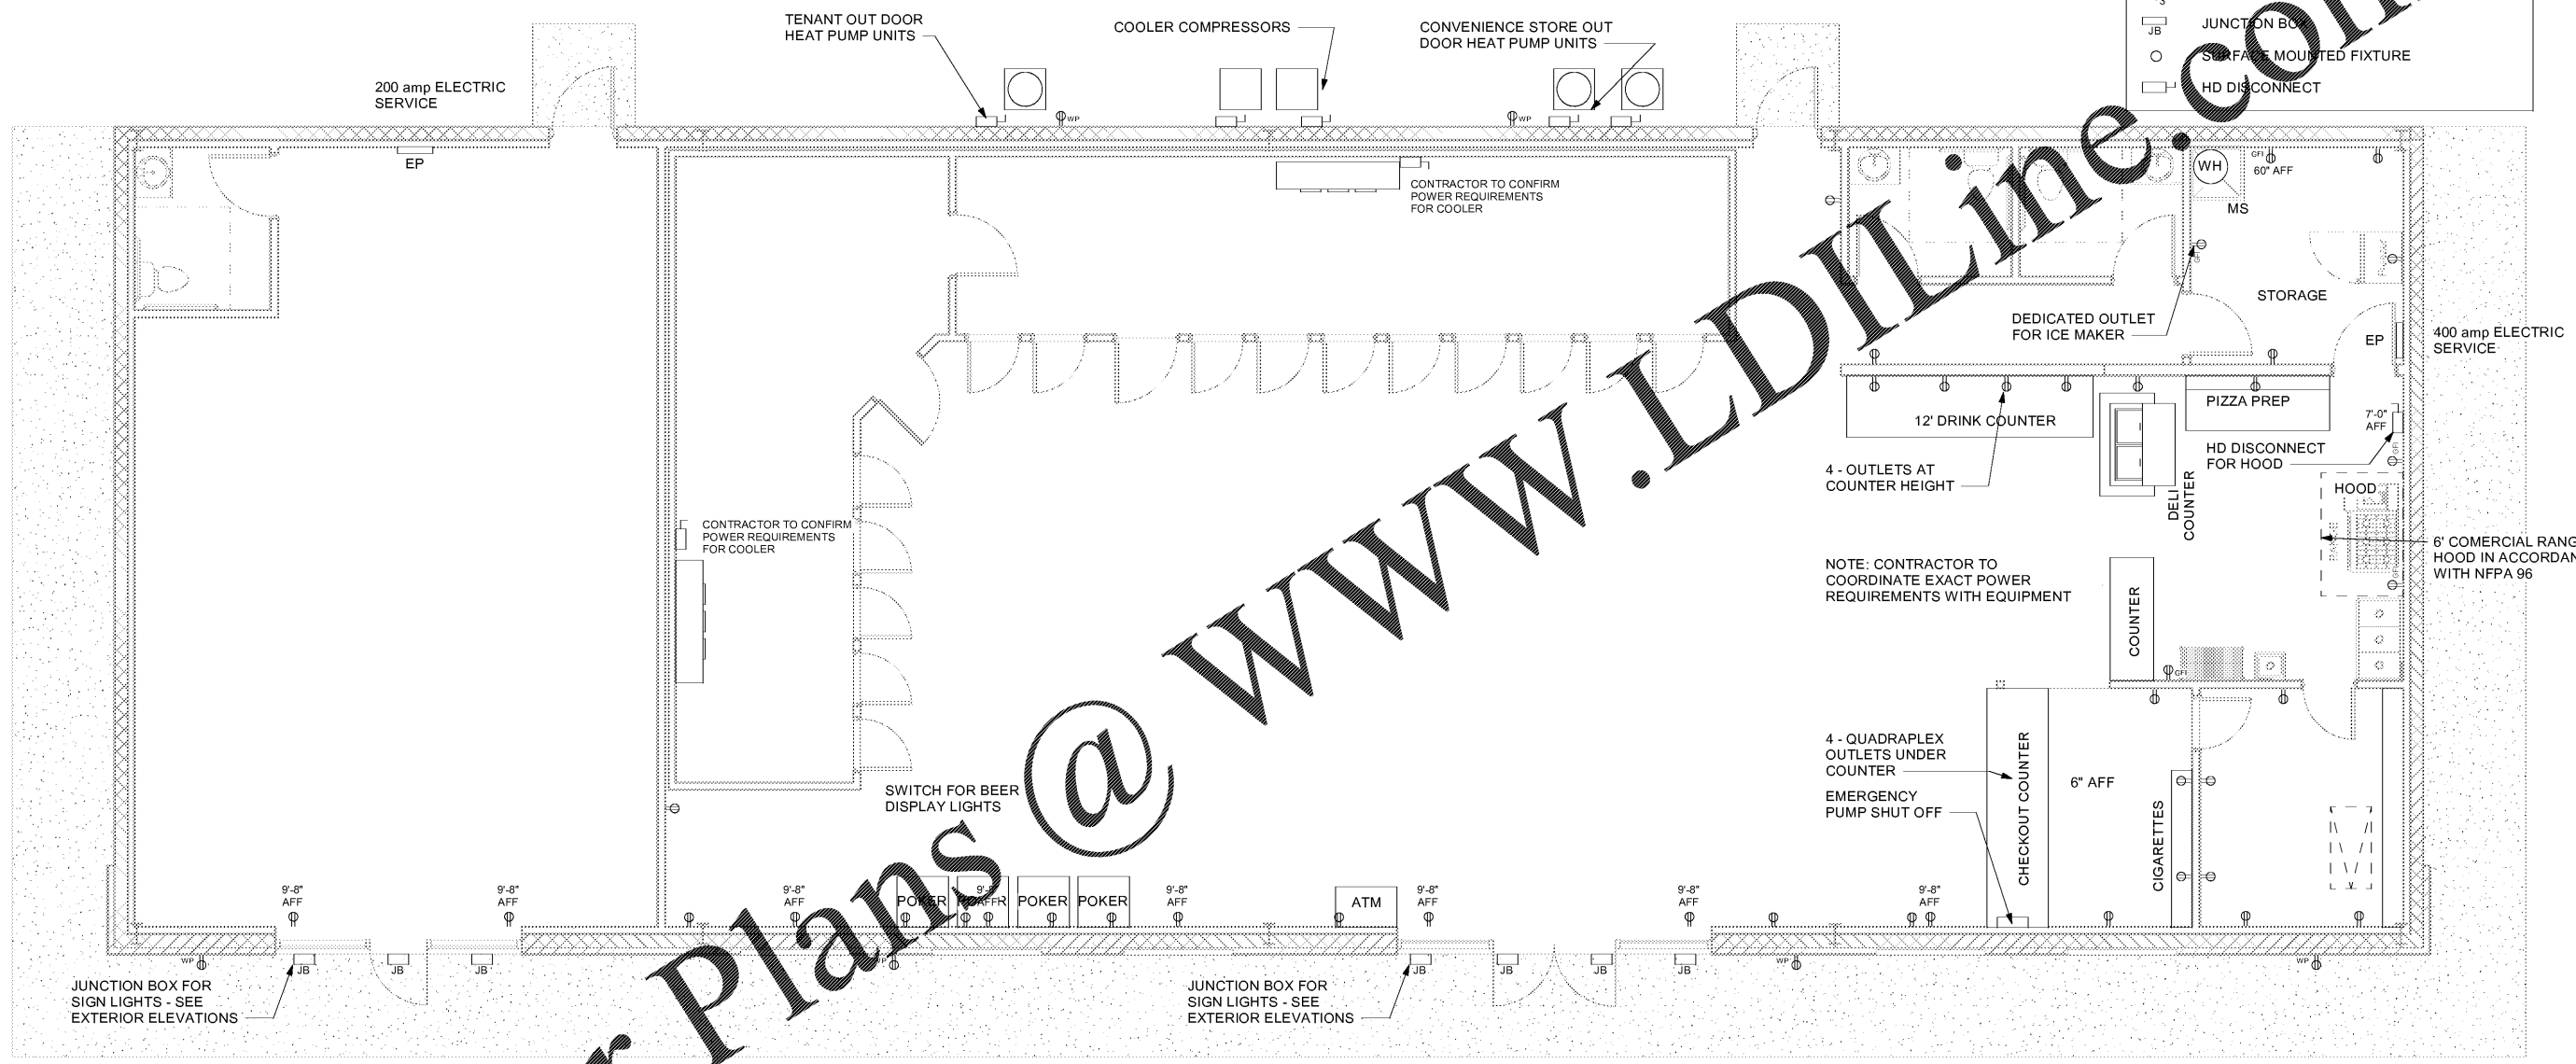

1 ELECTRIC PLAN
E1 1/4" = 1'-0"

SCHEDULE OF REVISIONS

#	DATE

PROJECT NUMBER: 2009
PROJECT DATE: 4-10-2020
DRAWN BY: CL / FRD
APPROVED BY: FRD

E1