


**KEYED NOTES (THIS SHEET ONLY)**

- ① MECHANICAL CONTRACTOR TO DEMOLISH ALL EXISTING HVAC EQUIPMENT, DUCTWORK, GRILLES, CONTROLS, PIPING AND ASSOCIATED APPURTENANCES.
- ② MECHANICAL CONTRACTOR TO DEMOLISH EXISTING CONDENSING UNITS, CONTROLS, PIPING AND ASSOCIATED APPURTENANCES.

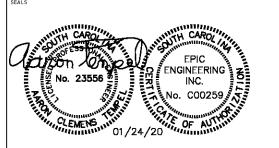

**EPIC ENGINEERING INC.**  
P.O. BOX 2132 • MT. PLEASANT, SC 29485  
(843) 549-8876 • EPIC JOB NO. 19086




**THE OPPORTUNITY CENTER**  
8570 RIVERS AVE. N. CHARLESTON, SC

SHEET ISSUE:  
01/14/2020 Revise Set  
01/24/2020 FormBldg Set

PRINCIPAL IN CHARGE: ACT  
PROJECT ENGINEER: ACT  
DRAWN BY: RAD  
SHEET TITLE:  
**MECHANICAL PLAN**

PROJ. NO. MFS 017348.00

SHEET NO.  
**MD101**

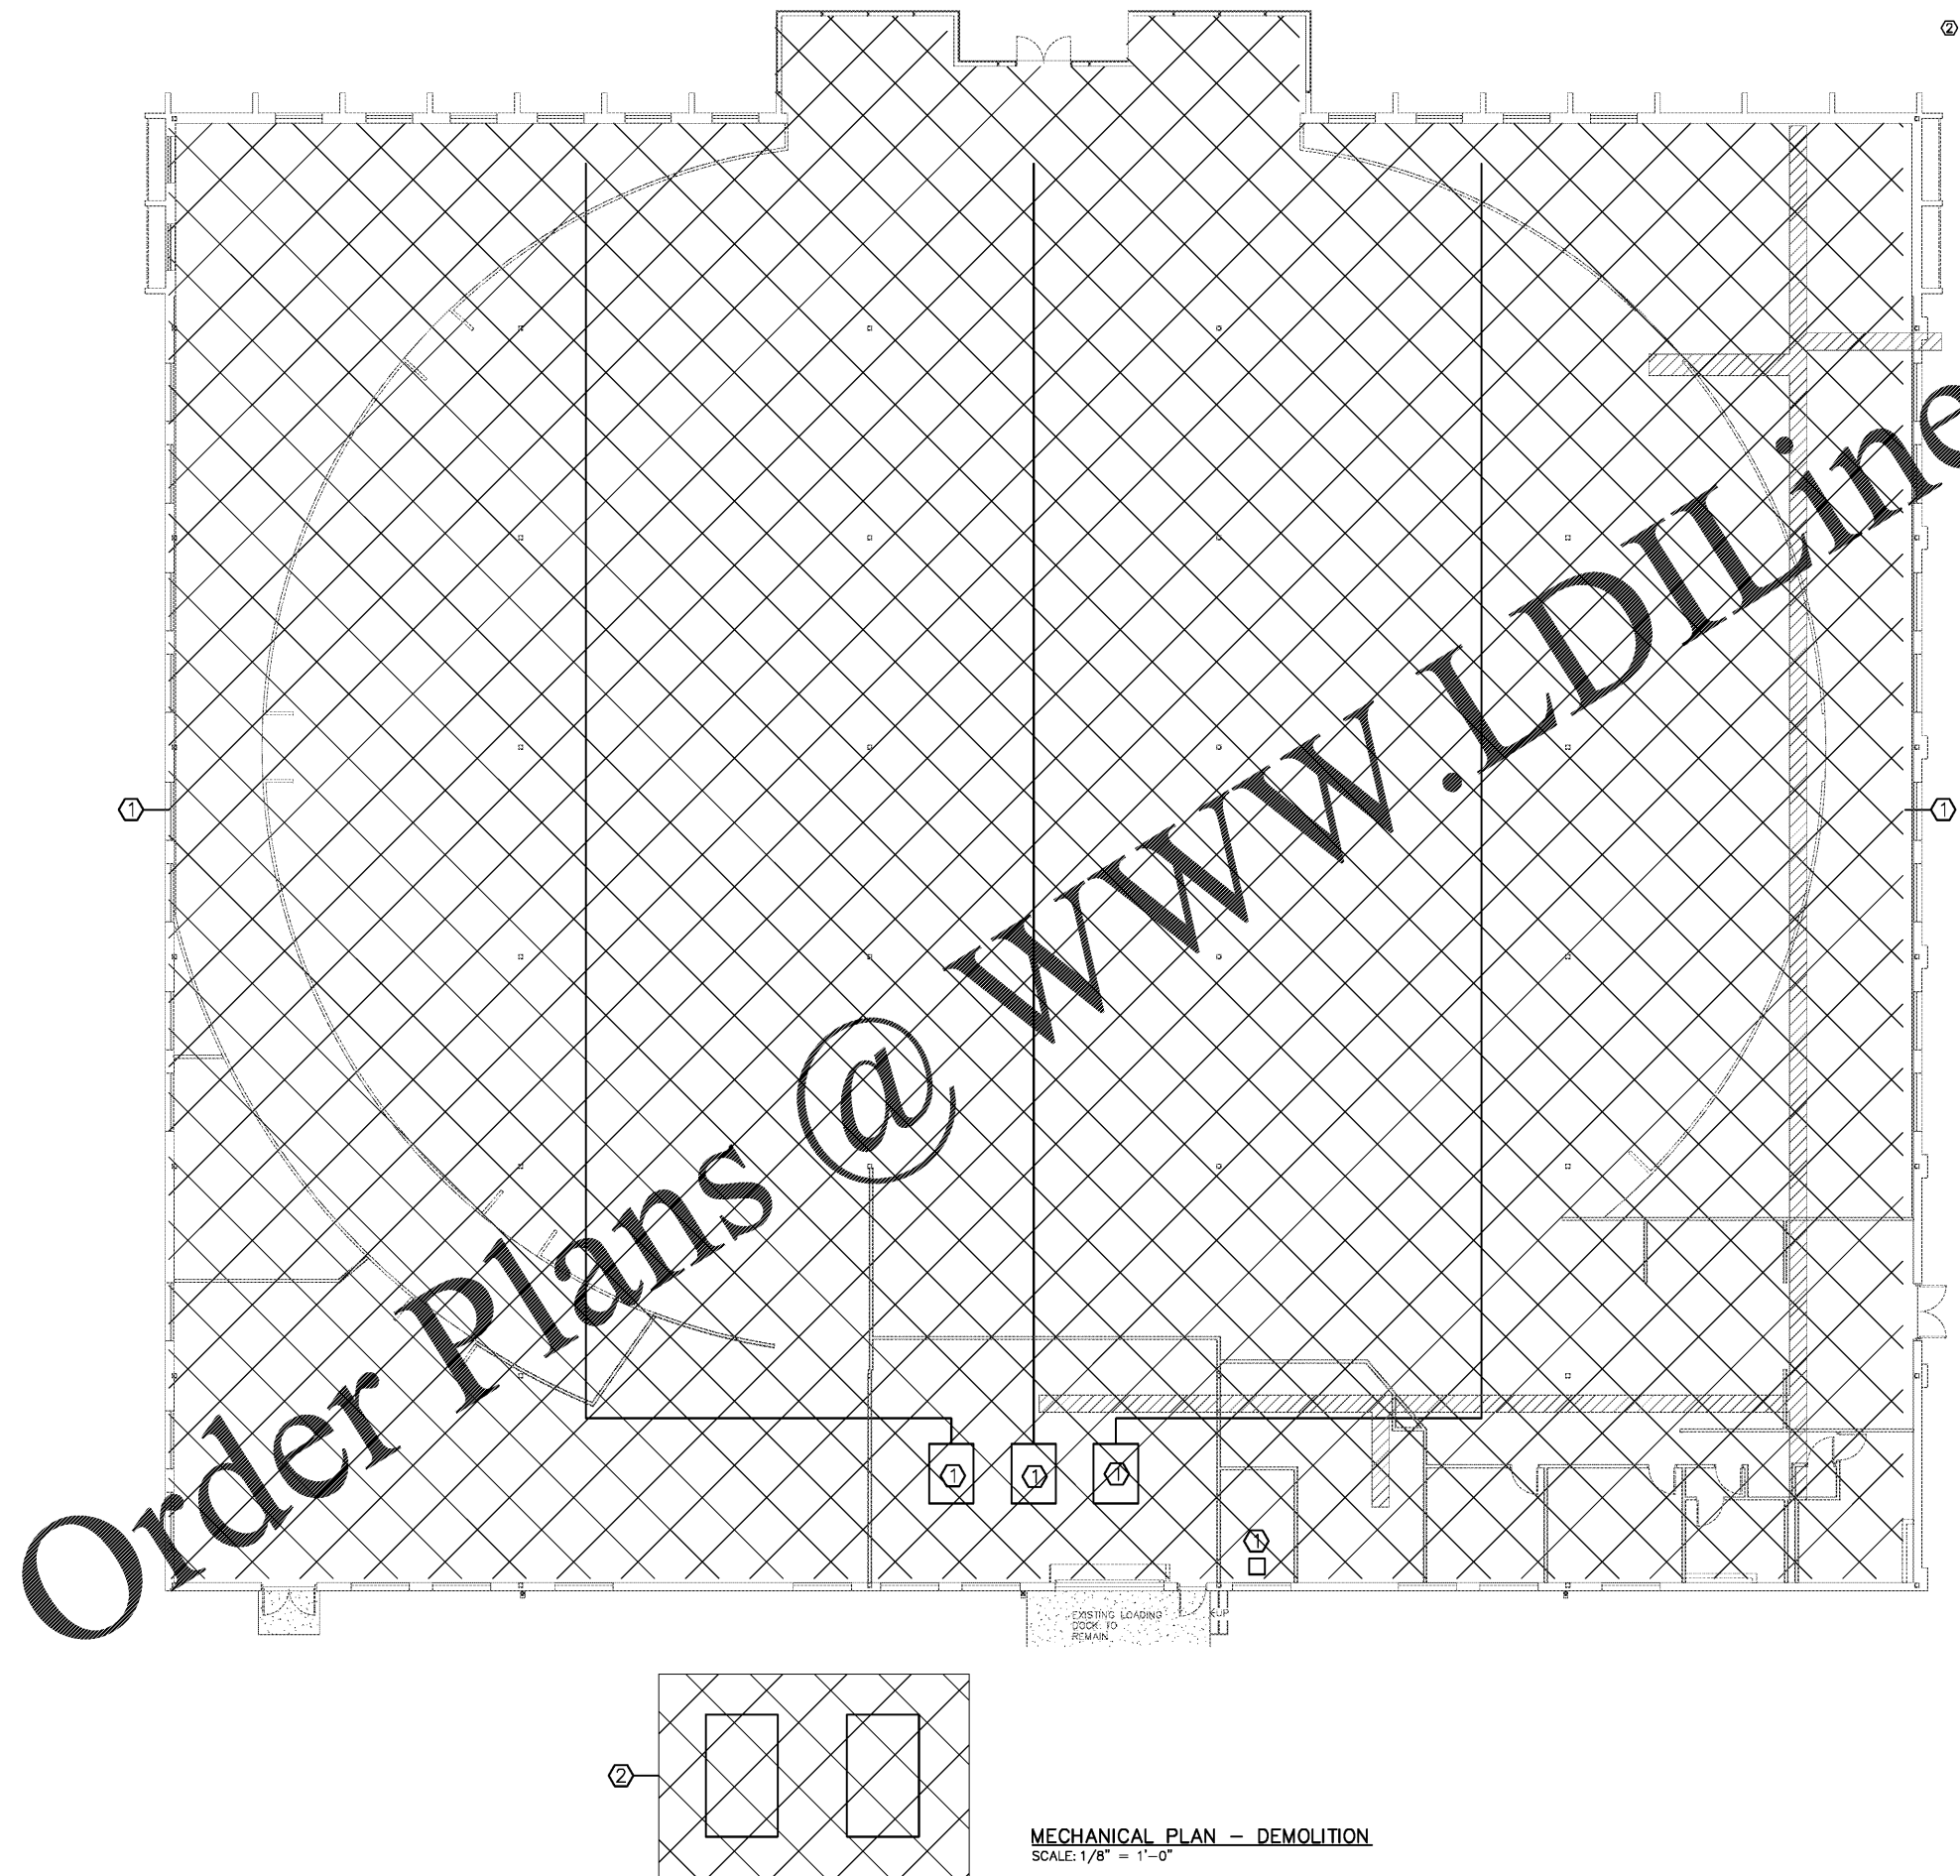

**MECHANICAL PLAN - DEMOLITION**  
SCALE: 1/8" = 1'-0"

ALL DIMENSIONS UNLESS OTHERWISE SPECIFIED ARE IN DECIMALS OF FEET AND FRACTIONS THEREOF. THIS DRAWING IS THE PROPERTY OF EPIC ENGINEERING INC. AND IS NOT TO BE REPRODUCED OR TRANSMITTED IN ANY FORM OR BY ANY MEANS, ELECTRONIC OR MECHANICAL, INCLUDING PHOTOCOPYING, RECORDING, OR BY ANY INFORMATION STORAGE AND RETRIEVAL SYSTEM, WITHOUT THE WRITTEN PERMISSION OF EPIC ENGINEERING INC. ALL RIGHTS RESERVED.