


KEYED NOTES (THIS SHEET ONLY)
 ① PLUMBING CONTRACTOR TO DEMOLISH ALL EXISTING PLUMBING FIXTURES, PIPING, AND ASSOCIATED APPURTENANCES.



EPIC ENGINEERING INC.
 P.O. BOX 2132 • MT. PLEASANT, SC 29485
 (843) 548-8876 • EPIC JOB NO. 19086

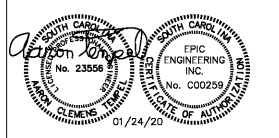


THE OPPORTUNITY CENTER
 8570 RIVERS AVE. N. CHARLESTON, SC

SHEET ISSUE:
 01/14/2020 Revise Set
 01/24/2020 FormB/E4 Set

PRINCIPAL IN CHARGE: ACT
 PROJECT ENGINEER: ACT
 DRAWN BY: RAD
 SHEET TITLE:
PLUMBING DEMOLITION PLAN
 PROJ. NO. MFS 017348.00

SHEET NO.
PD101

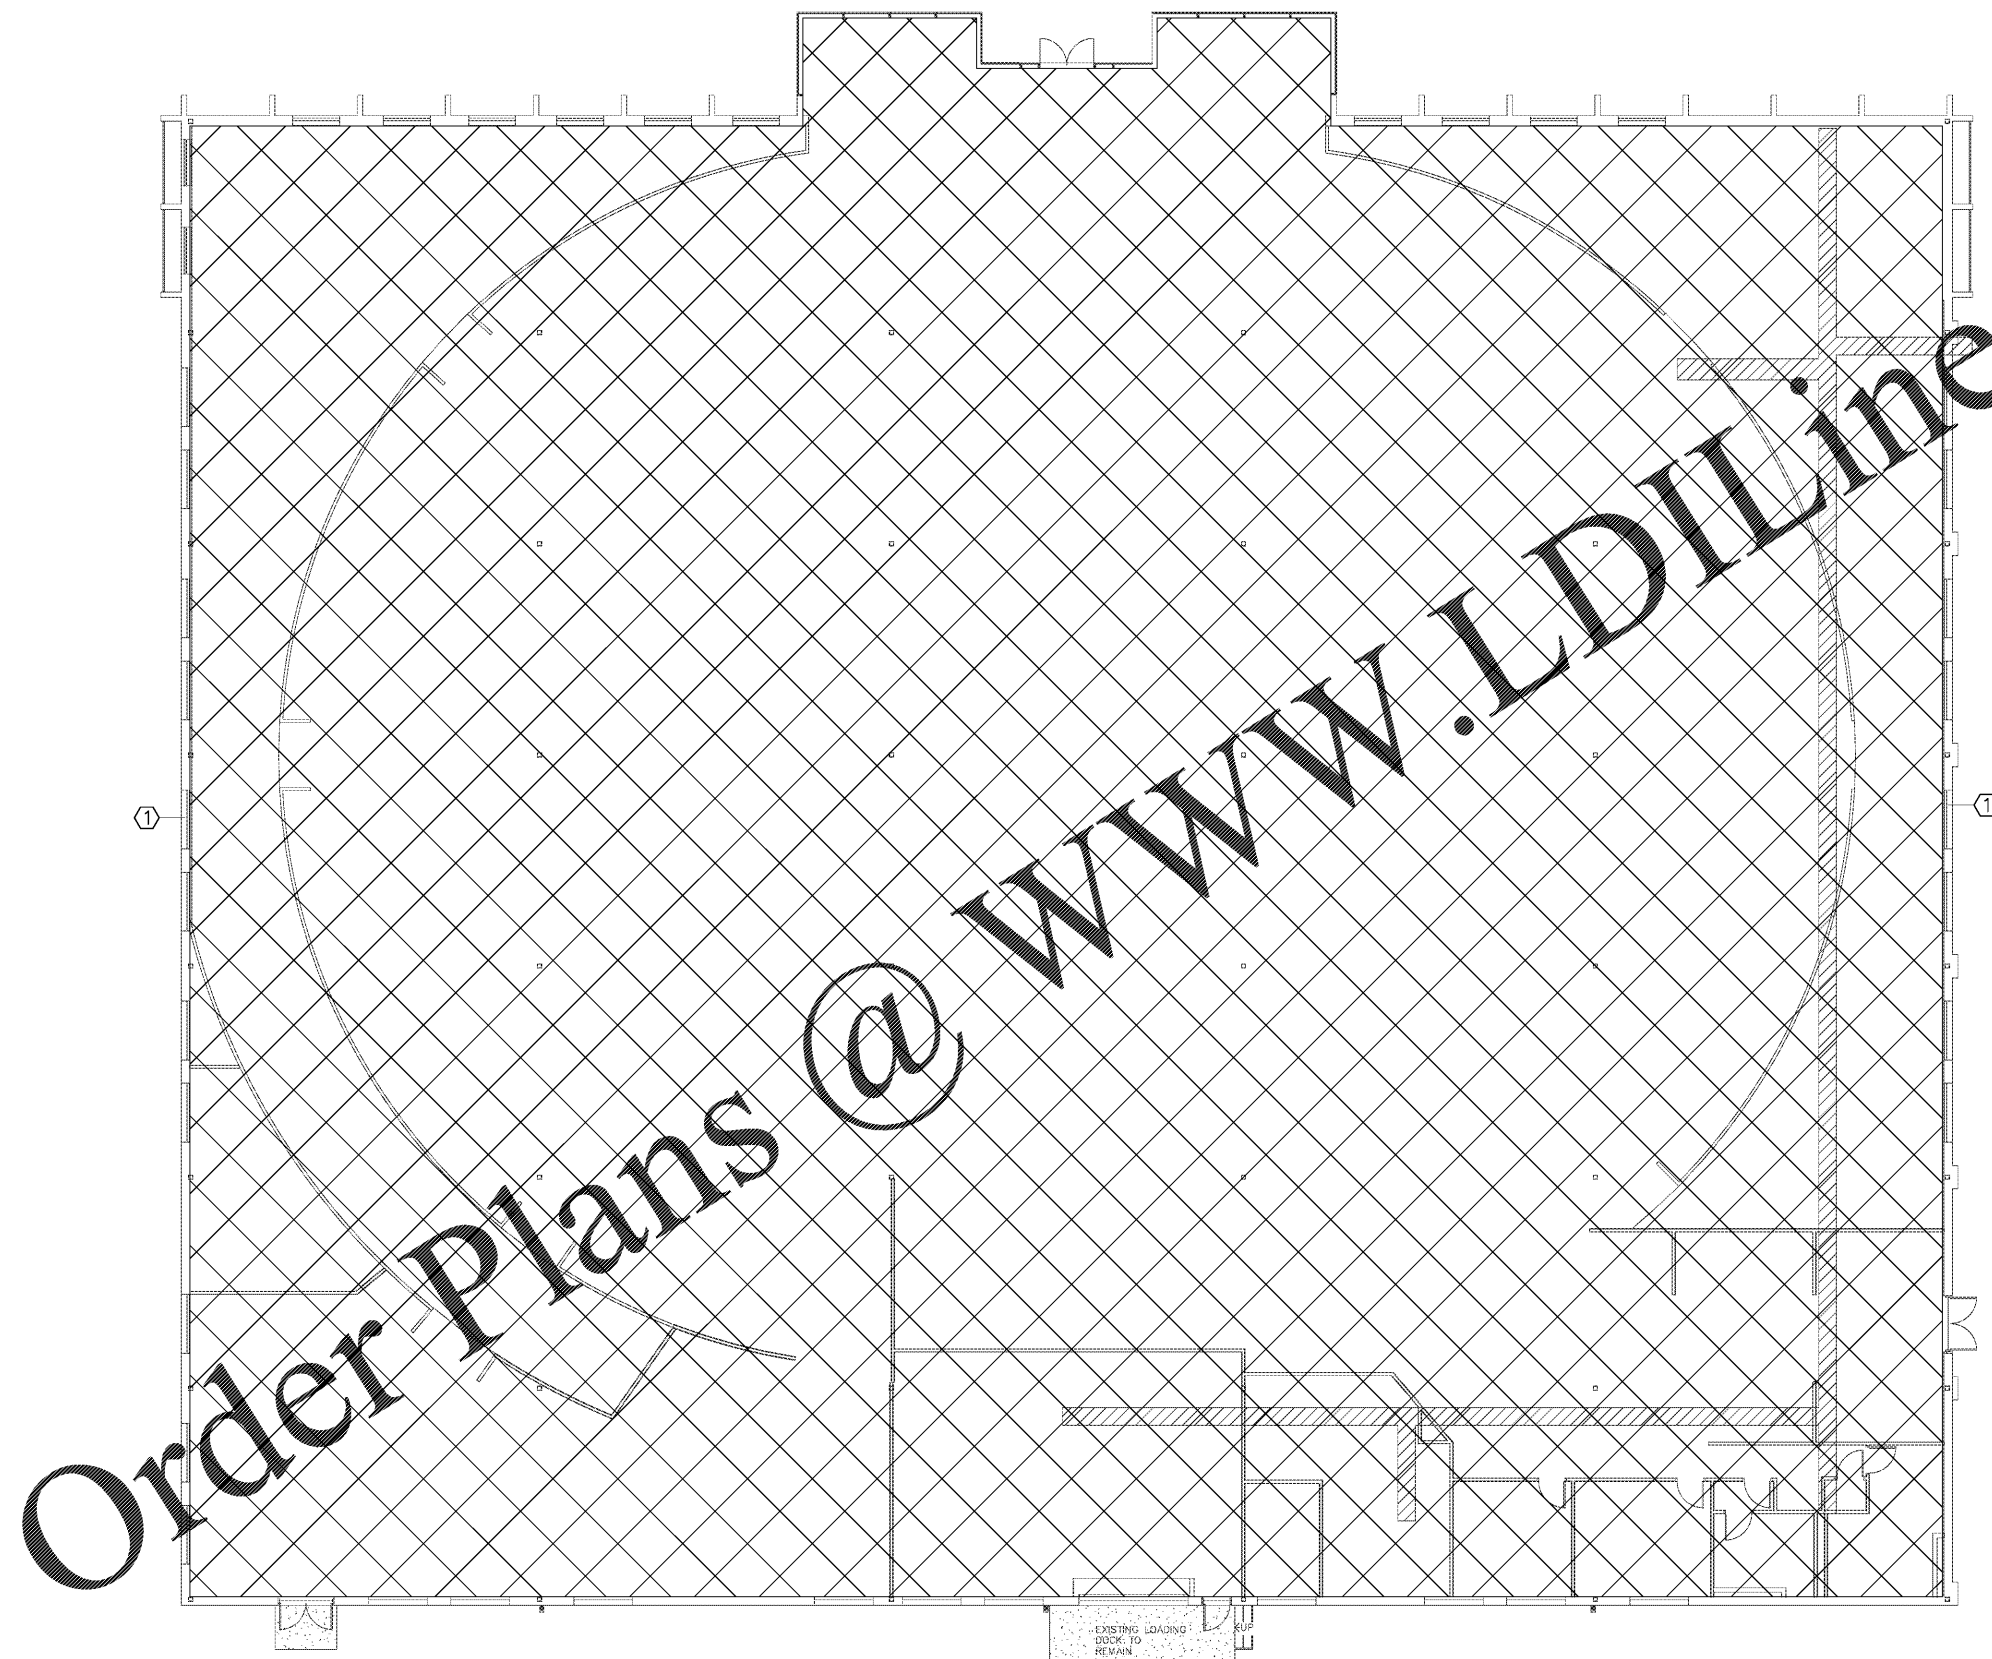

PLUMBING PLAN — DEMOLITION
 SCALE: 1/8" = 1'-0"

Order Plans @ www.LDILine.com

ALL DIMENSIONS UNLESS OTHERWISE SPECIFIED ARE IN DECIMALS OF FEET. THE CONTRACTOR SHALL BE RESPONSIBLE FOR OBTAINING ALL NECESSARY PERMITS AND APPROVALS FROM THE LOCAL, STATE, AND FEDERAL AUTHORITIES. THE CONTRACTOR SHALL BE RESPONSIBLE FOR OBTAINING ALL NECESSARY PERMITS AND APPROVALS FROM THE LOCAL, STATE, AND FEDERAL AUTHORITIES. THE CONTRACTOR SHALL BE RESPONSIBLE FOR OBTAINING ALL NECESSARY PERMITS AND APPROVALS FROM THE LOCAL, STATE, AND FEDERAL AUTHORITIES. ALL RIGHTS RESERVED.