



**KEYED NOTES (THIS SHEET ONLY)**

- ① PROVIDE UP/DOWN SWITCH COMPATIBLE WITH DROP DOWN PROJECTION SCREEN PROVIDED.
- ② PROVIDE 4-PORT INTERSYSTEM GROUND BAR. SEE POWER RISER DIAGRAM, SHEET E402.

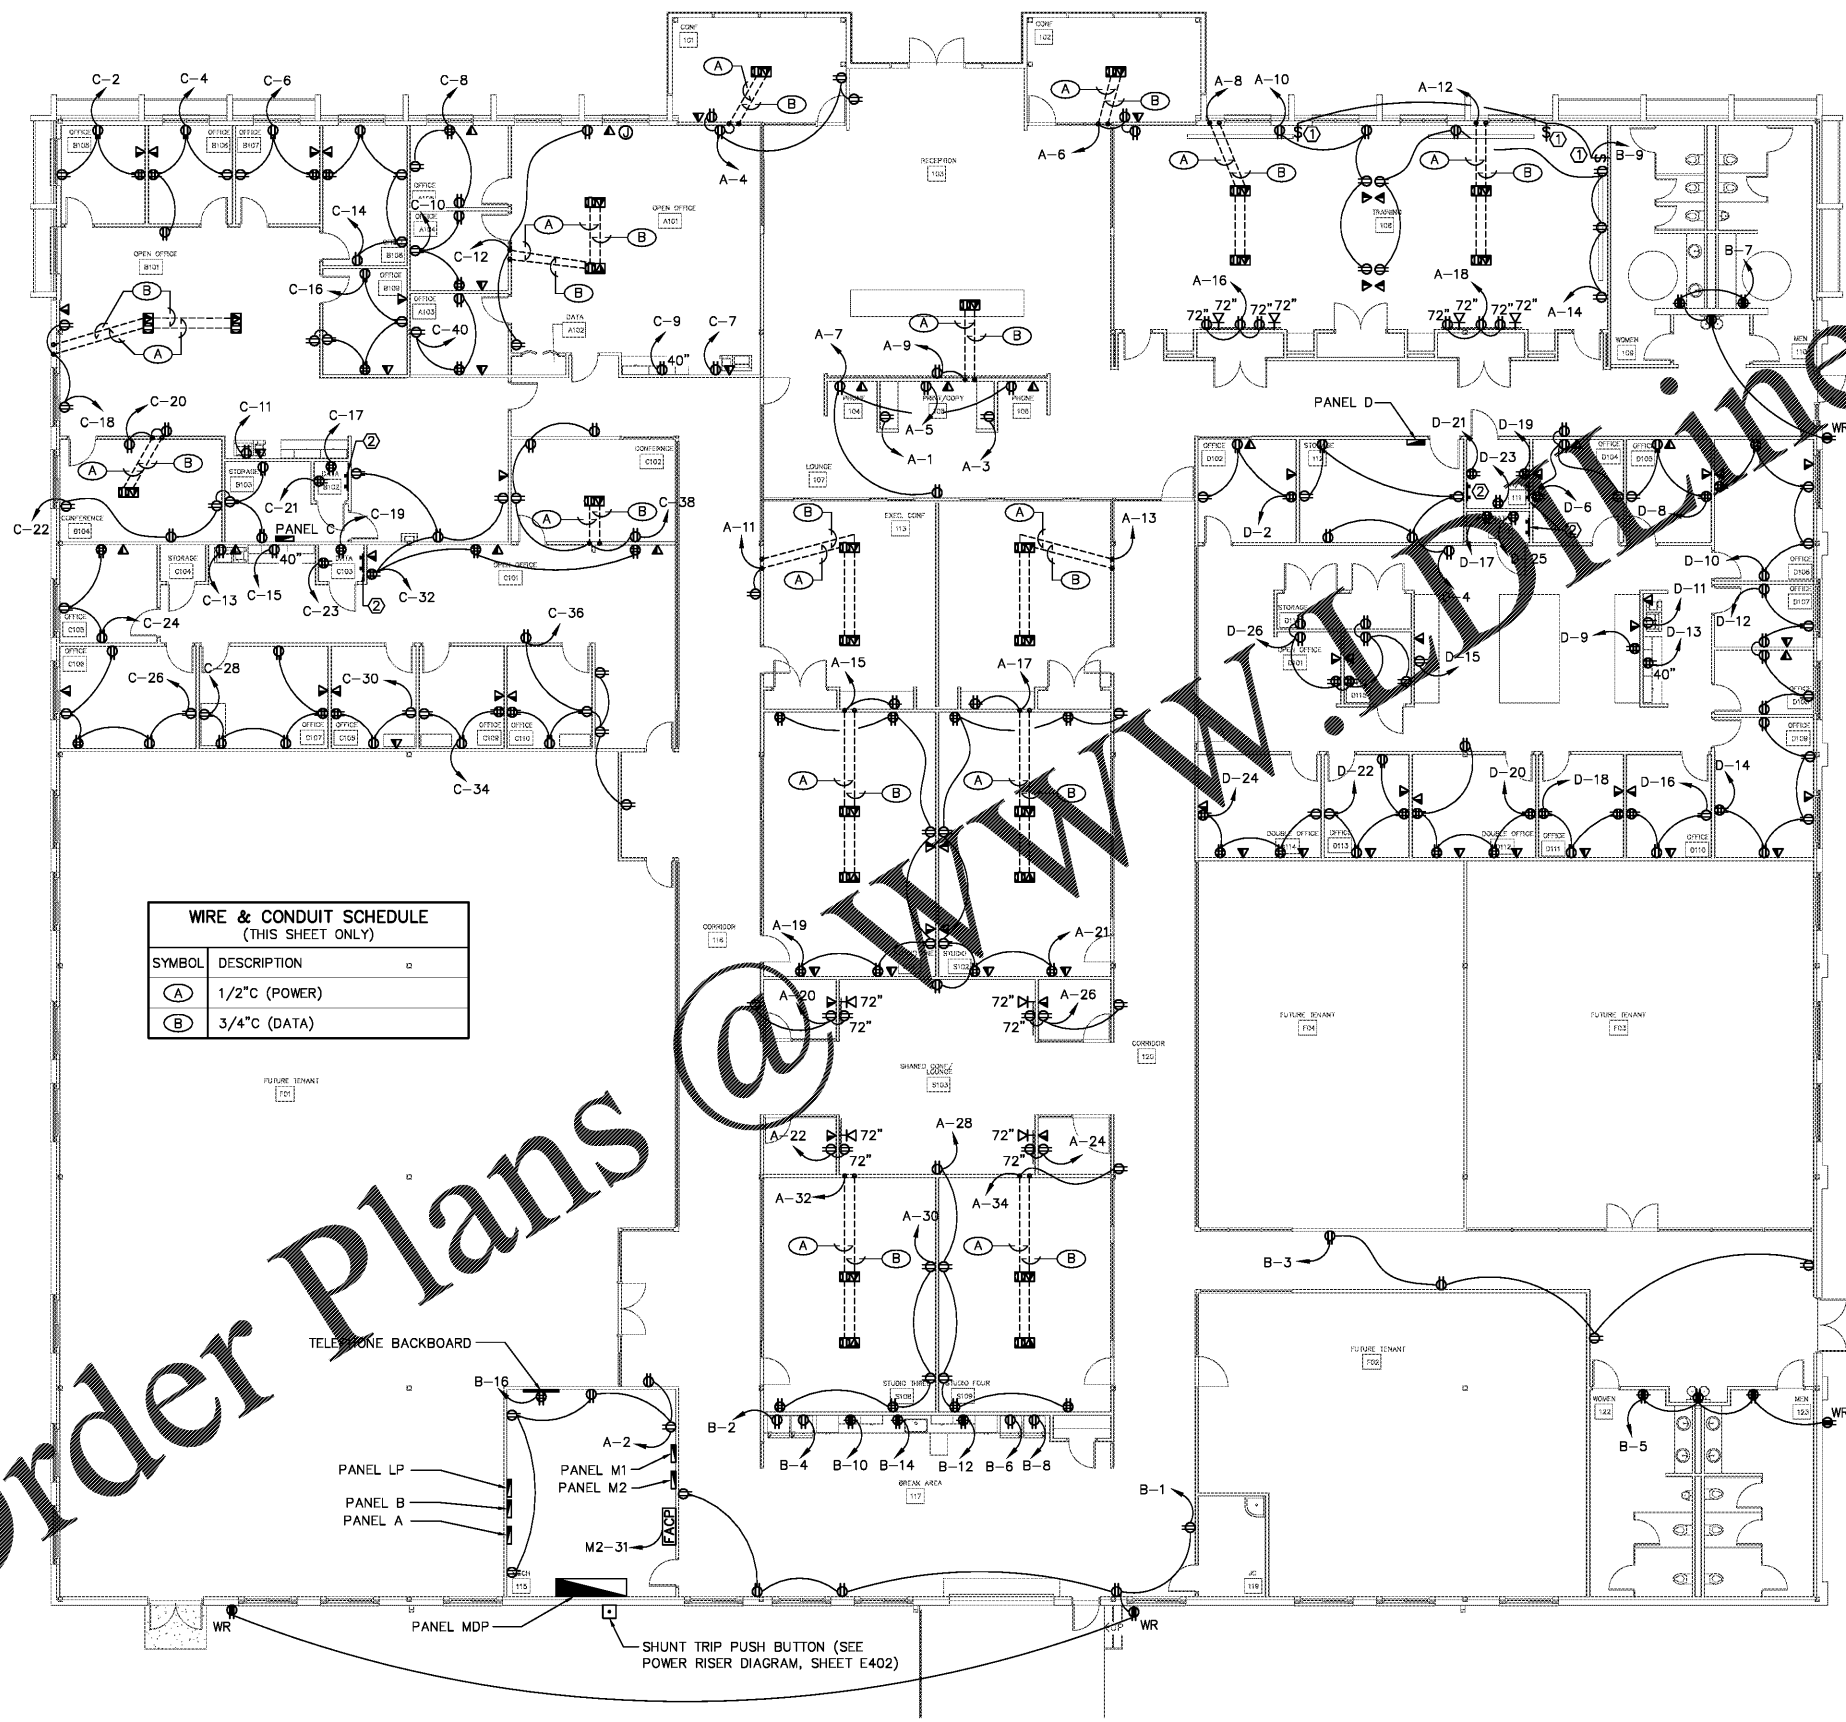

**EPIC ENGINEERING INC.**  
 P.O. BOX 2132 • MT. PLEASANT, SC 29485  
 (843) 949-6876 EPIC JOB NO. 19086

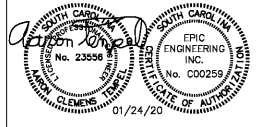

Order Plans @ [www.dnline.com](http://www.dnline.com)

**POWER - RENOVATION PLAN**  
 SCALE: 1/8" = 1'-0"

THE OPPORTUNITY CENTER  
 8570 RIVERS AVE N CHARLESTON, SC

SHEET ISSUE:  
 01/14/2009 Redline Set  
 01/24/2009 Furnish Set

PRINCIPAL IN CHARGE: ACT  
 PROJECT ENGINEER: ACT  
 DRAWN BY: RAD  
 SHEET TITLE: POWER RENOVATION PLAN  
 PROJ. NO: MFS 01748.00

SHEET NO. E102