

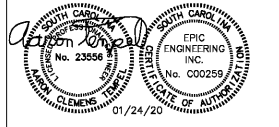
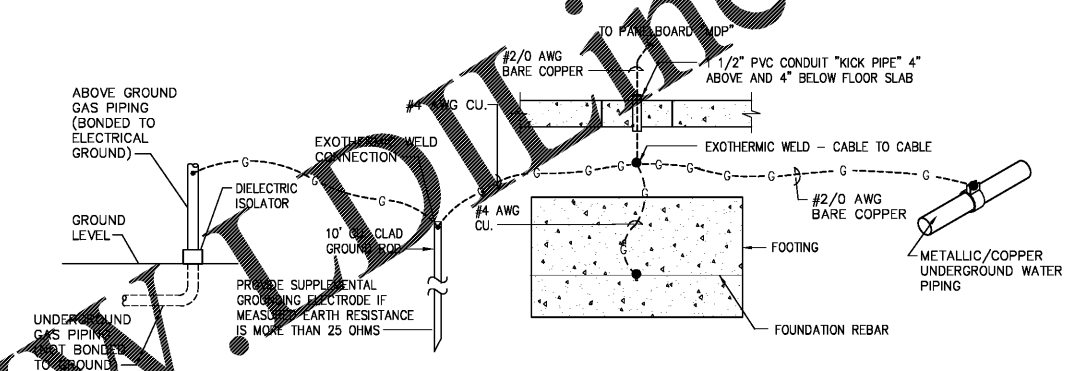


CONSULTANT LOGO

SEALS

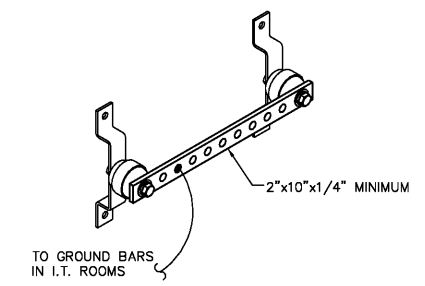


THE OPPORTUNITY CENTER  
8570 RIVERS AVE. N CHARLESTON, SC

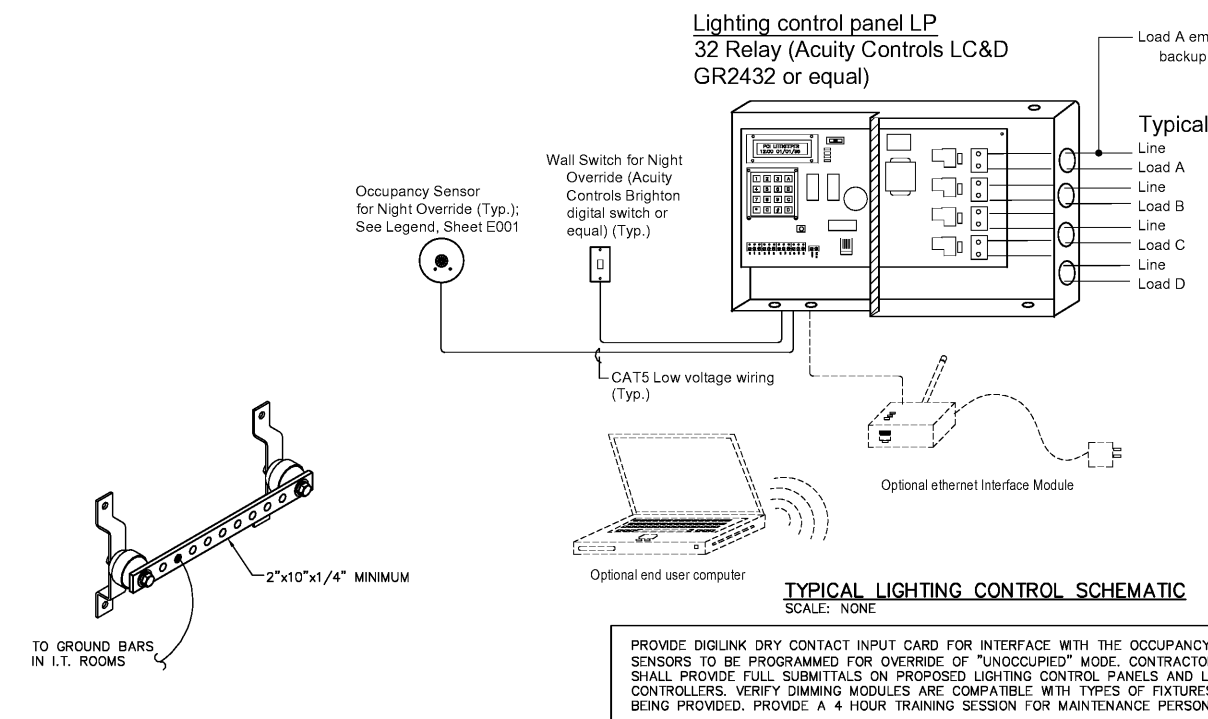

**INTERSYSTEM GROUND BAR DETAIL**  
SCALE: NONE

**TYPICAL GROUNDING CONNECTION AT BUILDING STEEL**  
SCALE: NONE

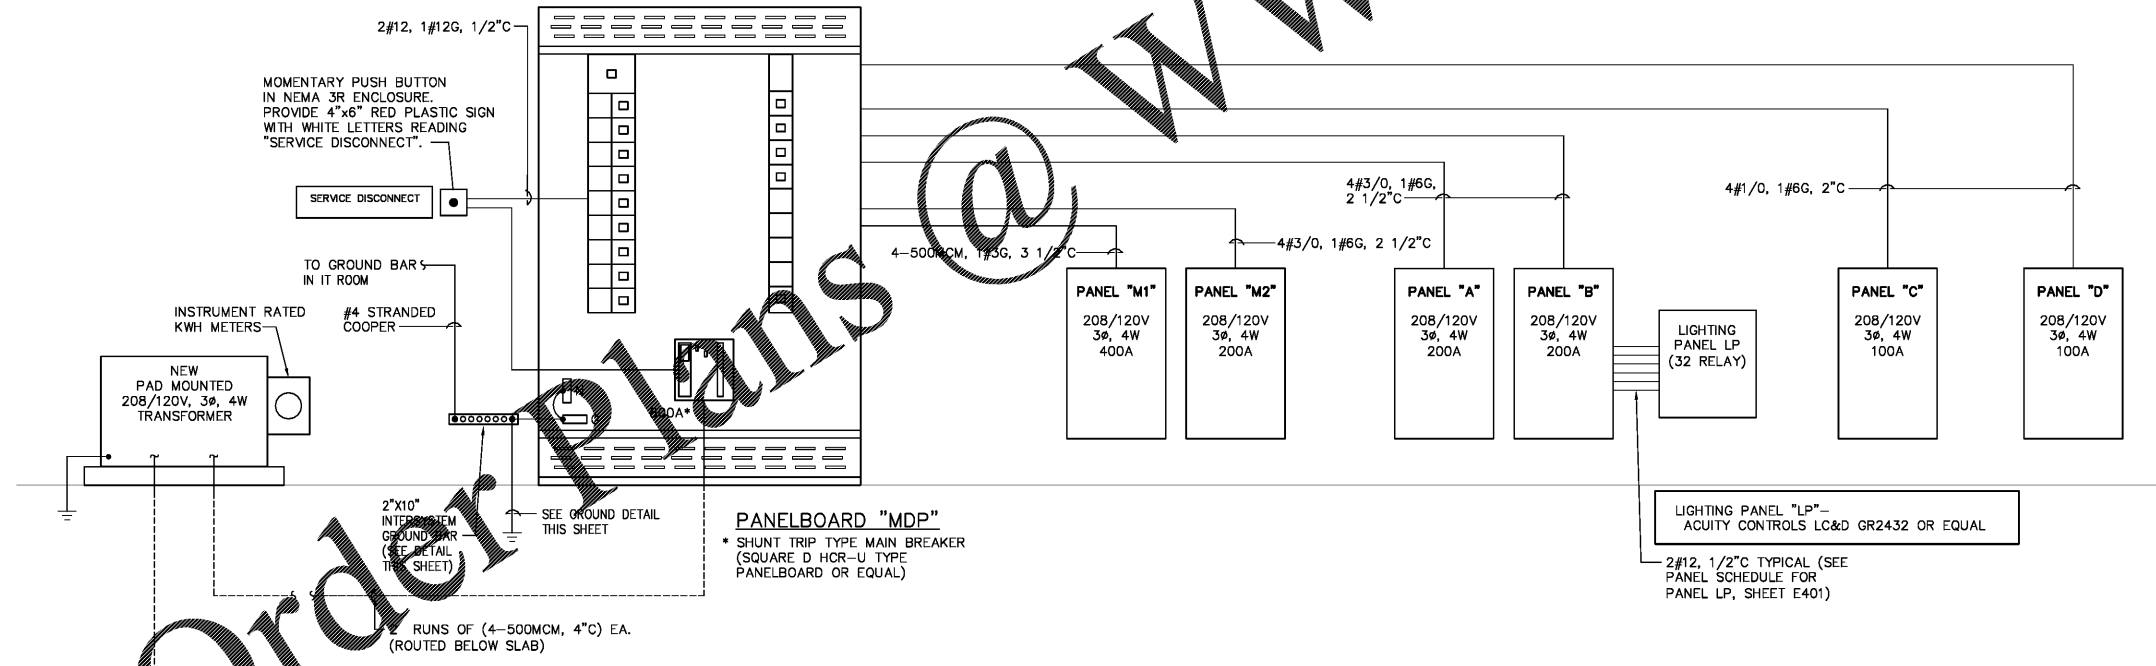

Order Plans @

WWW.onlinedownload.com

SHEET ISSUE:  
01/14/2020 Review Set  
01/24/2020 Panel/Eld Set

PRINCIPAL IN CHARGE: ACT  
PROJECT ENGINEER: ACT  
DRAWN BY: RAD

SHEET TITLE:  
**POWER RISER,  
PANEL SCHEDULES**

PROJ. NO. MPS  
01748.00

SHEET NO.