


REVISIONS/ISSUANCES	
NO.	DESCRIPTION

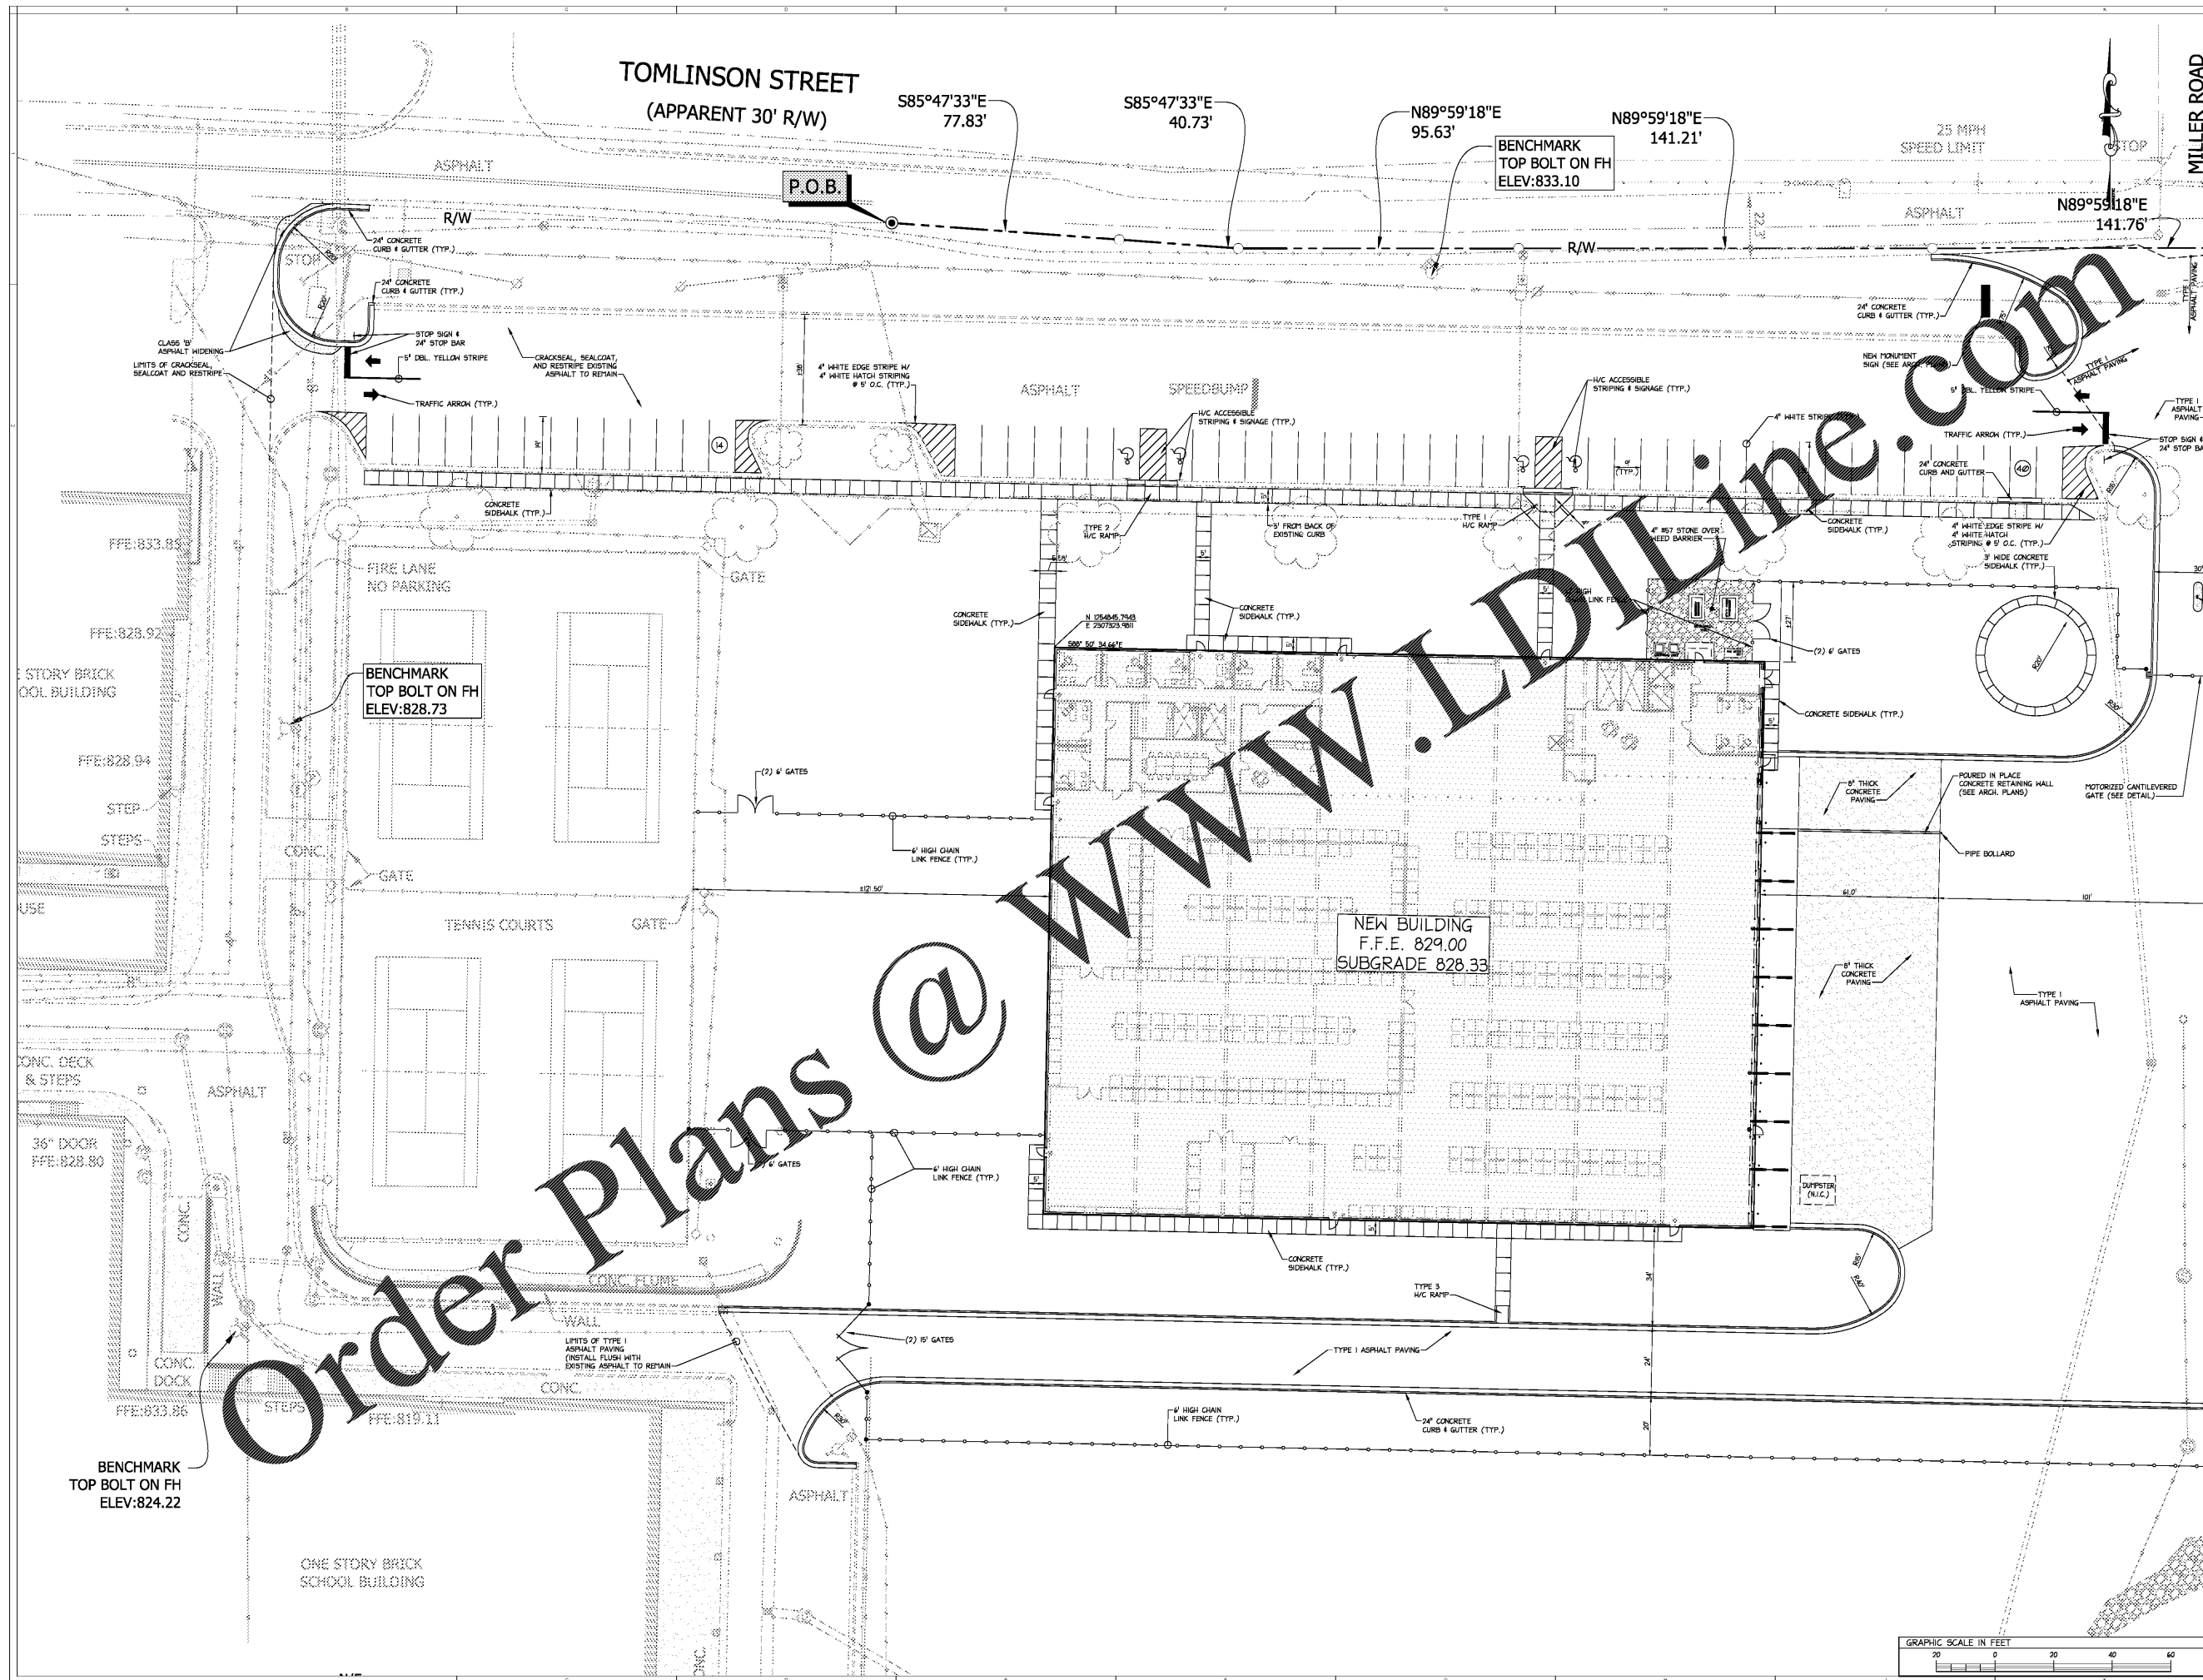

Order Plans @



KEY PLAN
Call before you dig



Carter Engineering Group
6310 Peach Road, Suite 200
Macon, GA 31210
(478) 219-2500



DESIGN PROFESSIONAL 2001
ISSUED: 11/2017 EXPIRES: 11/2022



Manley Spangler Smith Architects
A Professional Corporation

525 East Taylor St.
P.O. Box 880
Gulfport, Georgia 30224
Office: 770.227.5473
Fax: 770.228.3442

PROJECT:
HENRY COUNTY SCHOOLS DISTRIBUTION CENTER

CLIENT:
HENRY COUNTY BOARD OF EDUCATION

SHEET TITLE:
SITE LAYOUT AND PAVING PLAN SECTOR 1

© 2020 Manley Spangler Smith Architects, PC
PROJECT NUMBER: 201627
DATE: 08.13.20
SCALE: 1" = 20'
DRAWN BY: BCS
CHECKED BY: DLC

SHEET NO.: **C3.1**

