



Order Plans @ www.LDILine.com

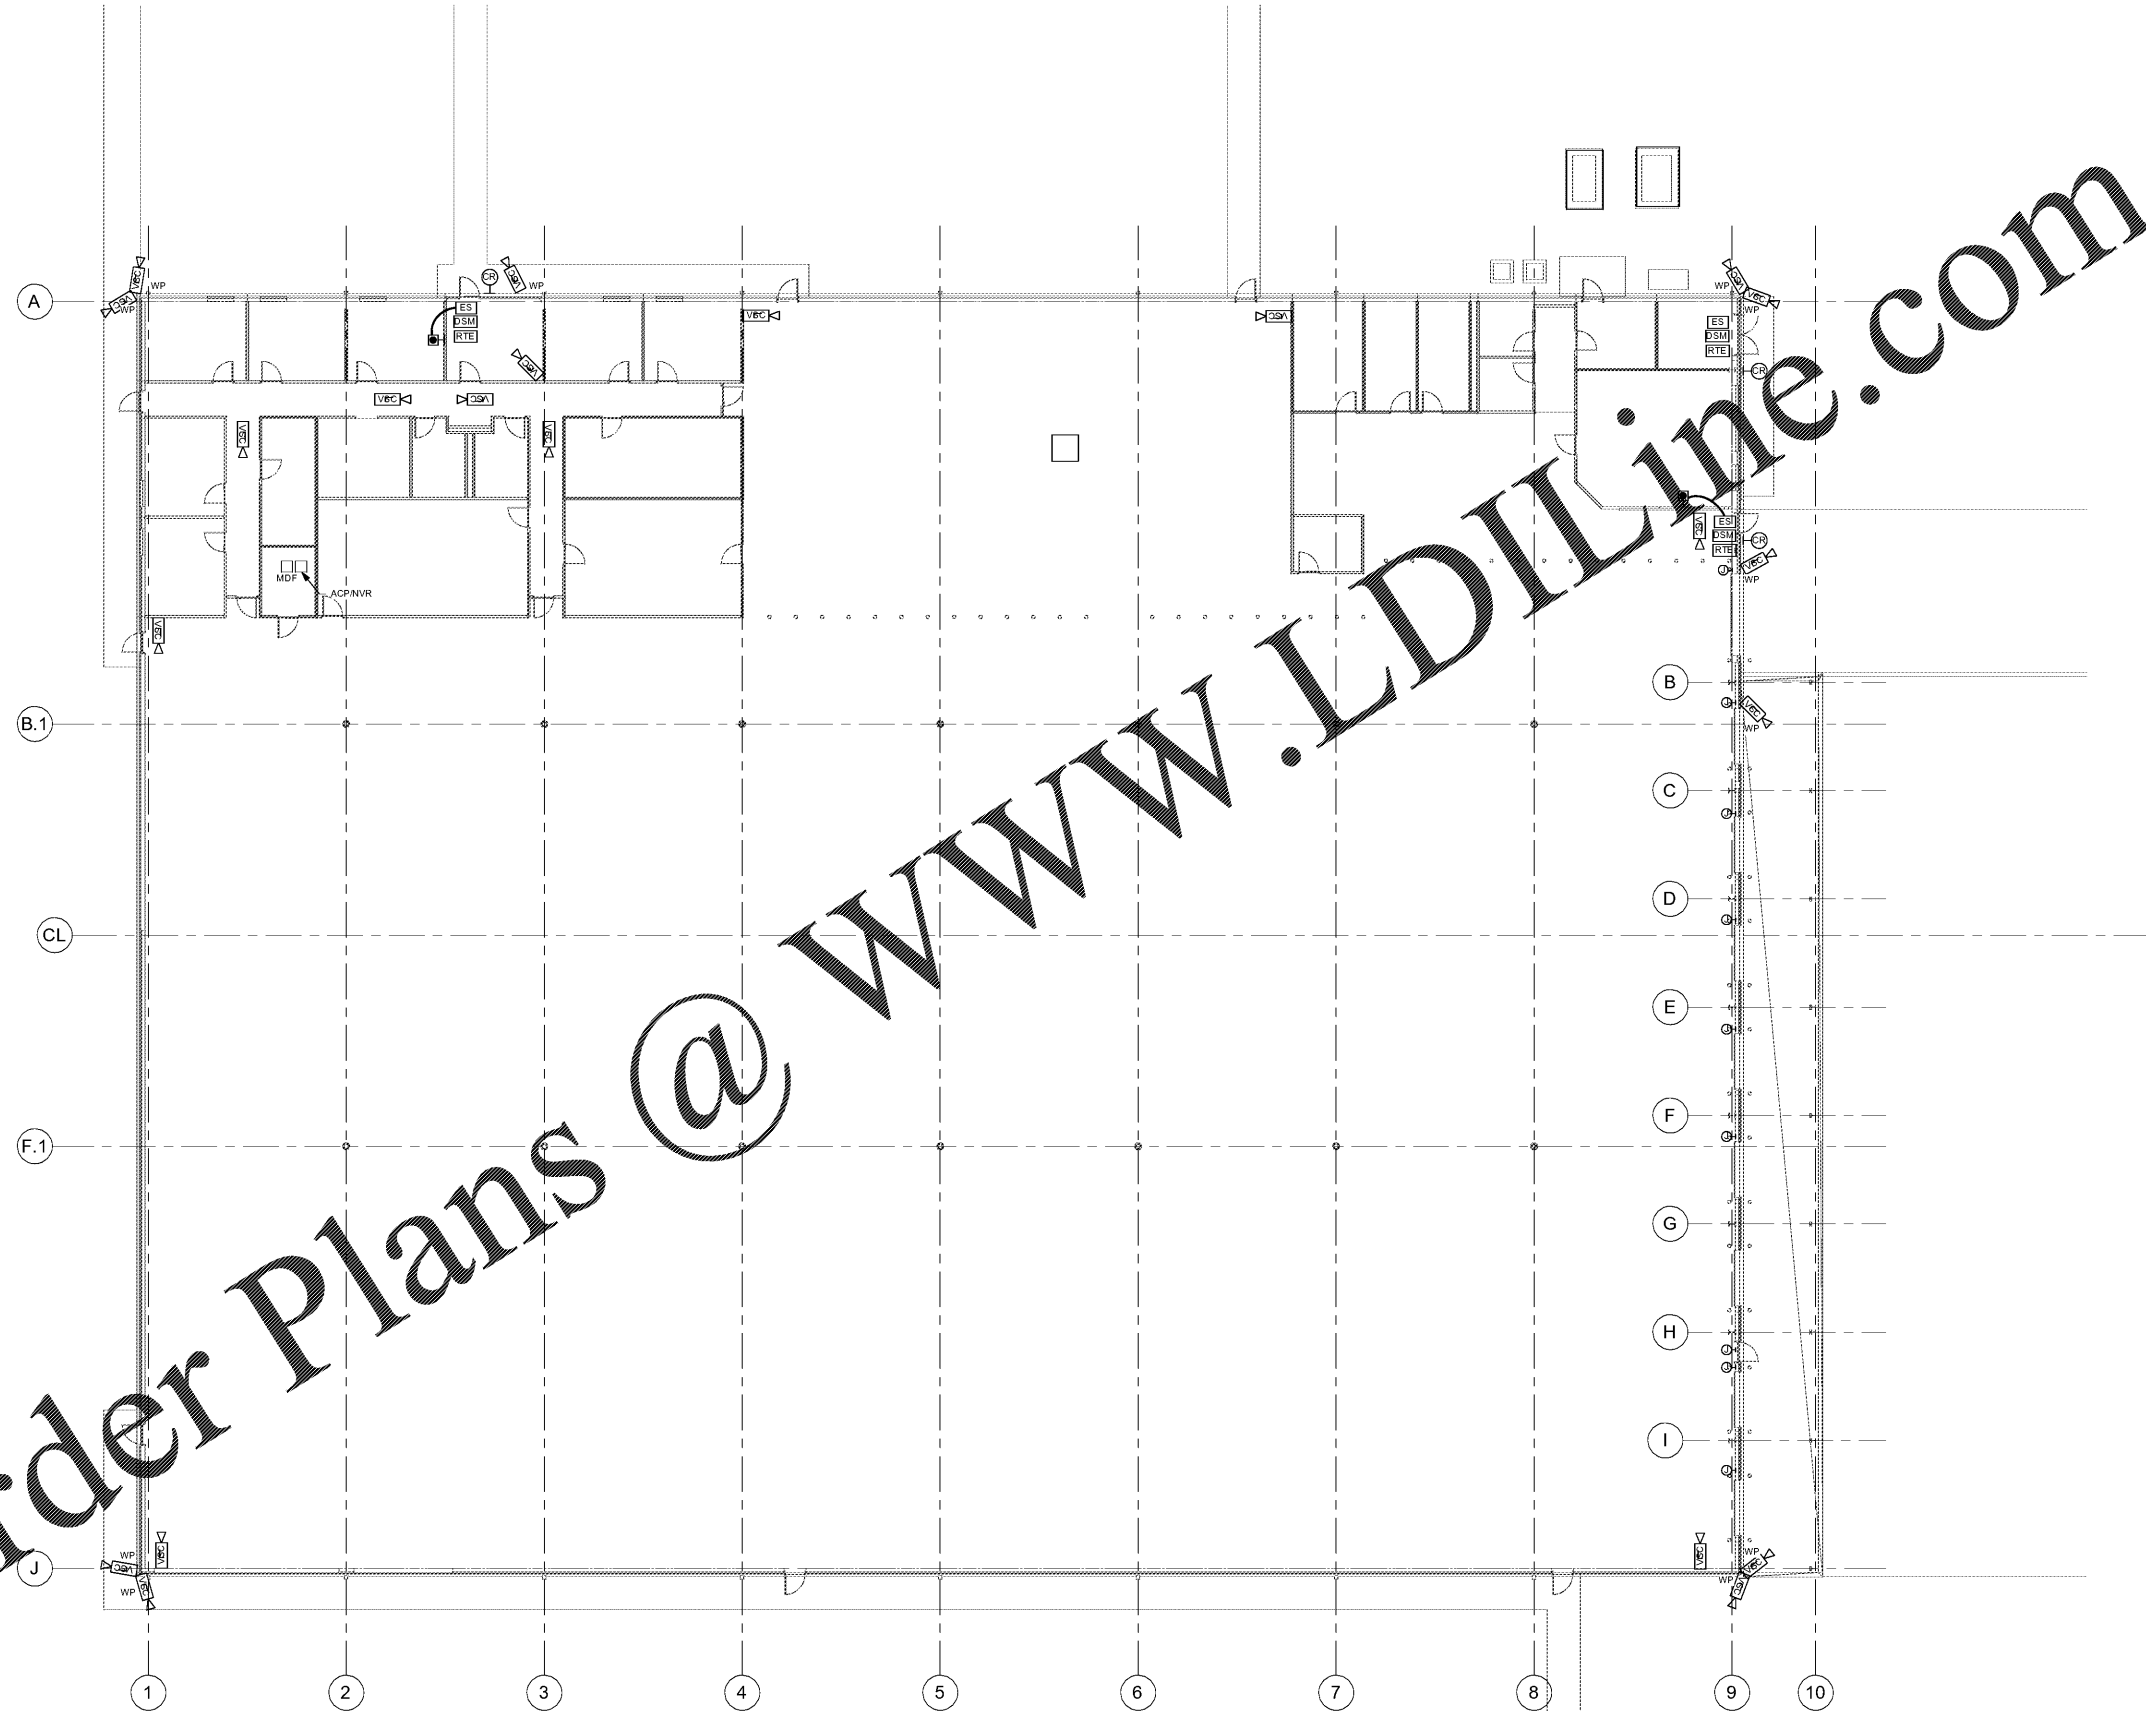

SECURITY FLOOR PLAN
SCALE: 3/32" = 1'-0"

ISSUANCES	
DATE	Description
KEY PLAN	
 AH&P CONSULTING ENGINEERS ANDREWS, HAMBROCK & POWELL, INC. 255 Charter Lane Suite 100 MARIETTA, GEORGIA 30151 MARIETTA, GEORGIA 30151 FAX 478 405-8210 WWW.AHPENG.COM	
	
	
Manley Spangler Smith Architects A Professional Corporation 625 East Taylor St P.O. Box 880 Griffin, Georgia 30224 Office 770.227.5473 Fax 770.228.3442	
PROJECT: HENRY COUNTY SCHOOLS - DISTRIBUTION CENTER CLIENT: HENRY COUNTY BOARD OF EDUCATION SHEET TITLE: SECURITY FLOOR PLAN	
PROJECT NUMBER:	201827
DATE:	08.13.20
SCALE:	AS SHOWN
DRAWN BY:	SMN
CHECKED BY:	NHO
SHEET NO.:	E4.21