



**COPYRIGHT NOTICE**  
This drawing is the property of the above referenced Professional and is not to be used for any purpose other than the specific project and site named herein, and cannot be reproduced in any manner without the express written permission from the Professional.

**ISSUE RECORD**


DATE	REV.	DESCRIPTION
05/20/2020		PERMIT SUBMISSION SET
06/07/2020	1	OUT TO BID SET

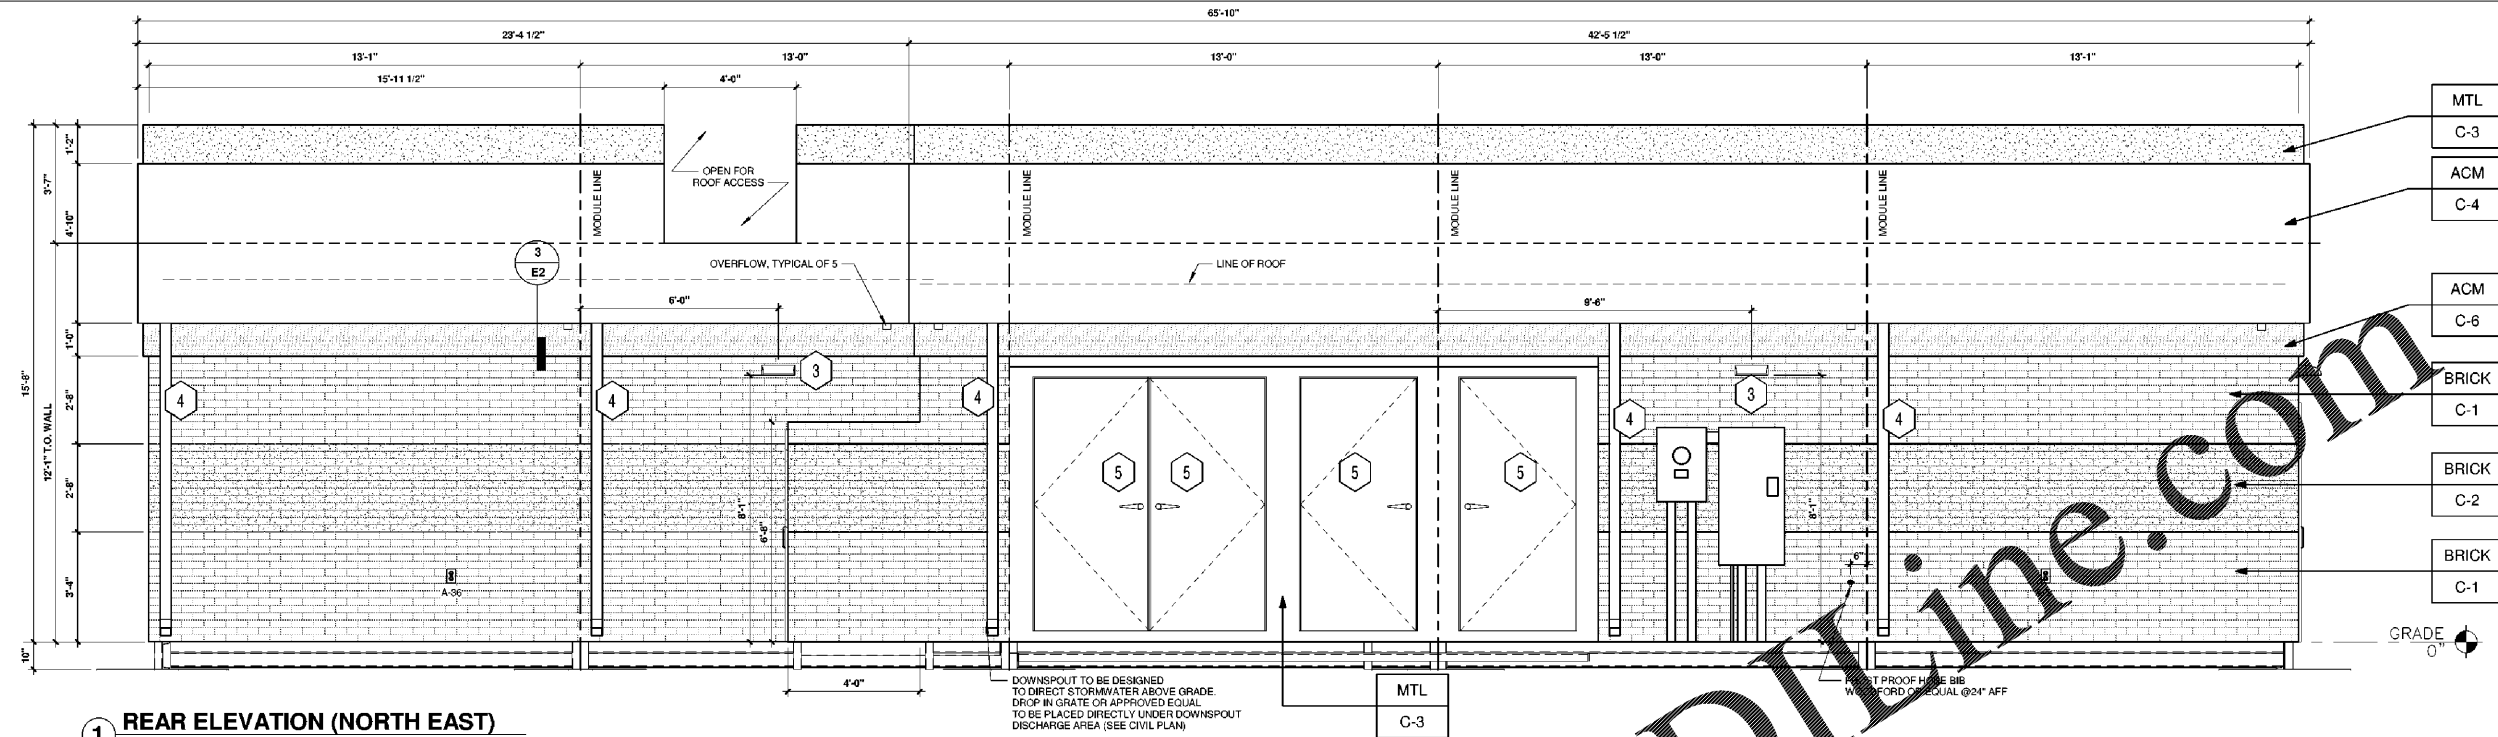

**1 REAR ELEVATION (NORTH EAST)**  
3/8" = 1'-0"

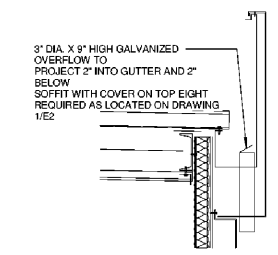

**3 OVERFLOW DETAIL**  
N.T.S.


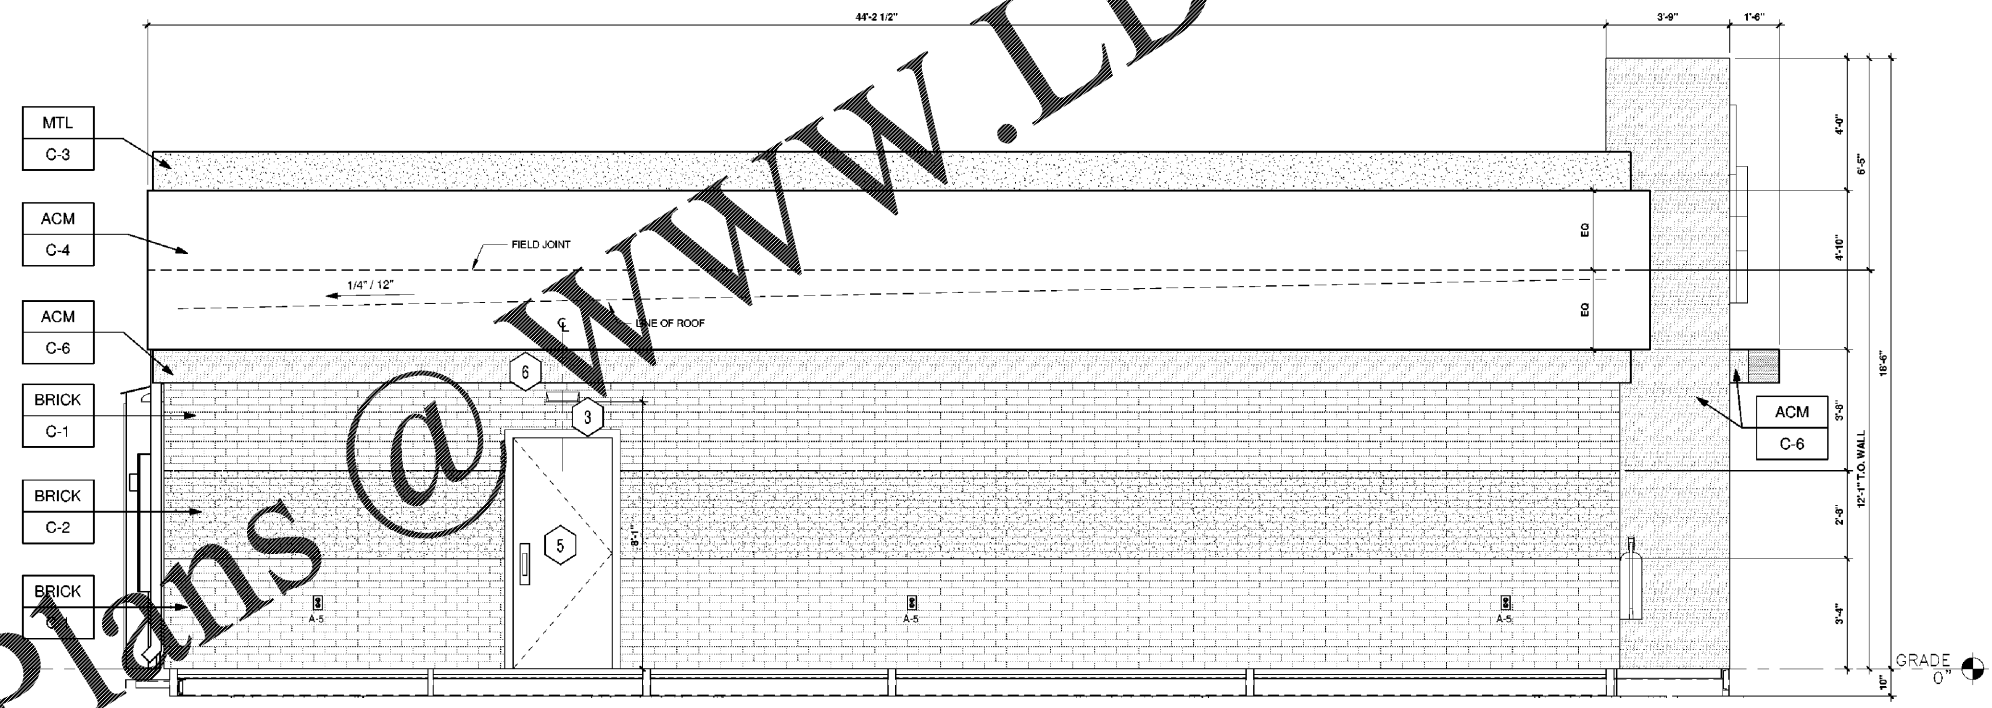


**2 LEFT ELEVATION (NORTH WEST)**  
3/8" = 1'-0"

- KEYED NOTES:**
- 1 ROUTED LETTER LOGO SIGNAGE BY FMS
  - 2 CLEAR ANODIZED ALUMINUM STOREFRONT SYSTEM C-7  
KAWNEER, YKK OR EQUAL
  - 3 EXTERIOR LIGHTING, REFER TO LIGHTING PLAN SHEET EL2
  - 4 4" x 4" PAINTED METAL DOWNSPOUTS C-3
  - 5 DOORS (EXTERIOR SIDE) AND DOOR FRAMES PAINTED C-3
  - 6 OPEN BY FMS
  - 7 MURPHY EXPRESS STAR LOGO SIGNAGE BY SIGN CONTRACTOR

- EXTERIOR FINISHES:**
- ACM ACM (3MM THICKNESS) BY FMS
  - BRICK THIN BRICK BY FMS
  - MTL 20 GA. SHEET METAL (UNLESS NOTED OTHERWISE) BY FMS

- EXTERIOR PAINT/COLORS:**
- C-1 THIN BRICK VENEER - LIGHT SANDSTONE VELOUR BY ENDURAMAX PREBLEND GREY COLOR GROUT BY FMS
  - C-2 THIN BRICK VENEER - EMPIRE IVORY VELOUR BY CAROLINA CERAMICS (WIRE CUT FINISH) WITH ENDURAMAX PREBLEND GREY COLOR GROUT BY FMS
  - C-3 DORMER BROWN SW #72C1 BY FMS
  - C-4 REYNOLDBOND #4 NATURAL BRUSHED ALUMINUM BY ARCONIC BY FMS
  - C-5 OPEN BY FMS
  - C-6 'PROGRAM RED' BY ALPOLIC BY FMS
  - C-7 CLEAR ANODIZED ALUMINUM STOREFRONT BY FMS

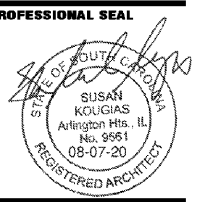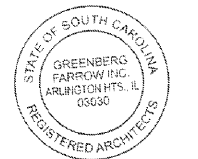

**PROFESSIONAL IN CHARGE**  
SUSAN NELSON KOUTRAS  
**PROJECT MANAGER**  
JOHN NASHED  
**QUALITY CONTROL**  
CHRIS CERBO  
**DRAWN BY**  
SS

**PROJECT NAME**  
**MURPHY EXPRESS**  
**MURPHY OIL CONVENIENCE STORE**  
4400 AUGUSTA RD & OAK DR,  
LEXINGTON  
SOUTH CAROLINA 29073

**FREY MOSS STRUCTURE**  
1801 Rockdale Industrial Blvd.  
Conyers, Georgia 30012  
Voice: (800) 368-6385  
Fax: (770) 409-6037  
FMS JOB NUMBER  
C20181975  
FMS MODEL NUMBER  
XXXXXX  
**PROJECT NUMBER**  
**20181975.5**

**SHEET TITLE**  
**EXTERIOR ELEVATIONS**

**SHEET NUMBER**

**E2**

Order Plans @ [www.LDIDline.com](http://www.LDIDline.com)