


COPYRIGHT NOTICE
This drawing is the property of the above referenced Professional and is not to be used for any purpose other than the specific project and site named herein, and cannot be reproduced in any manner without the express written permission from the Professional.

ISSUE RECORD


DATE	REV.	DESCRIPTION
05/20/2020		PERMIT SUBMISSION SET
08/07/2020	1	OUT TO BID SET

GENERAL NOTES

- INSTALLATION OF HVAC BY FMS. SITE HOOK UP BY GC. GC TO INSTALL SANDWICH MERCHANDISER/CU-3 REFRIGERATION PIPING. HVAC REGISTERS TO BE STEP DOWN TYPE.
- ALL MECHANICAL EQUIPMENT SHALL BE SCREENED BY PARAPET WALL. REFER TO ARCHITECTURAL DRAWINGS FOR PARAPET ELEVATION AND DETAIL.

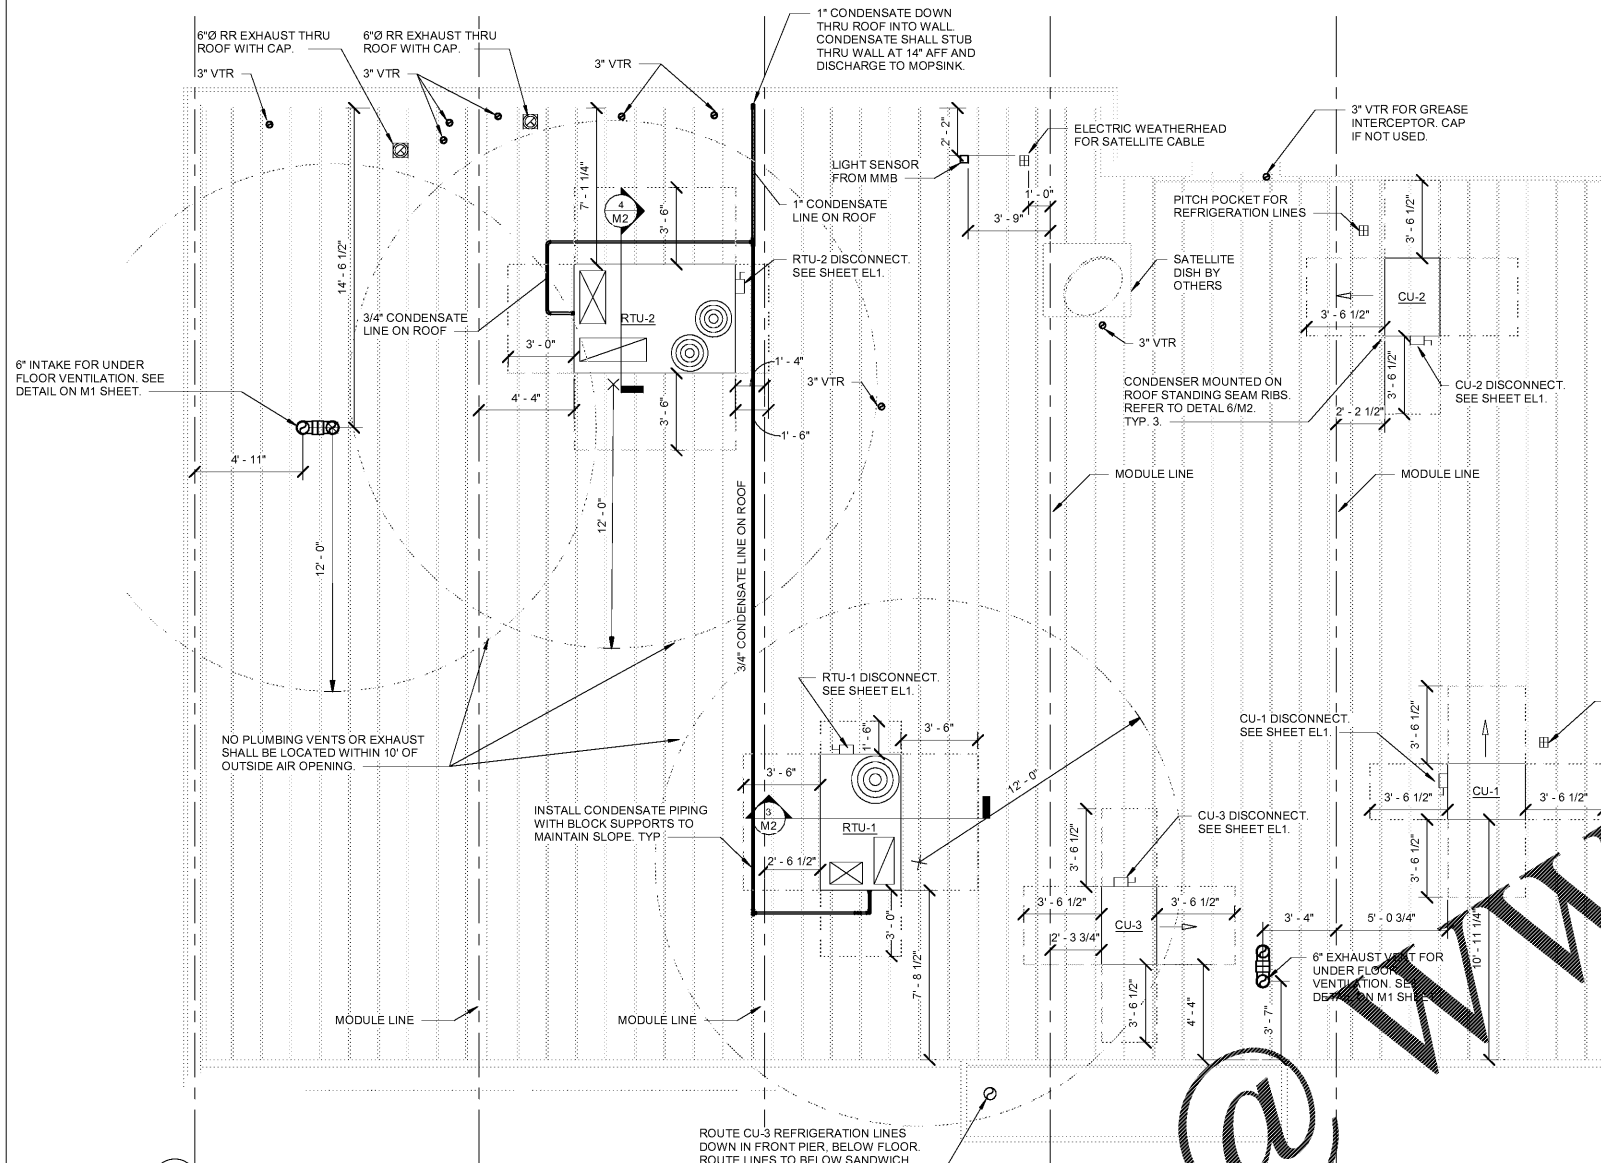


1 ROOF EQUIPMENT PLAN
M2
1/4" = 1'-0"

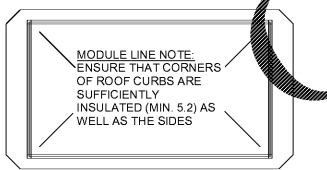


NOTE: INTERIOR FRAMING OF CURB NOT SHOWN FOR CLARITY


2 ROOF CURB INSULATION PLAN VIEW
M2
N.T.S.

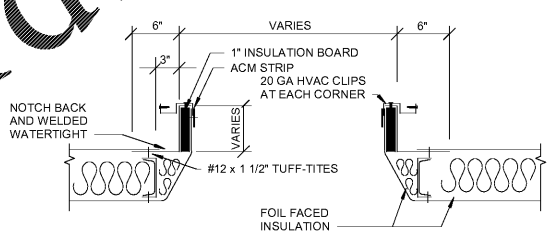


3 ROOF CURB DETAIL
M2
N.T.S.

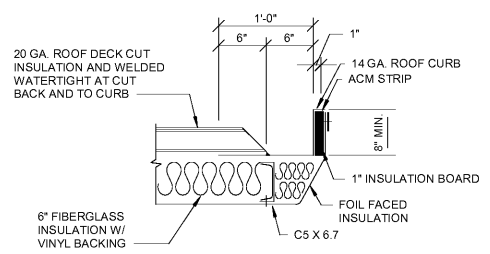

4 ROOF CURB DETAIL - PARTIAL
M2
N.T.S.

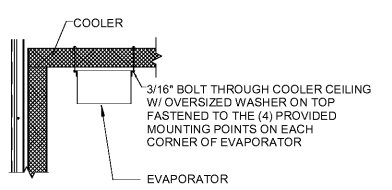

5 EVAPORATOR UNIT MOUNTING
M2
N.T.S.

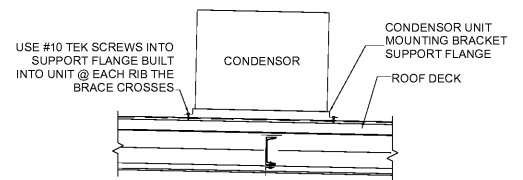

6 CONDENSER UNIT MOUNTING DETAIL
M2
N.T.S.

Order Plans @ www.LDILine.com



PROFESSIONAL SEAL



PROFESSIONAL IN CHARGE
ROBERT BLAKE SMITH

PROJECT MANAGER
ERIC WONG

QUALITY CONTROL
ERIC WONG

DRAWN BY
AVERY LANE

PROJECT NAME



MURPHY OIL CONVENIENCE STORE
NW CORNER HWY 1 & OAK DRIVE, LEXINGTON SOUTH CAROLINA 29073



1801 Rockdale Industrial Blvd.
Conyers, Georgia 30012
Voice: (800) 366-6385
Fax: (770) 483-6037
FMS JOB NUMBER G20M00081
FMS MODEL NUMBER XXXXXX

PROJECT NUMBER
20181975.5

SHEET TITLE

MECHANICAL ROOF PLAN

SHEET NUMBER

M2