


Alabama Line Location Center, Inc. 1-800-292-8525 252-4444 (Birmingham Area) Call 2 working days before digging. It's the Law!

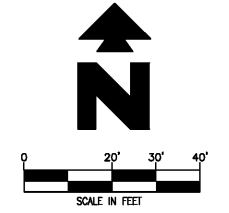

LEGEND

Table with columns for EXISTING and PROPOSED, listing various symbols and their corresponding descriptions for property lines, curbs, gutters, and construction fences.

GENERAL PAVING NOTES

- A. CONCRETE ON ASPHALT UTILITY CUT REPAIRS TO BE DYED TO MATCH SURROUNDING ASPHALT. B. UNLESS OTHERWISE SHOWN, CALLED OUT OR SPECIFIED HEREON ALL CURB AND GUTTER ADJACENT TO CONCRETE PAVING SHALL BE INSTALLED PER DETAIL 1B (SEE DETAIL SHEET).

PAVING NOTES

- 13A ASPHALT PAVING 13B LIMITS OF HEAVY DUTY CONCRETE PAVING 21A TAPER CURB TO MATCH EXISTING CURB

PAVING DETAILS

- 1B TYPE "B" CURB & GUTTER 1E TYPE "E" CURB

GENERAL JOINT LAYOUT NOTES


- A. THIS PLAN IS FOR RELATIVE LAYOUT AND SCOPE OF WORK PURPOSES ONLY. REFER TO SITE PLAN FOR RELATIONSHIP OF THESE STRUCTURES TO EXISTING CONDITIONS AND REFERENCE POINTS.

JOINT LAYOUT NOTES

- 2D #4 SMOOTH DOWEL BARS @ 24" O.C. (12" LONG) 10A TANK MANHOLE REINFORCEMENT (SEE TANK/PIPING PLANS FOR ADDITIONAL DETAILS) 51B LIMITS OF SAWCUT AND PAVEMENT REMOVAL


JOINT LAYOUT DETAILS - SEE DETAIL SHEETS

- 2B TOOLED CONTROL JOINT 2C DOWEL CONSTRUCTION JOINT IN CONCRETE SLAB 3A AR/WAC UNIT MOUNTING SLAB 5B ICE BOX MOUNTING SLAB 5C PROPANE BOX MOUNTING SLAB 13E ASPHALT ABUTTING JOINT

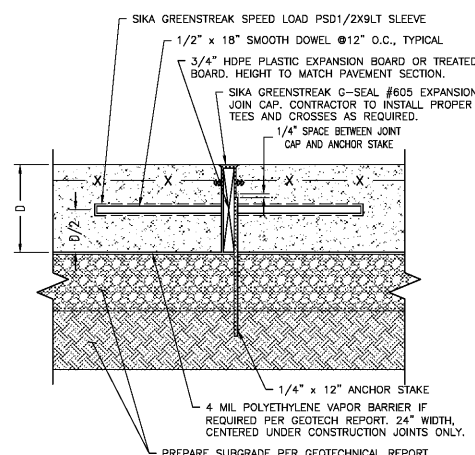


INSTALLATION STEPS: 1. TERMINATE STAKES BELOW THE TOP OF THE BOARD A DISTANCE EQUAL TO THE DEPTH OF THE G-SEAL PROFILE PLUS 1/4" MIN. WARNING: ANCHOR STAKES LONGER THAN 12" SHALL NOT BE USED AND CARE SHOULD BE TAKEN NOT TO UNNECESSARILY CONFLICT WITH PRODUCT PIPING TRENCHES.


DOWEL CONSTRUCTION JOINT IN CONCRETE SLAB

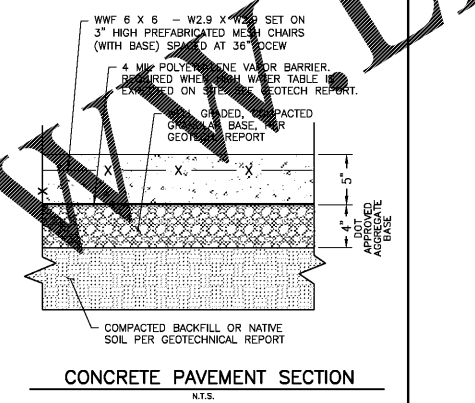


CONCRETE PAVEMENT SECTION

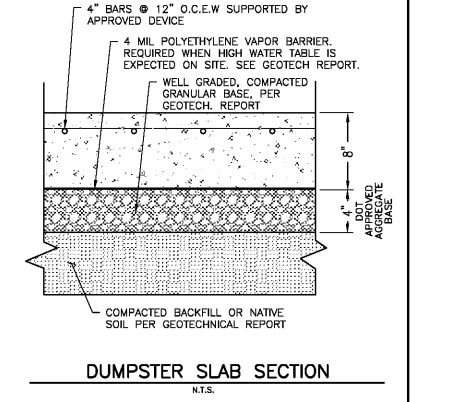


DUMPSTER SLAB SECTION

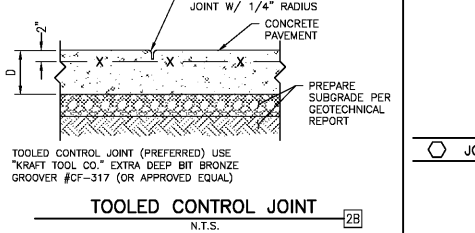

TOOLED CONTROL JOINT

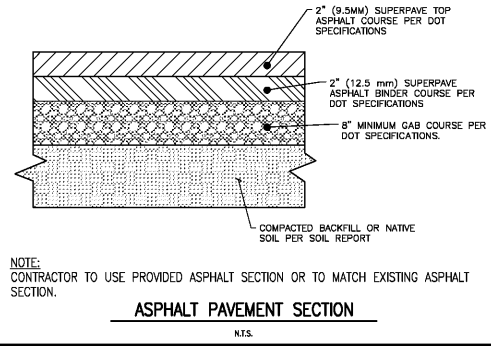


ASPHALT PAVEMENT SECTION

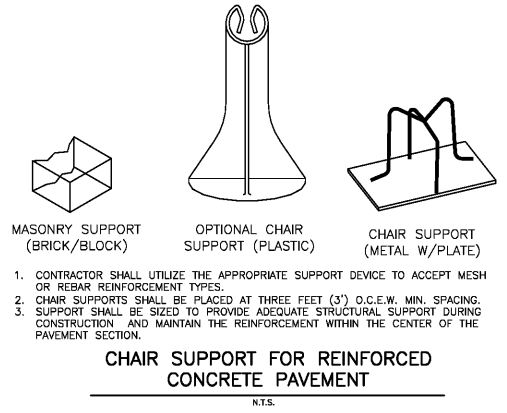

CHAIR SUPPORT FOR REINFORCED CONCRETE PAVEMENT

- 1. CONTRACTOR SHALL UTILIZE THE APPROPRIATE SUPPORT DEVICE TO ACCEPT MESH OR REBAR REINFORCEMENT TYPES. 2. CHAIR SUPPORTS SHALL BE PLACED AT THREE FEET (3') O.C.E.W. MIN. SPACING. 3. SUPPORT SHALL BE SIZED TO PROVIDE ADEQUATE STRUCTURAL SUPPORT DURING CONSTRUCTION AND MAINTAIN THE REINFORCEMENT WITHIN THE CENTER OF THE PAVEMENT SECTION.

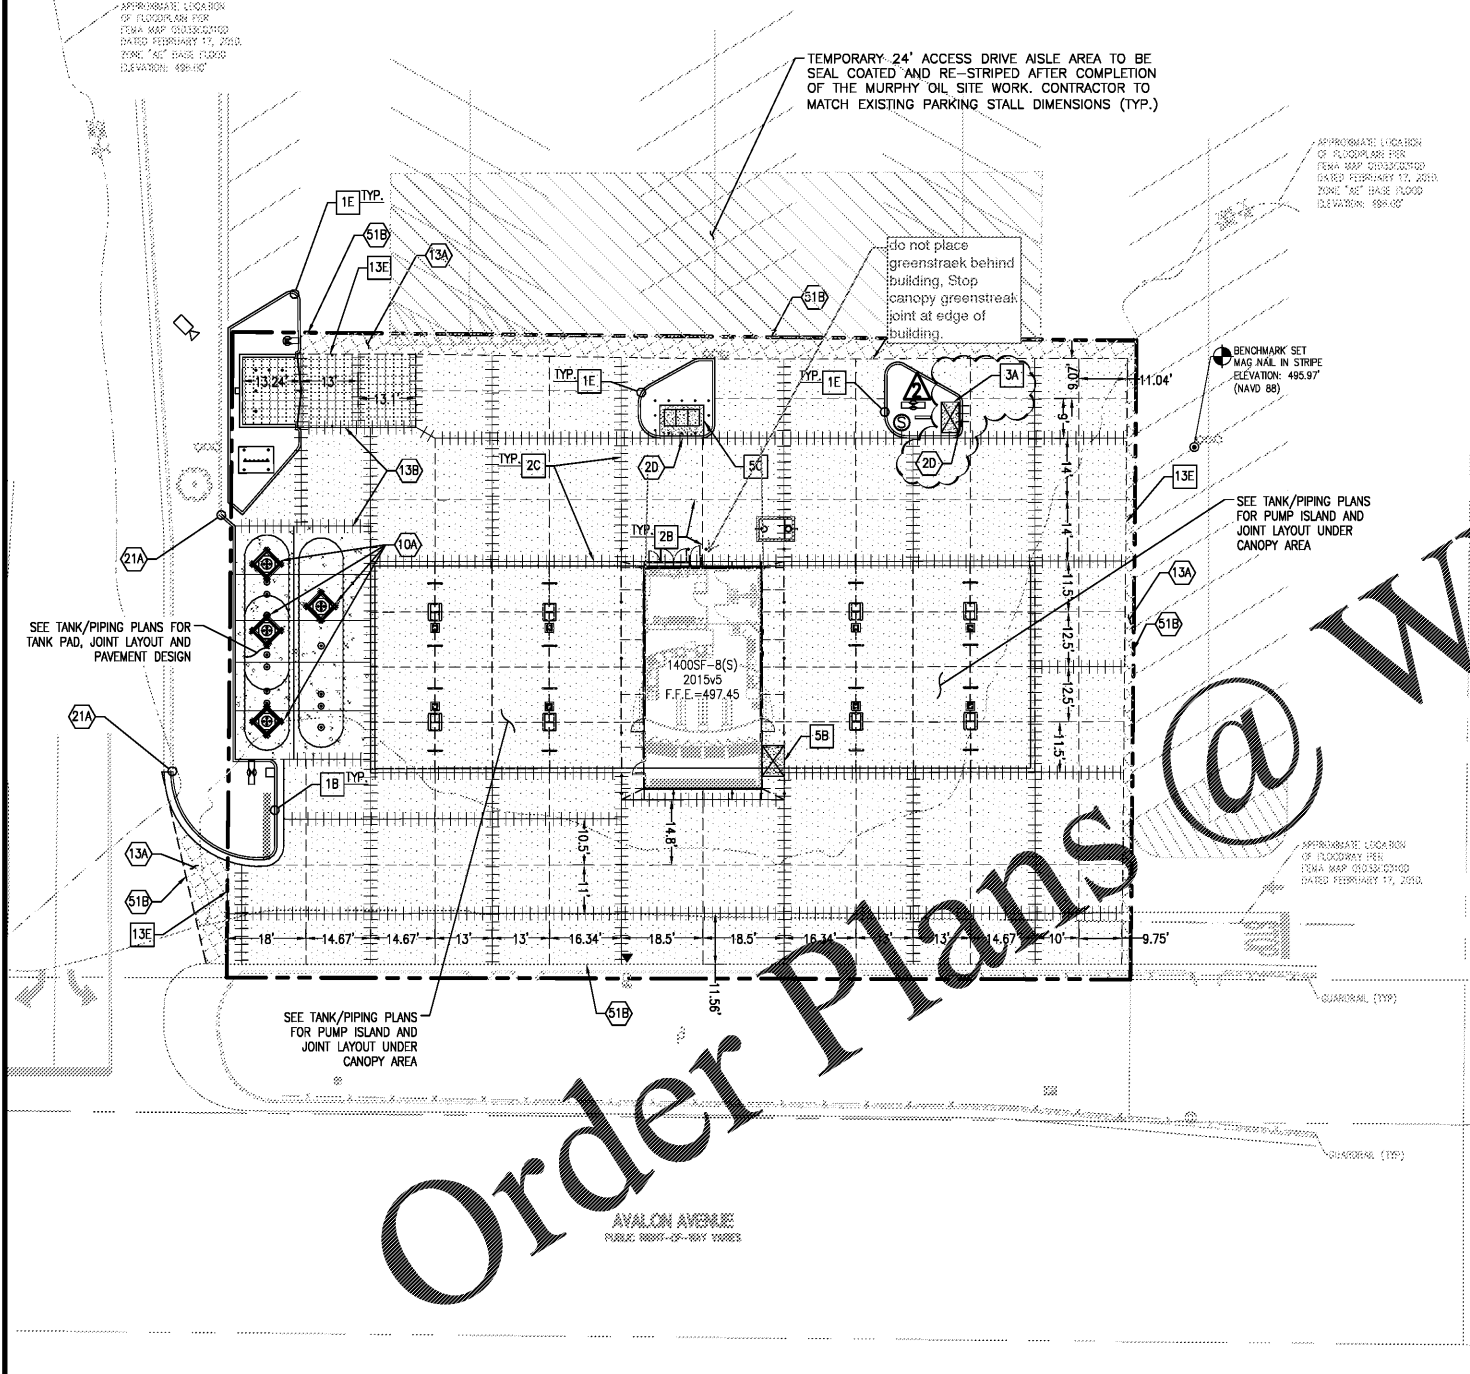

NOTE: GC IS REFERRED TO GEOTECHNICAL REPORT PREPARED BY UNITED CONSULTING DATED APRIL 2, 2019. FOR SITE PREPARATION CONDITIONS AND PAVEMENT REQUIREMENTS.

Order Plans @ WALMART@Line.com

GreenbergFarrow 135 CORDAVILLE ROAD, SUITE 210 SOUTHROCKHILL, MA 01172 PHONE: (908) 229-0022 DWG NAME: MUSCLE SHOALS, AL JOB NO.: 201901210

MURPHY OIL USA, INC. 200 PEACH STREET P.O. BOX 7000 EL DORADO, AR 71730-7000

PAVING/Joint LAYOUT WALMART SUPERCENTER #660 517A WEST AVALON AVENUE MUSCLE SHOALS, AL 35661

REVISION RECORD table with columns for DATE, DESCRIPTION, and PERMIT SET.