


THIS DRAWING AND THE DESIGN SHOWN THEREON ARE THE PROPERTY OF JEFF LEWIS, AIA. THE REPRODUCTION, COPYING OR OTHER USE OF THIS DRAWING WITHOUT WRITTEN CONSENT OF JEFF LEWIS AIA, THE REPRODUCTION, COPYING OR OTHER USE OF THIS DRAWING WITHOUT WRITTEN CONSENT OF JEFF LEWIS AIA IS PROHIBITED AND INFRINGEMENTS WILL BE SUBJECT TO LEGAL ACTION.

Order Plans @ www.LDILine.com

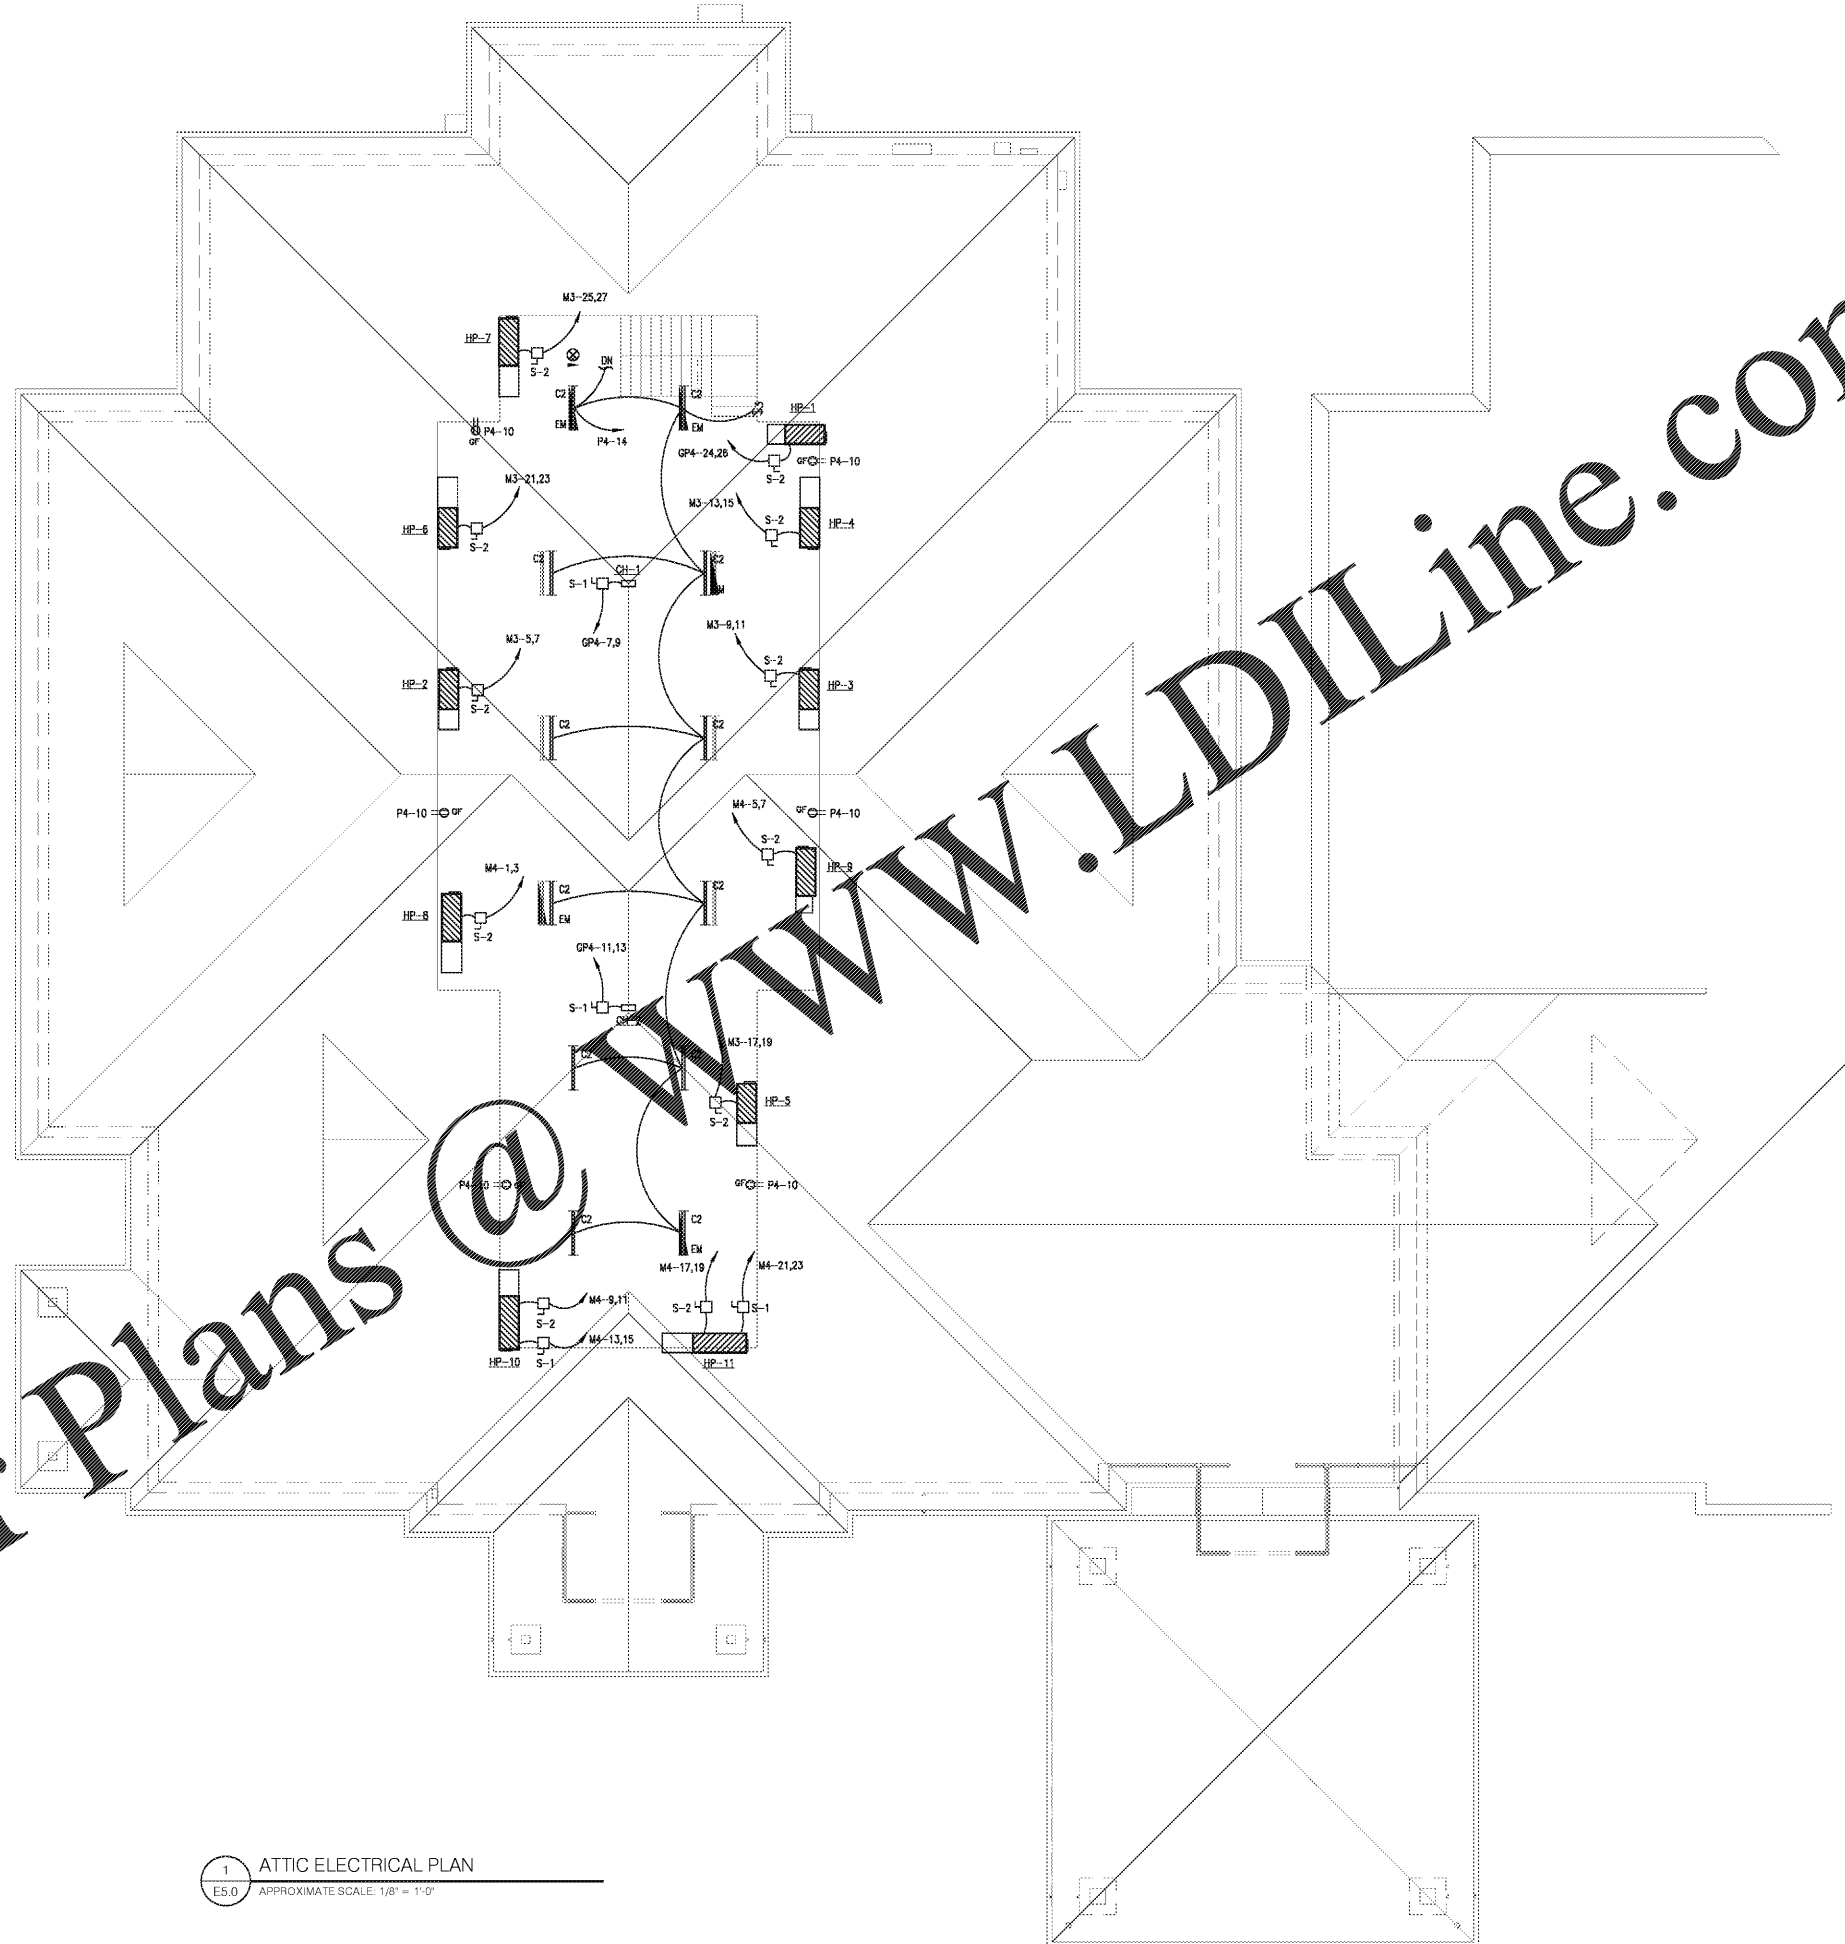

1 ATTIC ELECTRICAL PLAN
E5.0 APPROXIMATE SCALE: 1/8" = 1'-0"



ENGINEERING, LLC
5728 South River Road
Columbia, SC 29212
803.733.4311 (Phone)
803.733.4311 (Fax)
eti@etiservices.net
Project Manager
Troy Linder 1/05
ET: #1012-10105

REV.	DATE	DESCRIPTION	BID SET
1	08.21.20	BID SET	

JOB #16-039-1 07.15.2019

E5.0

LUGOFF FACILITY EXPANSION
SANDHILLS MEDICAL FOUNDATION
28 BALDWIN AVENUE
LUGOFF, SOUTH CAROLINA 29078

ATTIC ELECTRICAL PLAN

JEFF LEWIS AIA

561 JACOBS MILL POND ROAD
ELGIN, SOUTH CAROLINA 29945
803.950.5026 / jle1@jefflewis.com

STATE OF SOUTH CAROLINA
REGISTERED PROFESSIONAL ENGINEER
No. 032834

BRADY D. TUCKER
No. 23558
07/15/19