




3 PLUMBING RISER DIAGRAM - WATER SUPPLY
NOT TO SCALE

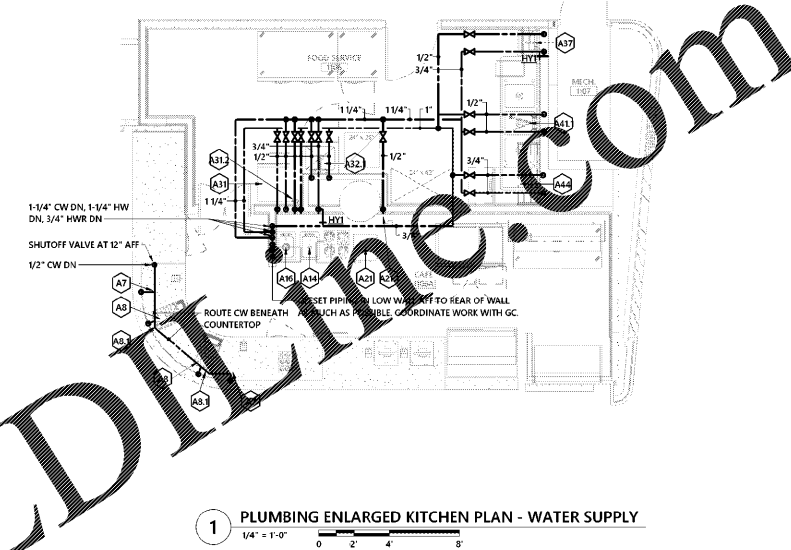

1 PLUMBING ENLARGED KITCHEN PLAN - WATER SUPPLY
1/4\" = 1'-0"

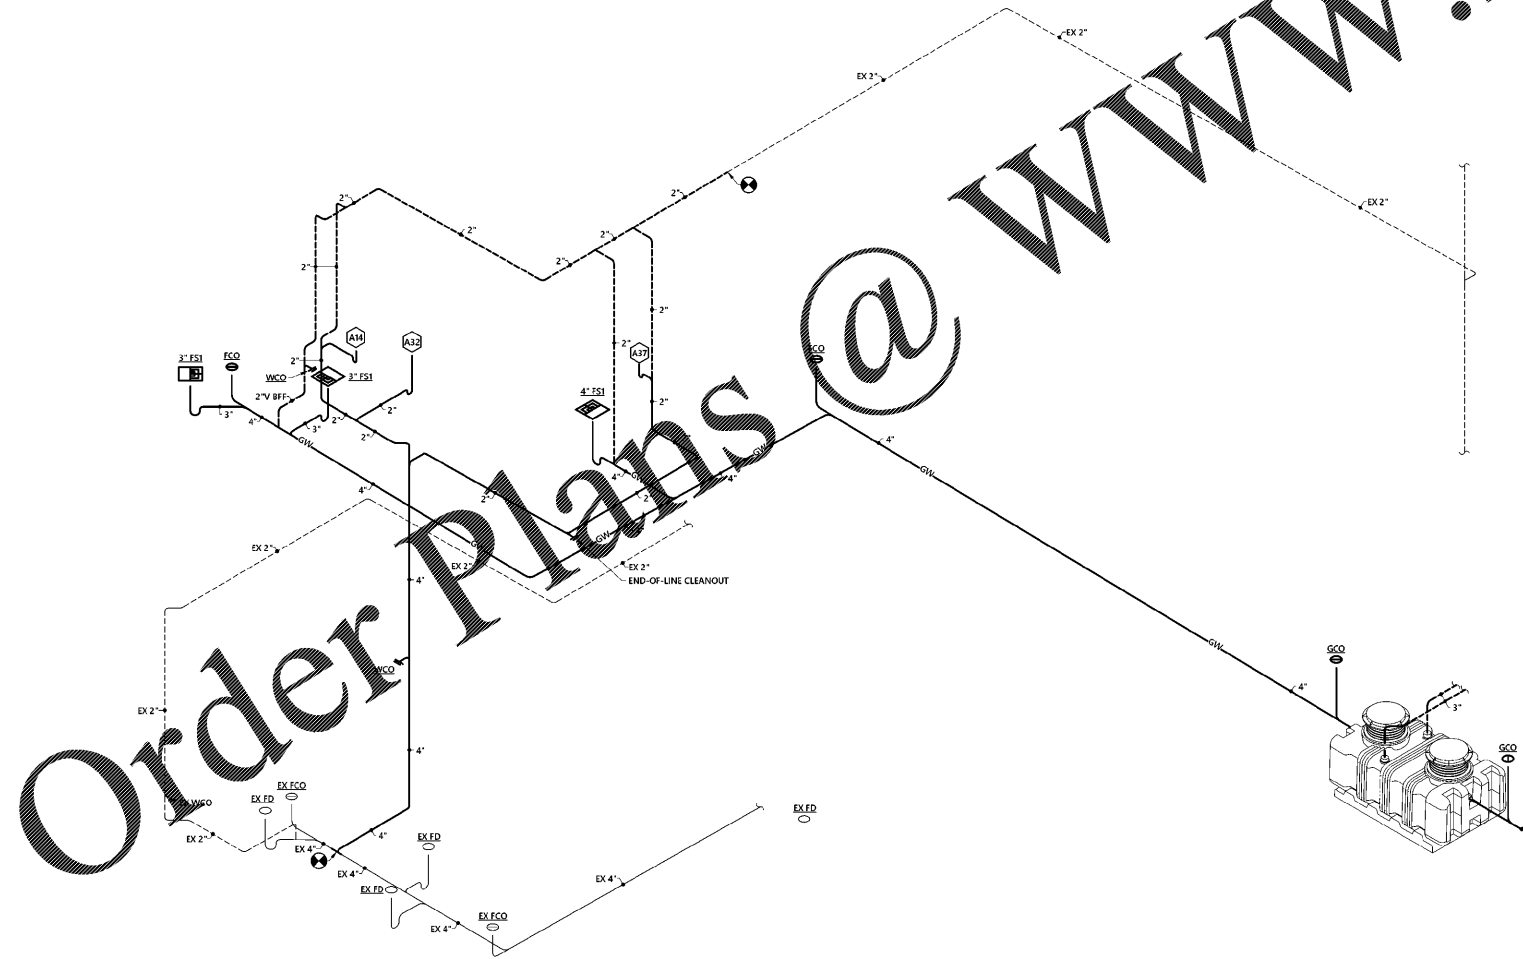


4 PLUMBING RISER DIAGRAM - WASTE & VENT
NOT TO SCALE

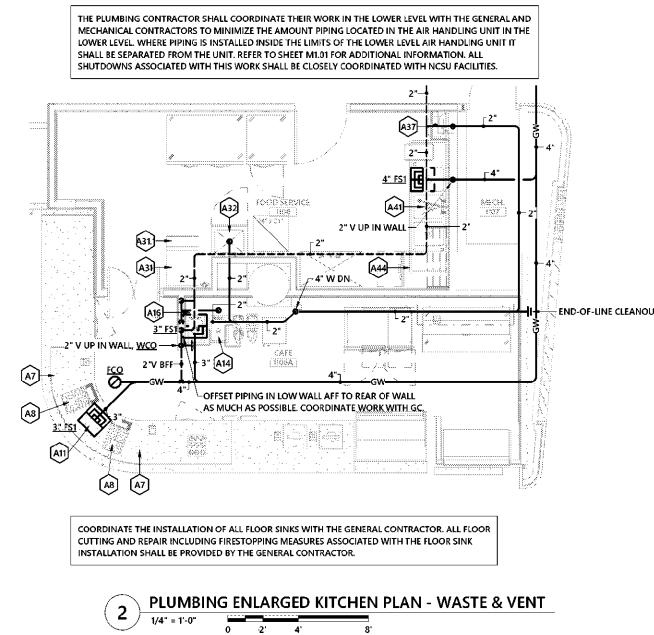

2 PLUMBING ENLARGED KITCHEN PLAN - WASTE & VENT
1/4\" = 1'-0"

THE PLUMBING CONTRACTOR SHALL COORDINATE THEIR WORK IN THE LOWER LEVEL WITH THE GENERAL AND MECHANICAL CONTRACTORS TO MINIMIZE THE AMOUNT OF PIPING LOCATED IN THE AIR HANDLING UNIT IN THE LOWER LEVEL. WHERE PIPING IS INSTALLED INSIDE THE LIMITS OF THE LOWER LEVEL AIR HANDLING UNIT IT SHALL BE SEPARATED FROM THE UNIT. REFER TO SHEET M1.01 FOR ADDITIONAL INFORMATION. ALL SHUTDOWNS ASSOCIATED WITH THIS WORK SHALL BE CLOSELY COORDINATED WITH NCSU FACILITIES.

COORDINATE THE INSTALLATION OF ALL FLOOR SINKS WITH THE GENERAL CONTRACTOR. ALL FLOOR CUTTING AND REPAIR INCLUDING FIRESTOPPING MEASURES ASSOCIATED WITH THE FLOOR SINK INSTALLATION SHALL BE PROVIDED BY THE GENERAL CONTRACTOR.

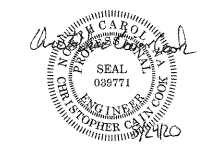

ISSUE DATE	08.24.2020	
PHASE	Bid Set	
#	DATE	REVISION