



AIKEN COUNTY
AIKEN PUBLIC LIBRARY & NORTH WING
RENOVATION
314 CHESTERFIELD ST. S, AIKEN, SC


NO.	DATE	DESCRIPTION	BY
D	04/10/2020	Permit Set	JMF
E	07/02/2020	ISSUED FOR BIDS	JMF

ISSUED FOR BIDS 07/02/2020
PRINCIPAL IN CHARGE JMF
PROJECT ENGINEER DJM
DRAWN BY RWW

SHEET TITLE:
HVAC DEMOLITION
GROUND FLOOR PLAN

SHEET NO. PROJ. NO.
019477.01

M040

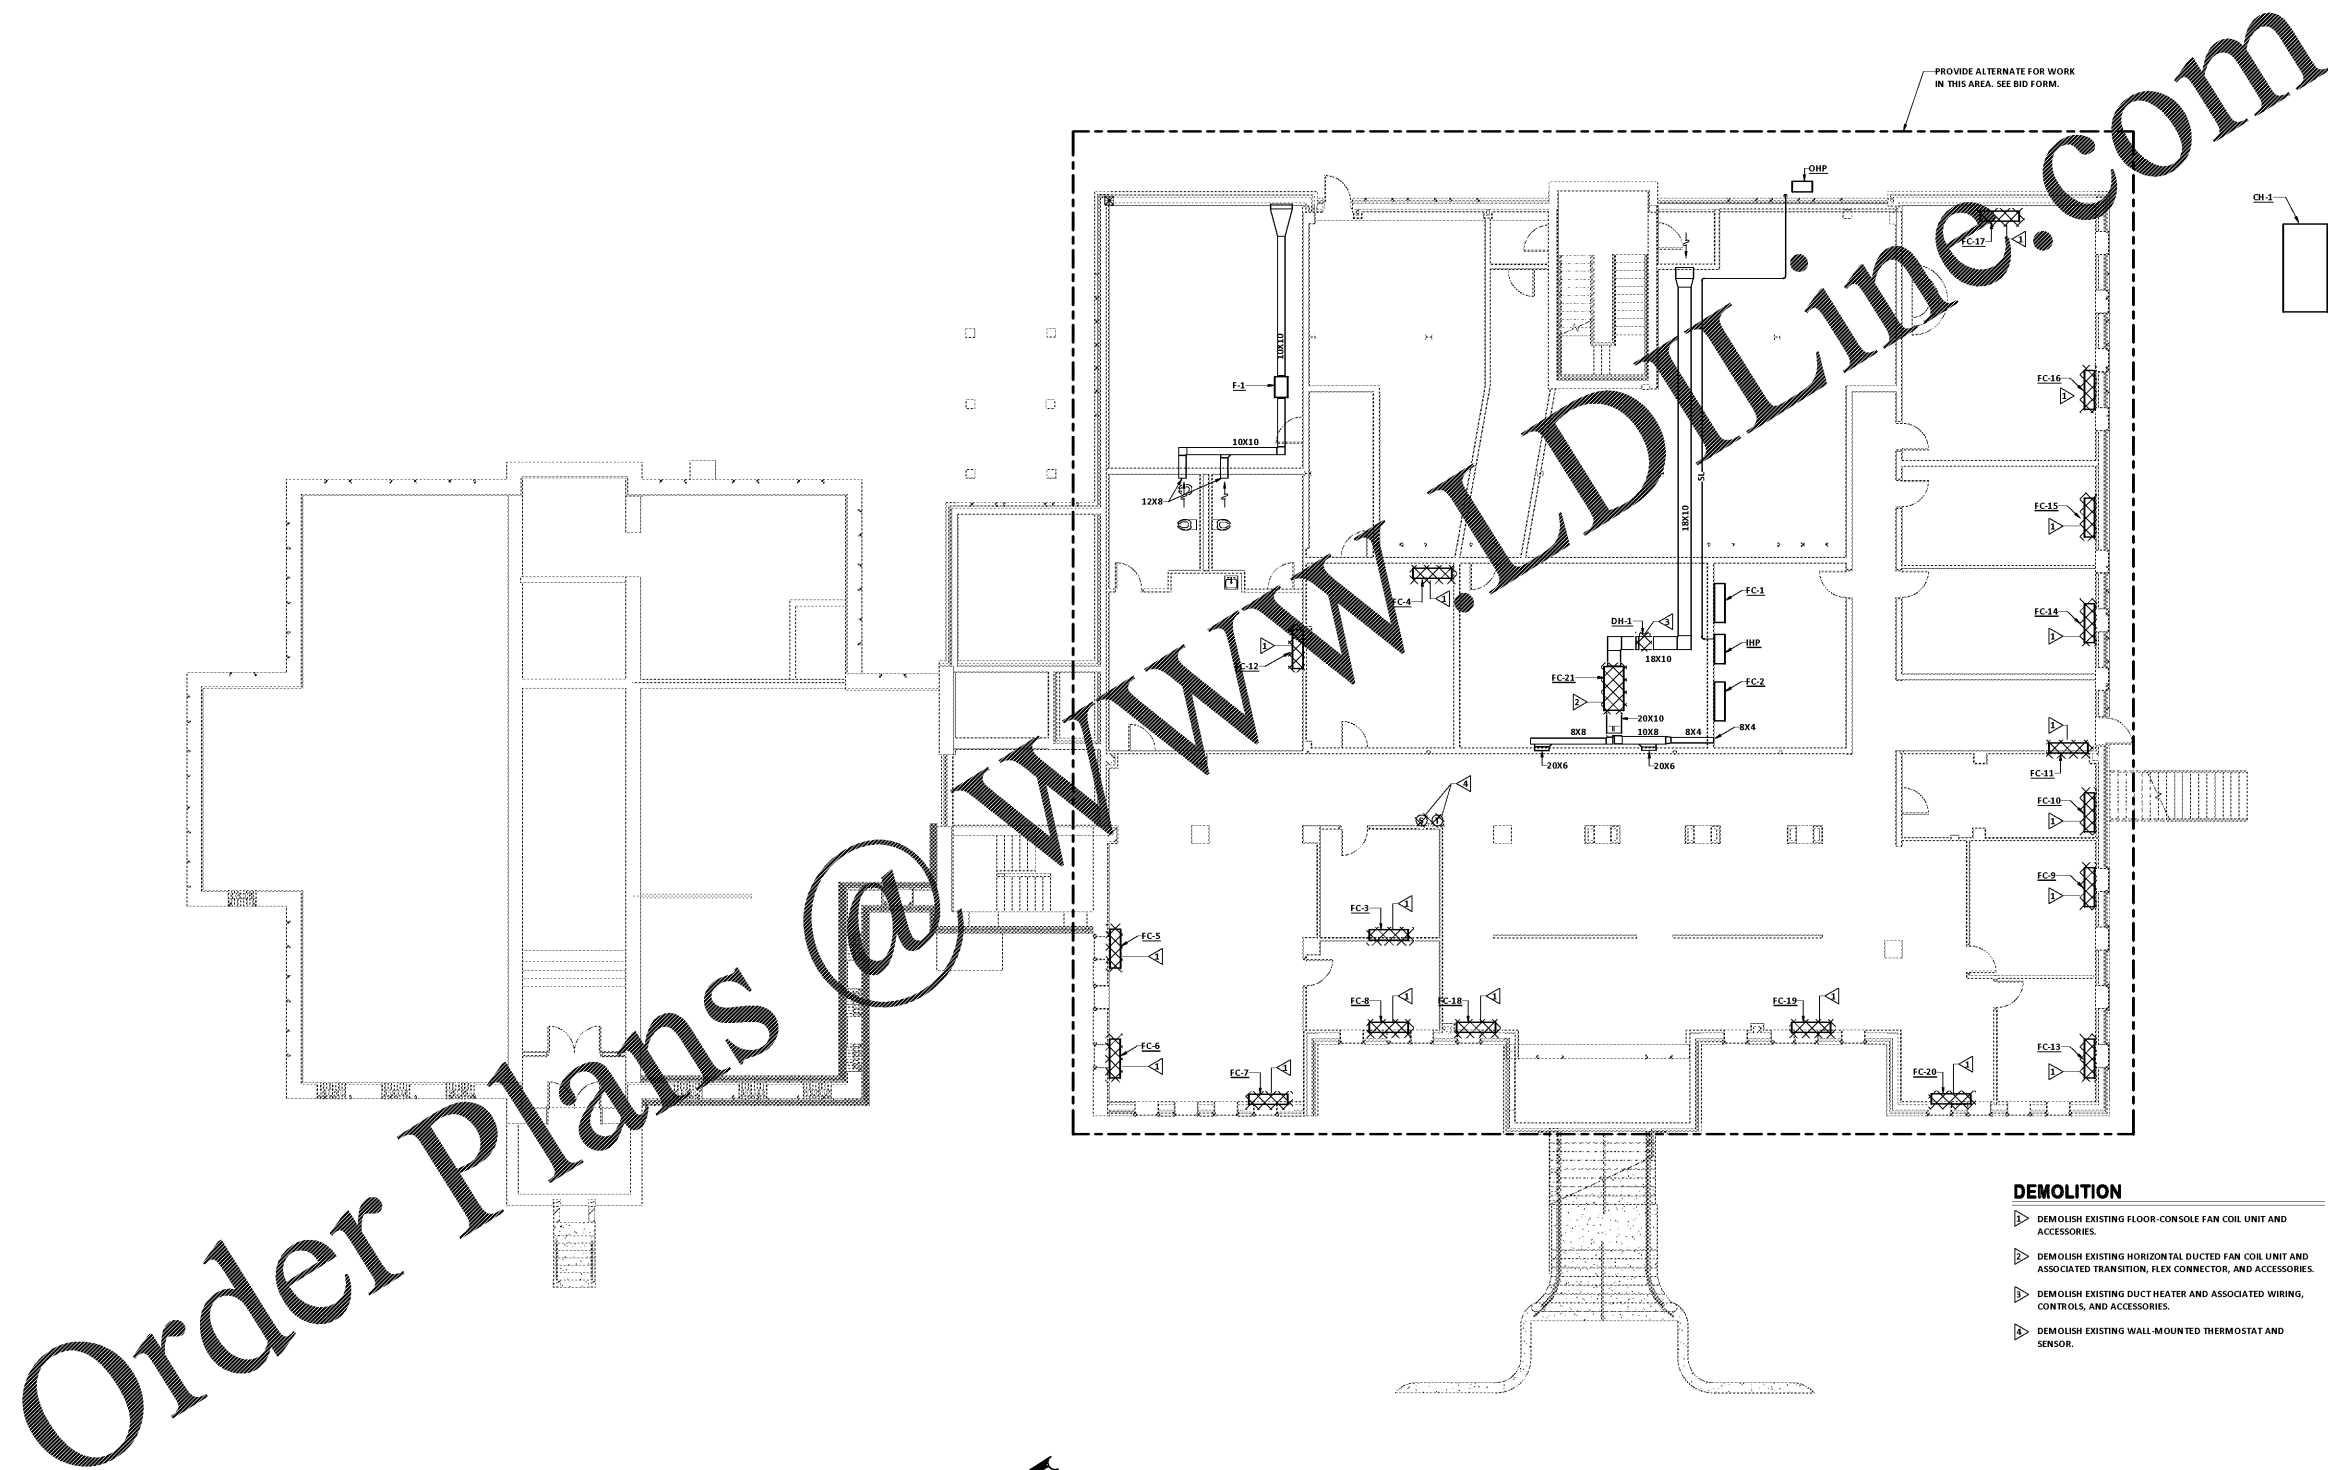

- DEMOLITION**
- ▷ DEMOLISH EXISTING FLOOR-CONSOLE FAN COIL UNIT AND ACCESSORIES.
 - ▷ DEMOLISH EXISTING HORIZONTAL DUCTED FAN COIL UNIT AND ASSOCIATED TRANSITION, FLEX CONNECTOR, AND ACCESSORIES.
 - ▷ DEMOLISH EXISTING DUCT HEATER AND ASSOCIATED WIRING, CONTROLS, AND ACCESSORIES.
 - ▷ DEMOLISH EXISTING WALL-MOUNTED THERMOSTAT AND SENSOR.

1
N
HVAC DEMOLITION PLAN - GROUND FLOOR
SCALE: 1/8" = 1'-0"

1/4" 1/2" 3/4" 1"
GRAPHIC SCALE
PLOT DATE: 4/9/2020
FILE NAME: 19088
PLOT SCALE: 1 = 96
RWW

ALL RIGHTS RESERVED. THIS DOCUMENT IS THE PROPERTY OF PRUETT, FORD & ASSOCIATES, INC. AND IS NOT TO BE REPRODUCED OR TRANSMITTED IN ANY FORM OR BY ANY MEANS, ELECTRONIC OR MECHANICAL, INCLUDING PHOTOCOPYING, RECORDING, OR BY ANY INFORMATION STORAGE AND RETRIEVAL SYSTEM, WITHOUT THE WRITTEN PERMISSION OF PRUETT, FORD & ASSOCIATES, INC.