

AIKEN COUNTY
**AIKEN PUBLIC LIBRARY & NORTH WING
RENOVATION**
314 CHESTERFIELD ST S, AIKEN, SC

SHEET ISSUE:


| NO | DATE | DESCRIPTION | BY |
|----|------------|-----------------|-----|
| D | 04/10/2020 | Permit Set | JMF |
| E | 07/02/2020 | ISSUED FOR BIDS | JMF |

ISSUED FOR BIDS: 07/02/2020
PRINCIPAL IN CHARGE: JMF
PROJECT ENGINEER: DJM
DRAWN BY: RWW

SHEET TITLE:
**HVAC DEMOLITION
FIRST FLOOR PLAN**


SHEET NO. PROJ. NO.
019477.01

M041

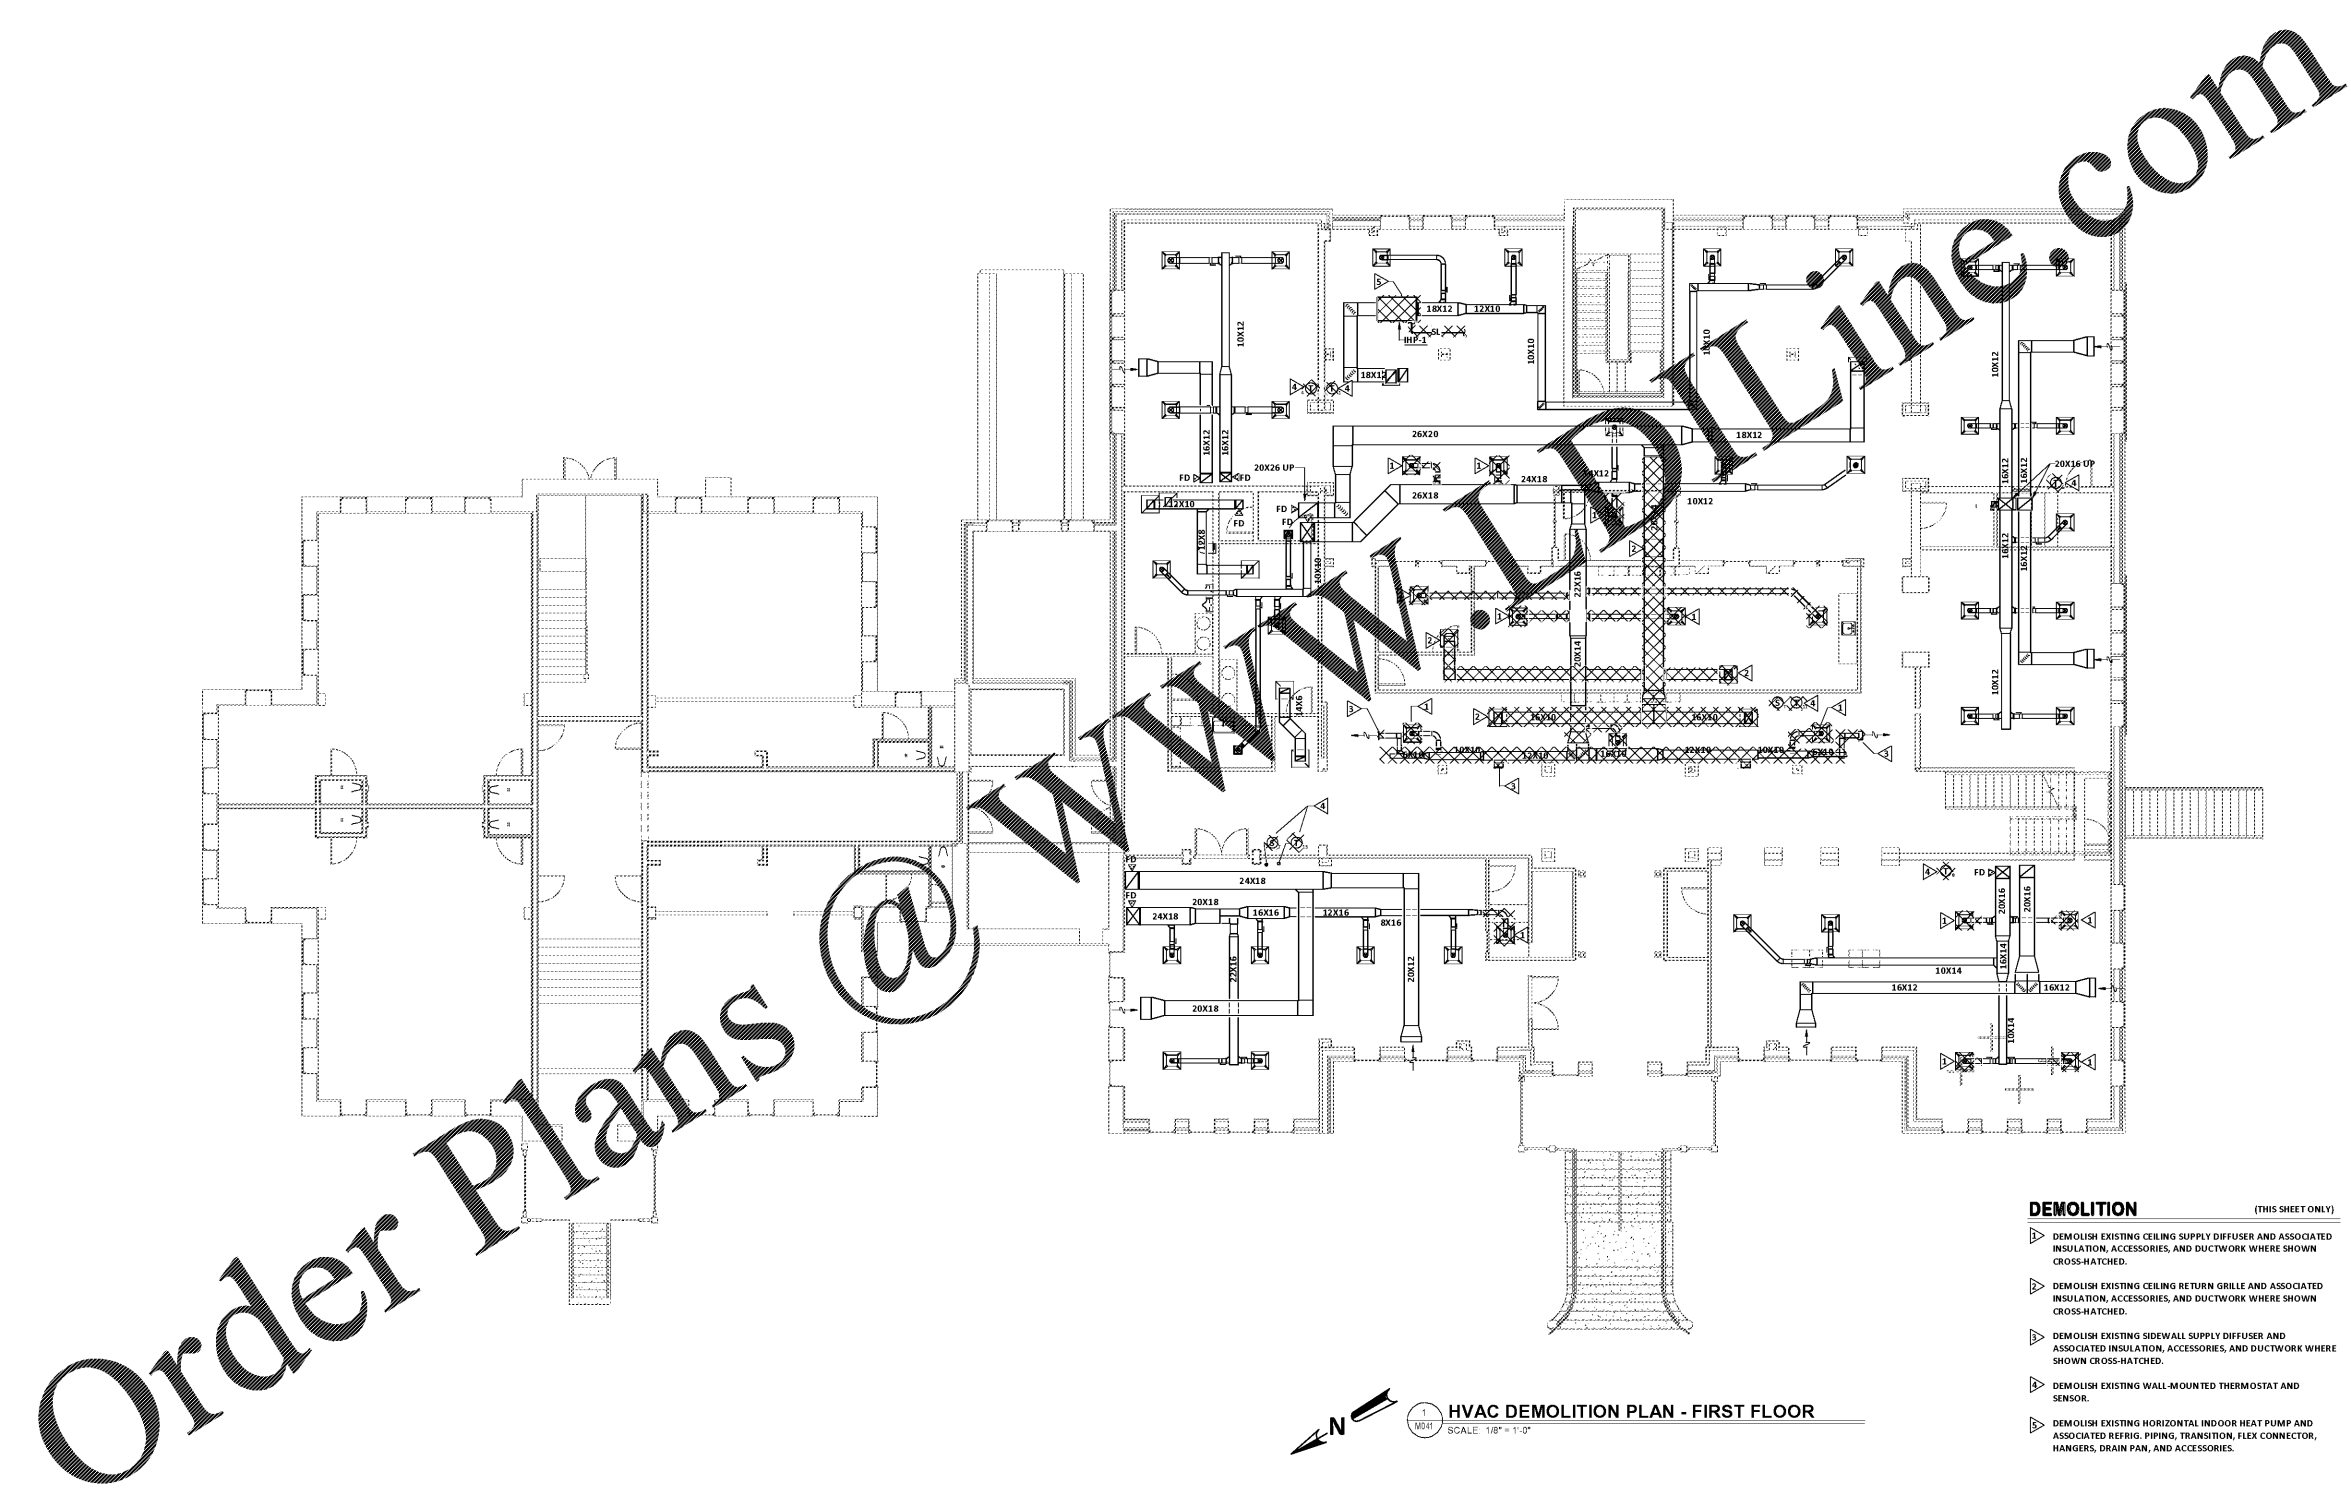

- DEMOLITION** (THIS SHEET ONLY)
- ▷ DEMOLISH EXISTING CEILING SUPPLY DIFFUSER AND ASSOCIATED INSULATION, ACCESSORIES, AND DUCTWORK WHERE SHOWN CROSS-HATCHED.
 - ▷ DEMOLISH EXISTING CEILING RETURN GRILLE AND ASSOCIATED INSULATION, ACCESSORIES, AND DUCTWORK WHERE SHOWN CROSS-HATCHED.
 - ▷ DEMOLISH EXISTING SIDEWALL SUPPLY DIFFUSER AND ASSOCIATED INSULATION, ACCESSORIES, AND DUCTWORK WHERE SHOWN CROSS-HATCHED.
 - ▷ DEMOLISH EXISTING WALL-MOUNTED THERMOSTAT AND SENSOR.
 - ▷ DEMOLISH EXISTING HORIZONTAL INDOOR HEAT PUMP AND ASSOCIATED REFRIG. PIPING, TRANSITION, FLEX CONNECTOR, HANGERS, DRAIN PAN, AND ACCESSORIES.

 HVAC DEMOLITION PLAN - FIRST FLOOR
SCALE: 1/8" = 1'-0"



PLOT DATE: 4/9/2020
FILE NAME: 19088
PLOT SCALE: 1 = 96
RWW

MCMILIAN PZDAN SMITH ARCHITECTURE, INC. 1000 W. UNIVERSITY AVENUE, SUITE 100, ALBUQUERQUE, NM 87102-3959
 PRUETT, FORD & ASSOCIATES, INC. 1201 BROAD STREET, SUITE 3A, ALBUQUERQUE, GEORGIA 3000
 706/72-3959 • FAX 706/72-8277
 ALL RIGHTS RESERVED