

AIKEN COUNTY
AIKEN PUBLIC LIBRARY & NORTH WING
RENOVATION
314 CHESTERFIELD ST, AIKEN, SC


NO.	DATE	DESCRIPTION	BY
D	04/10/2020	Permit Set	JMF
E	07/02/2020	ISSUED FOR BIDS	JMF

ISSUED FOR BIDS 07/02/2020
PRINCIPAL IN CHARGE JMF
PROJECT ENGINEER DJM
DRAWN BY RWW

SHEET TITLE
HVAC NEW WORK
GROUND FLOOR PLAN

SHEET NO. PRJ NO.
019477.01

M100

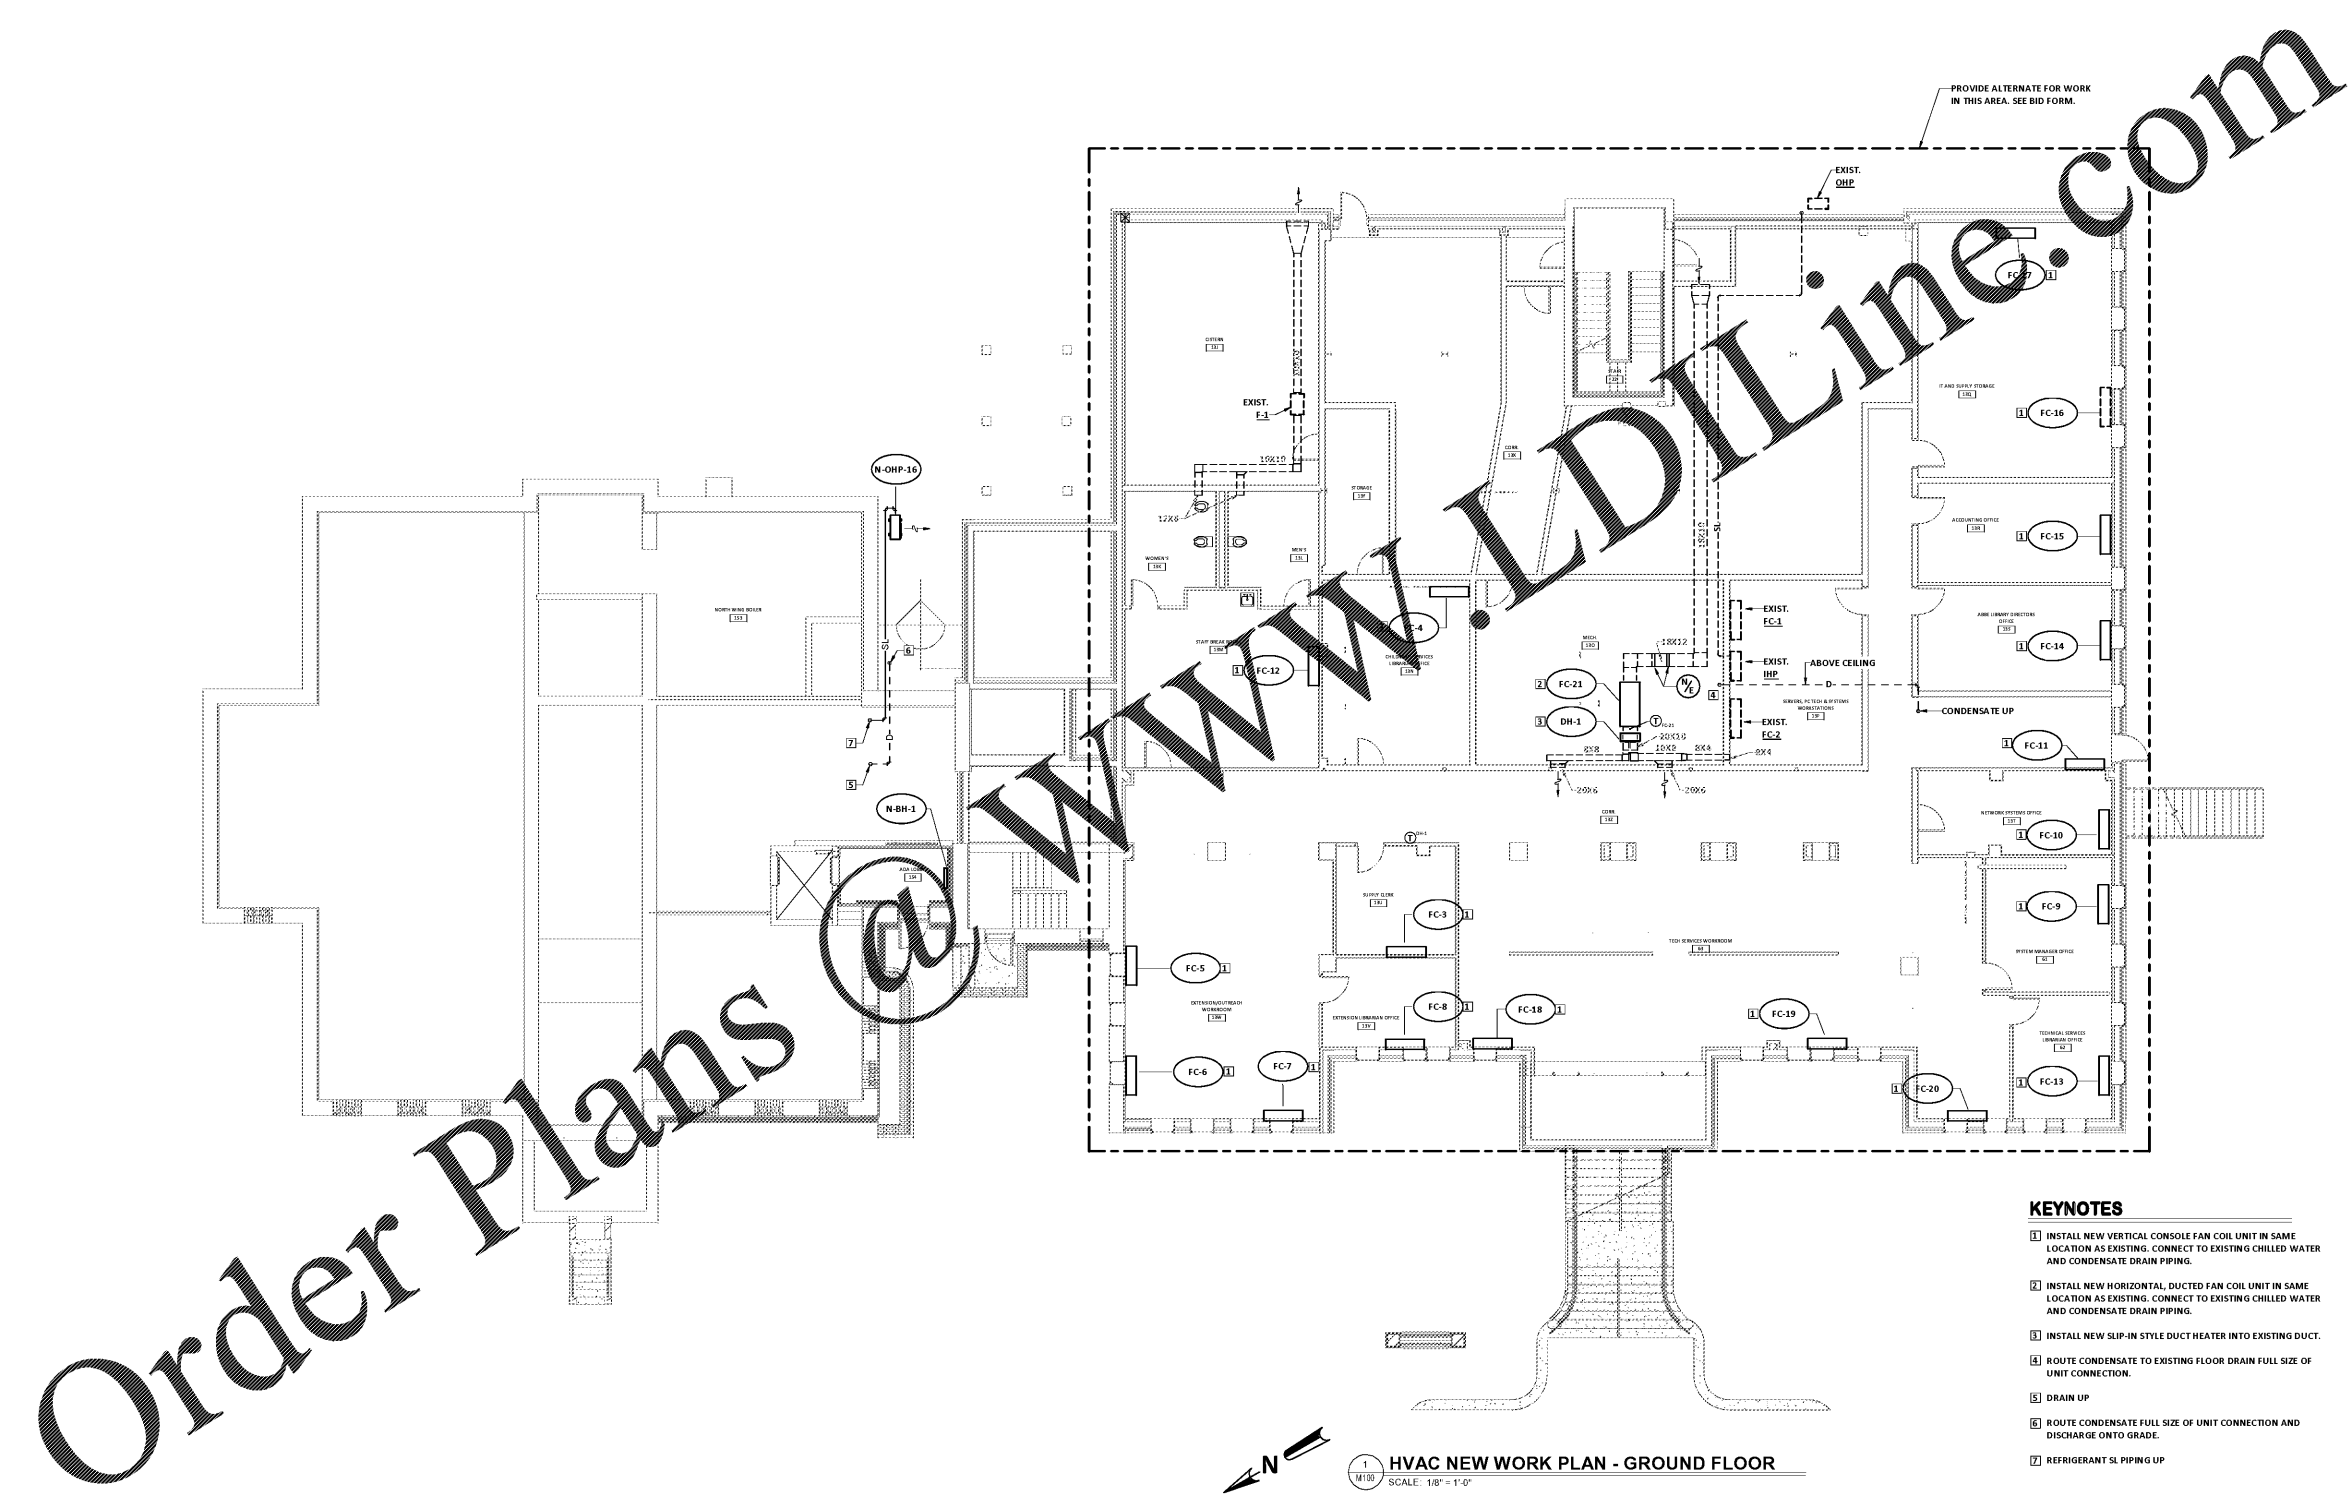

- KEYNOTES**
- 1] INSTALL NEW VERTICAL CONSOLE FAN COIL UNIT IN SAME LOCATION AS EXISTING. CONNECT TO EXISTING CHILLED WATER AND CONDENSATE DRAIN PIPING.
 - 2] INSTALL NEW HORIZONTAL, DUCTED FAN COIL UNIT IN SAME LOCATION AS EXISTING. CONNECT TO EXISTING CHILLED WATER AND CONDENSATE DRAIN PIPING.
 - 3] INSTALL NEW SLIP-IN STYLE DUCT HEATER INTO EXISTING DUCT.
 - 4] ROUTE CONDENSATE TO EXISTING FLOOR DRAIN FULL SIZE OF UNIT CONNECTION.
 - 5] DRAIN UP
 - 6] ROUTE CONDENSATE FULL SIZE OF UNIT CONNECTION AND DISCHARGE ONTO GRADE.
 - 7] REFRIGERANT SLIP PIPING

1
HVAC NEW WORK PLAN - GROUND FLOOR
SCALE: 1/8" = 1'-0"

GRAPHIC SCALE
0 10 20 30
FEET

PLOT DATE: 4/9/2020
FILE NAME: 19088
PLOT SCALE: 1 = 96
RWW

COPYRIGHT © 2020
PRUETT, FORD & ASSOCIATES, INC.
ALBUQUERQUE, NM 87102-3999

ALL RIGHTS RESERVED. NO PART OF THIS DOCUMENT IS TO BE REPRODUCED OR TRANSMITTED IN ANY FORM OR BY ANY MEANS, ELECTRONIC OR MECHANICAL, INCLUDING PHOTOCOPYING, RECORDING, OR BY ANY INFORMATION STORAGE AND RETRIEVAL SYSTEM, WITHOUT THE WRITTEN PERMISSION OF THE CONSULTANT. THE CONSULTANT'S LIABILITY IS LIMITED TO THE PROFESSIONAL SERVICES PROVIDED HEREIN. THE CONSULTANT DOES NOT WARRANT THE ACCURACY OF THE INFORMATION PROVIDED HEREIN. THE CONSULTANT'S LIABILITY IS LIMITED TO THE PROFESSIONAL SERVICES PROVIDED HEREIN. THE CONSULTANT DOES NOT WARRANT THE ACCURACY OF THE INFORMATION PROVIDED HEREIN.