



AIKEN COUNTY
AIKEN PUBLIC LIBRARY & NORTH WING
RENOVATION
314 CHESTERFIELD ST. S. AIKEN, SC


NO.	DATE	DESCRIPTION	BY
D	04/10/2020	Permit Set	JMF
E	07/02/2020	ISSUED FOR BIDS	JMF

ISSUED FOR BIDS 07/02/2020
PRINCIPAL IN CHARGE JMF
PROJECT ENGINEER DJM
DRAWN BY RWW

SHEET TITLE
HVAC NEW WORK
FIRST FLOOR PLAN

SHEET NO. PRJ NO.
019477 01

M110

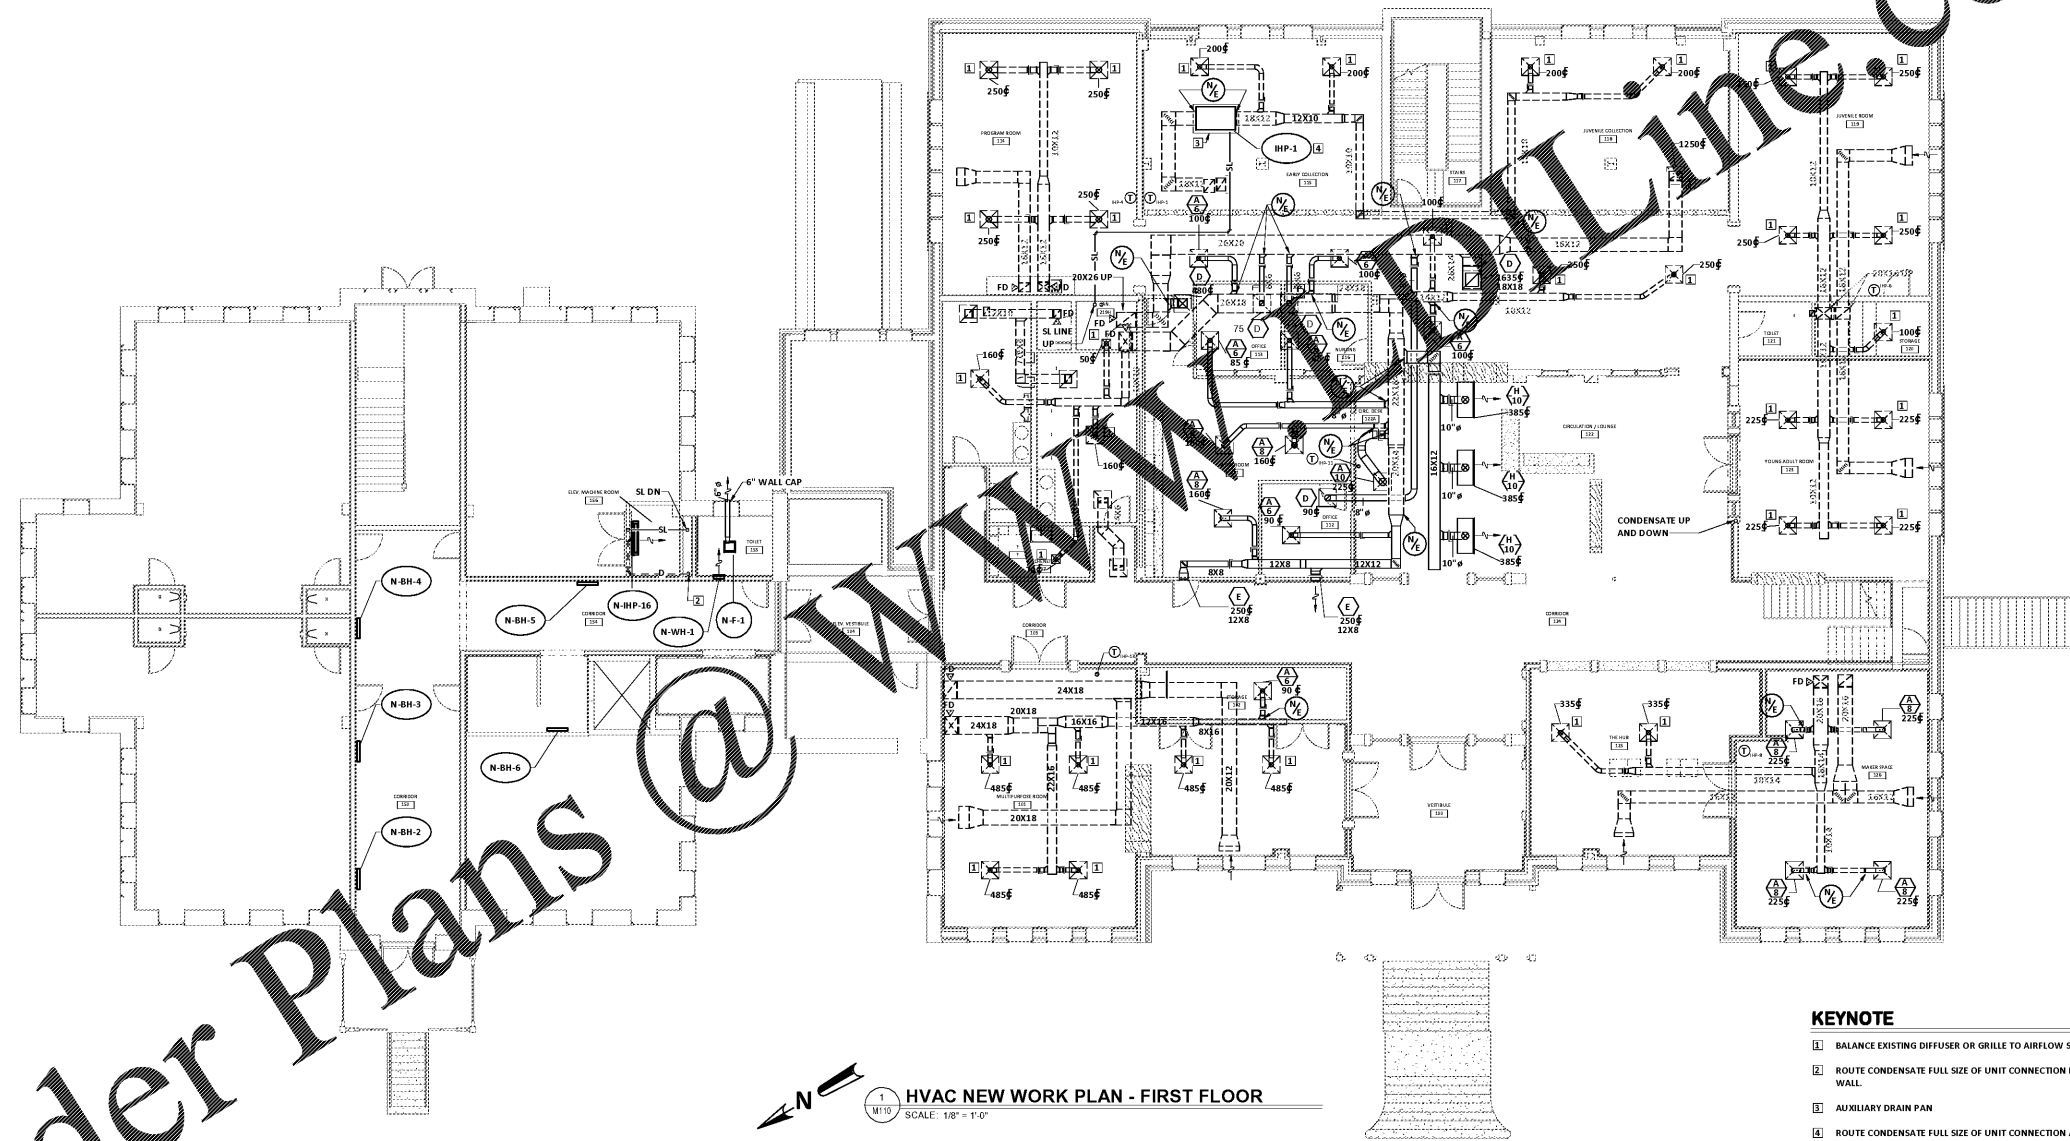

KEYNOTE

- 1 BALANCE EXISTING DIFFUSER OR GRILLE TO AIRFLOW SHOWN.
- 2 ROUTE CONDENSATE FULL SIZE OF UNIT CONNECTION DOWN IN WALL.
- 3 AUXILIARY DRAIN PAN
- 4 ROUTE CONDENSATE FULL SIZE OF UNIT CONNECTION AND CONNECT TO EXISTING DRAIN.

1
M110
HVAC NEW WORK PLAN - FIRST FLOOR
SCALE: 1/8" = 1'-0"

Order Plans @ www.dolline.com

ALL RIGHTS RESERVED. THIS DOCUMENT IS THE PROPERTY OF MCMILIAN PAZDAN SMITH ARCHITECTURE. IT IS TO BE USED ONLY FOR THE PROJECT AND SITE SPECIFICALLY IDENTIFIED HEREIN. NO PART OF THIS DOCUMENT IS TO BE REPRODUCED OR TRANSMITTED IN ANY FORM OR BY ANY MEANS, ELECTRONIC OR MECHANICAL, INCLUDING PHOTOCOPYING, RECORDING, OR BY ANY INFORMATION STORAGE AND RETRIEVAL SYSTEM, WITHOUT THE WRITTEN PERMISSION OF MCMILIAN PAZDAN SMITH ARCHITECTURE.

1
2
3
4
5

PLOT DATE: 4/9/2020
 FILE NAME: 19088
 PLOT SCALE: 1 = 96
 RWW