


AIKEN COUNTY  
**AIKEN PUBLIC LIBRARY & NORTH WING  
RENOVATION**  
314 CHESTERFIELD ST, AIKEN, SC

SHEET ISSUE			
NO.	DATE	DESCRIPTION	BY
D	04/10/2020	Permit Set	JMF
E	07/02/2020	ISSUED FOR BIDS	JMF

ISSUED FOR BIDS 07/02/2020  
PRINCIPAL IN CHARGE JMF  
PROJECT ENGINEER DJM  
DRAWN BY RWW  
SHEET TITLE  
**HVAC NEW WORK  
SECOND FLOOR PLAN**

SHEET NO. PRJ NO.  
M120 019477.01

**M120**

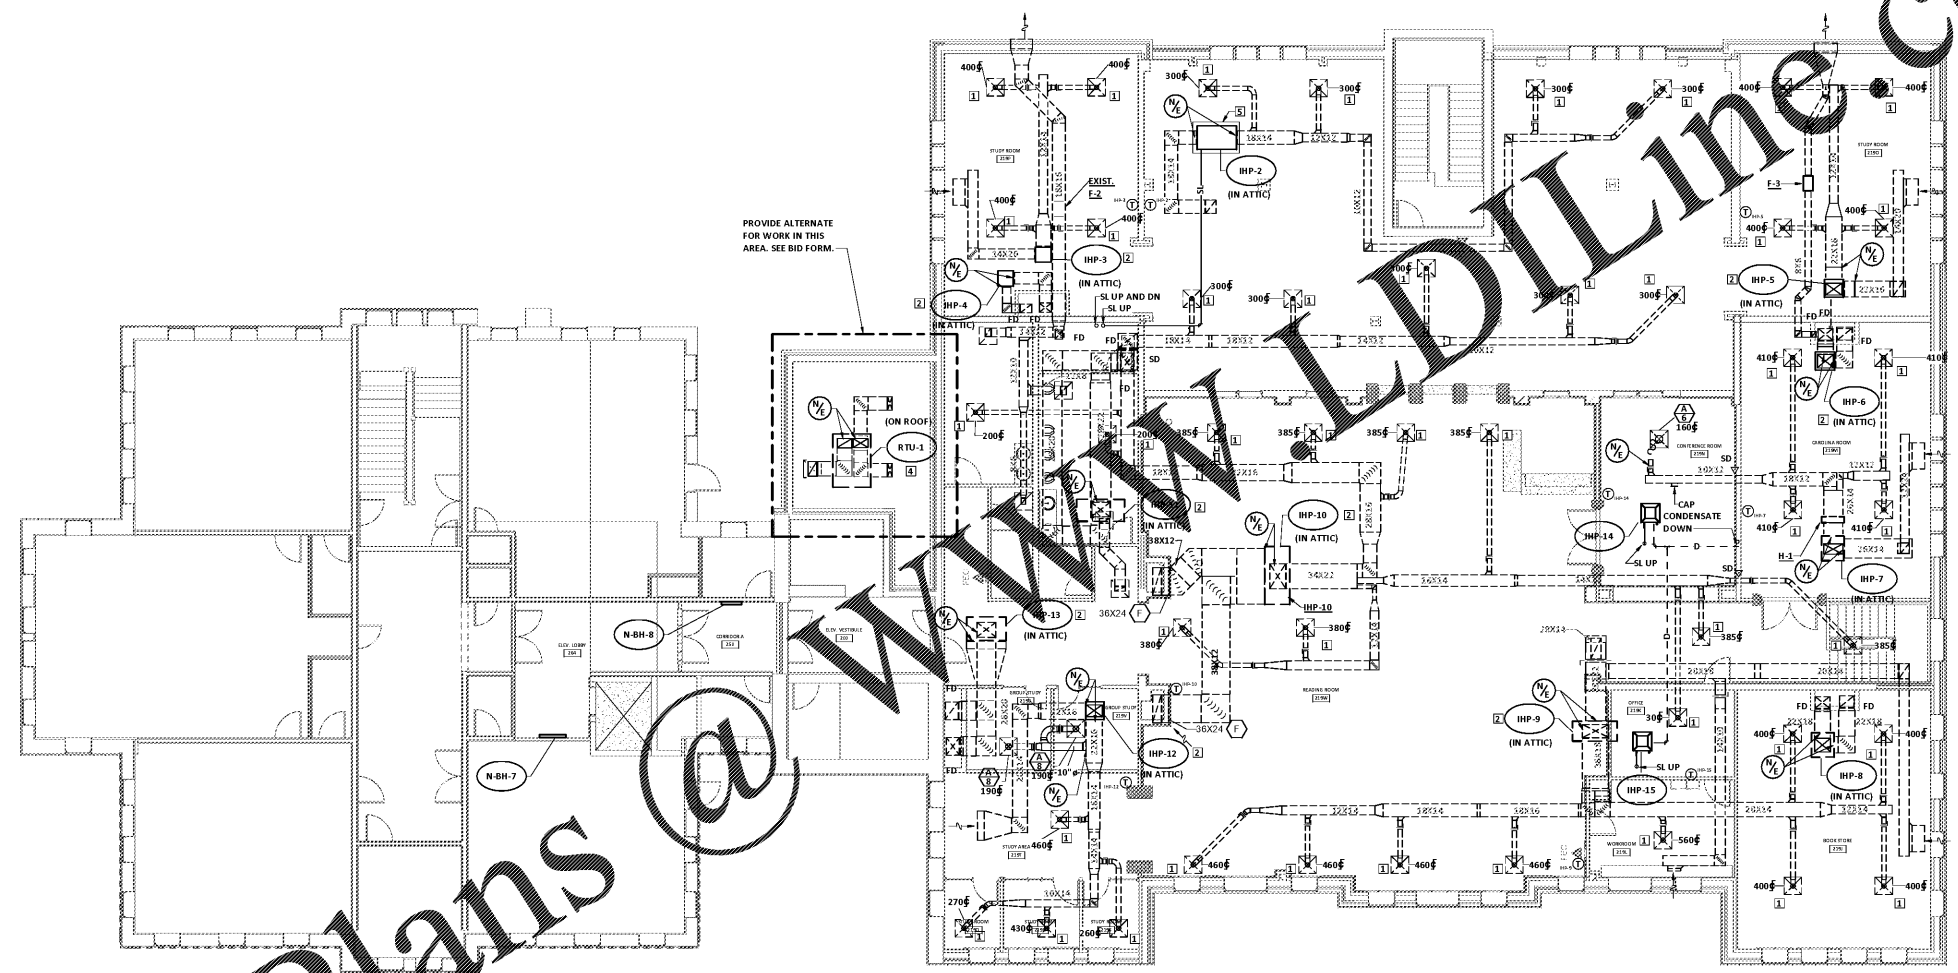

**HVAC NEW WORK PLAN - SECOND FLOOR**  
SCALE: 1/8" = 1'-0"

- KEYNOTE**
- 1 BALANCE EXISTING DIFFUSER OR GRILLE TO AIRFLOW SHOWN.
  - 2 ROUTE CONDENSATE FULL SIZE OF UNIT CONNECTION AND CONNECT TO EXISTING DRAIN.
  - 3 ROUTE CONDENSATE FULL SIZE OF UNIT CONNECTION AND CONNECT TO PLUMBING DRAIN AS SHOWN.
  - 4 ROUTE CONDENSATE FULL SIZE OF UNIT CONNECTION AND DISCHARGE IN NEAREST ROOF DRAIN.
  - 5 AUXILIARY DRAIN PAN.

1/4" 1/2" 3/4" 1" REFERENCE SCALE  
PLOT DATE: 4/9/2020  
FILE NAME: 19088  
PLOT SCALE: 1 = 96  
RWW

Order Plans @ [www.diline.com](http://www.diline.com)

www.diline.com

ALL INFORMATION CONTAINED HEREIN IS THE PROPERTY OF PRUETT, FORD & ASSOCIATES, INC. AND IS TO BE USED ONLY FOR THE PROJECT AND SITE SPECIFICALLY IDENTIFIED HEREIN. ANY REUSE OR DISTRIBUTION OF THIS INFORMATION WITHOUT THE WRITTEN CONSENT OF PRUETT, FORD & ASSOCIATES, INC. IS STRICTLY PROHIBITED.