




AIKEN COUNTY
**AIKEN PUBLIC LIBRARY & NORTH WING
RENOVATION**
314 CHESTERFIELD ST. S. AIKEN, SC

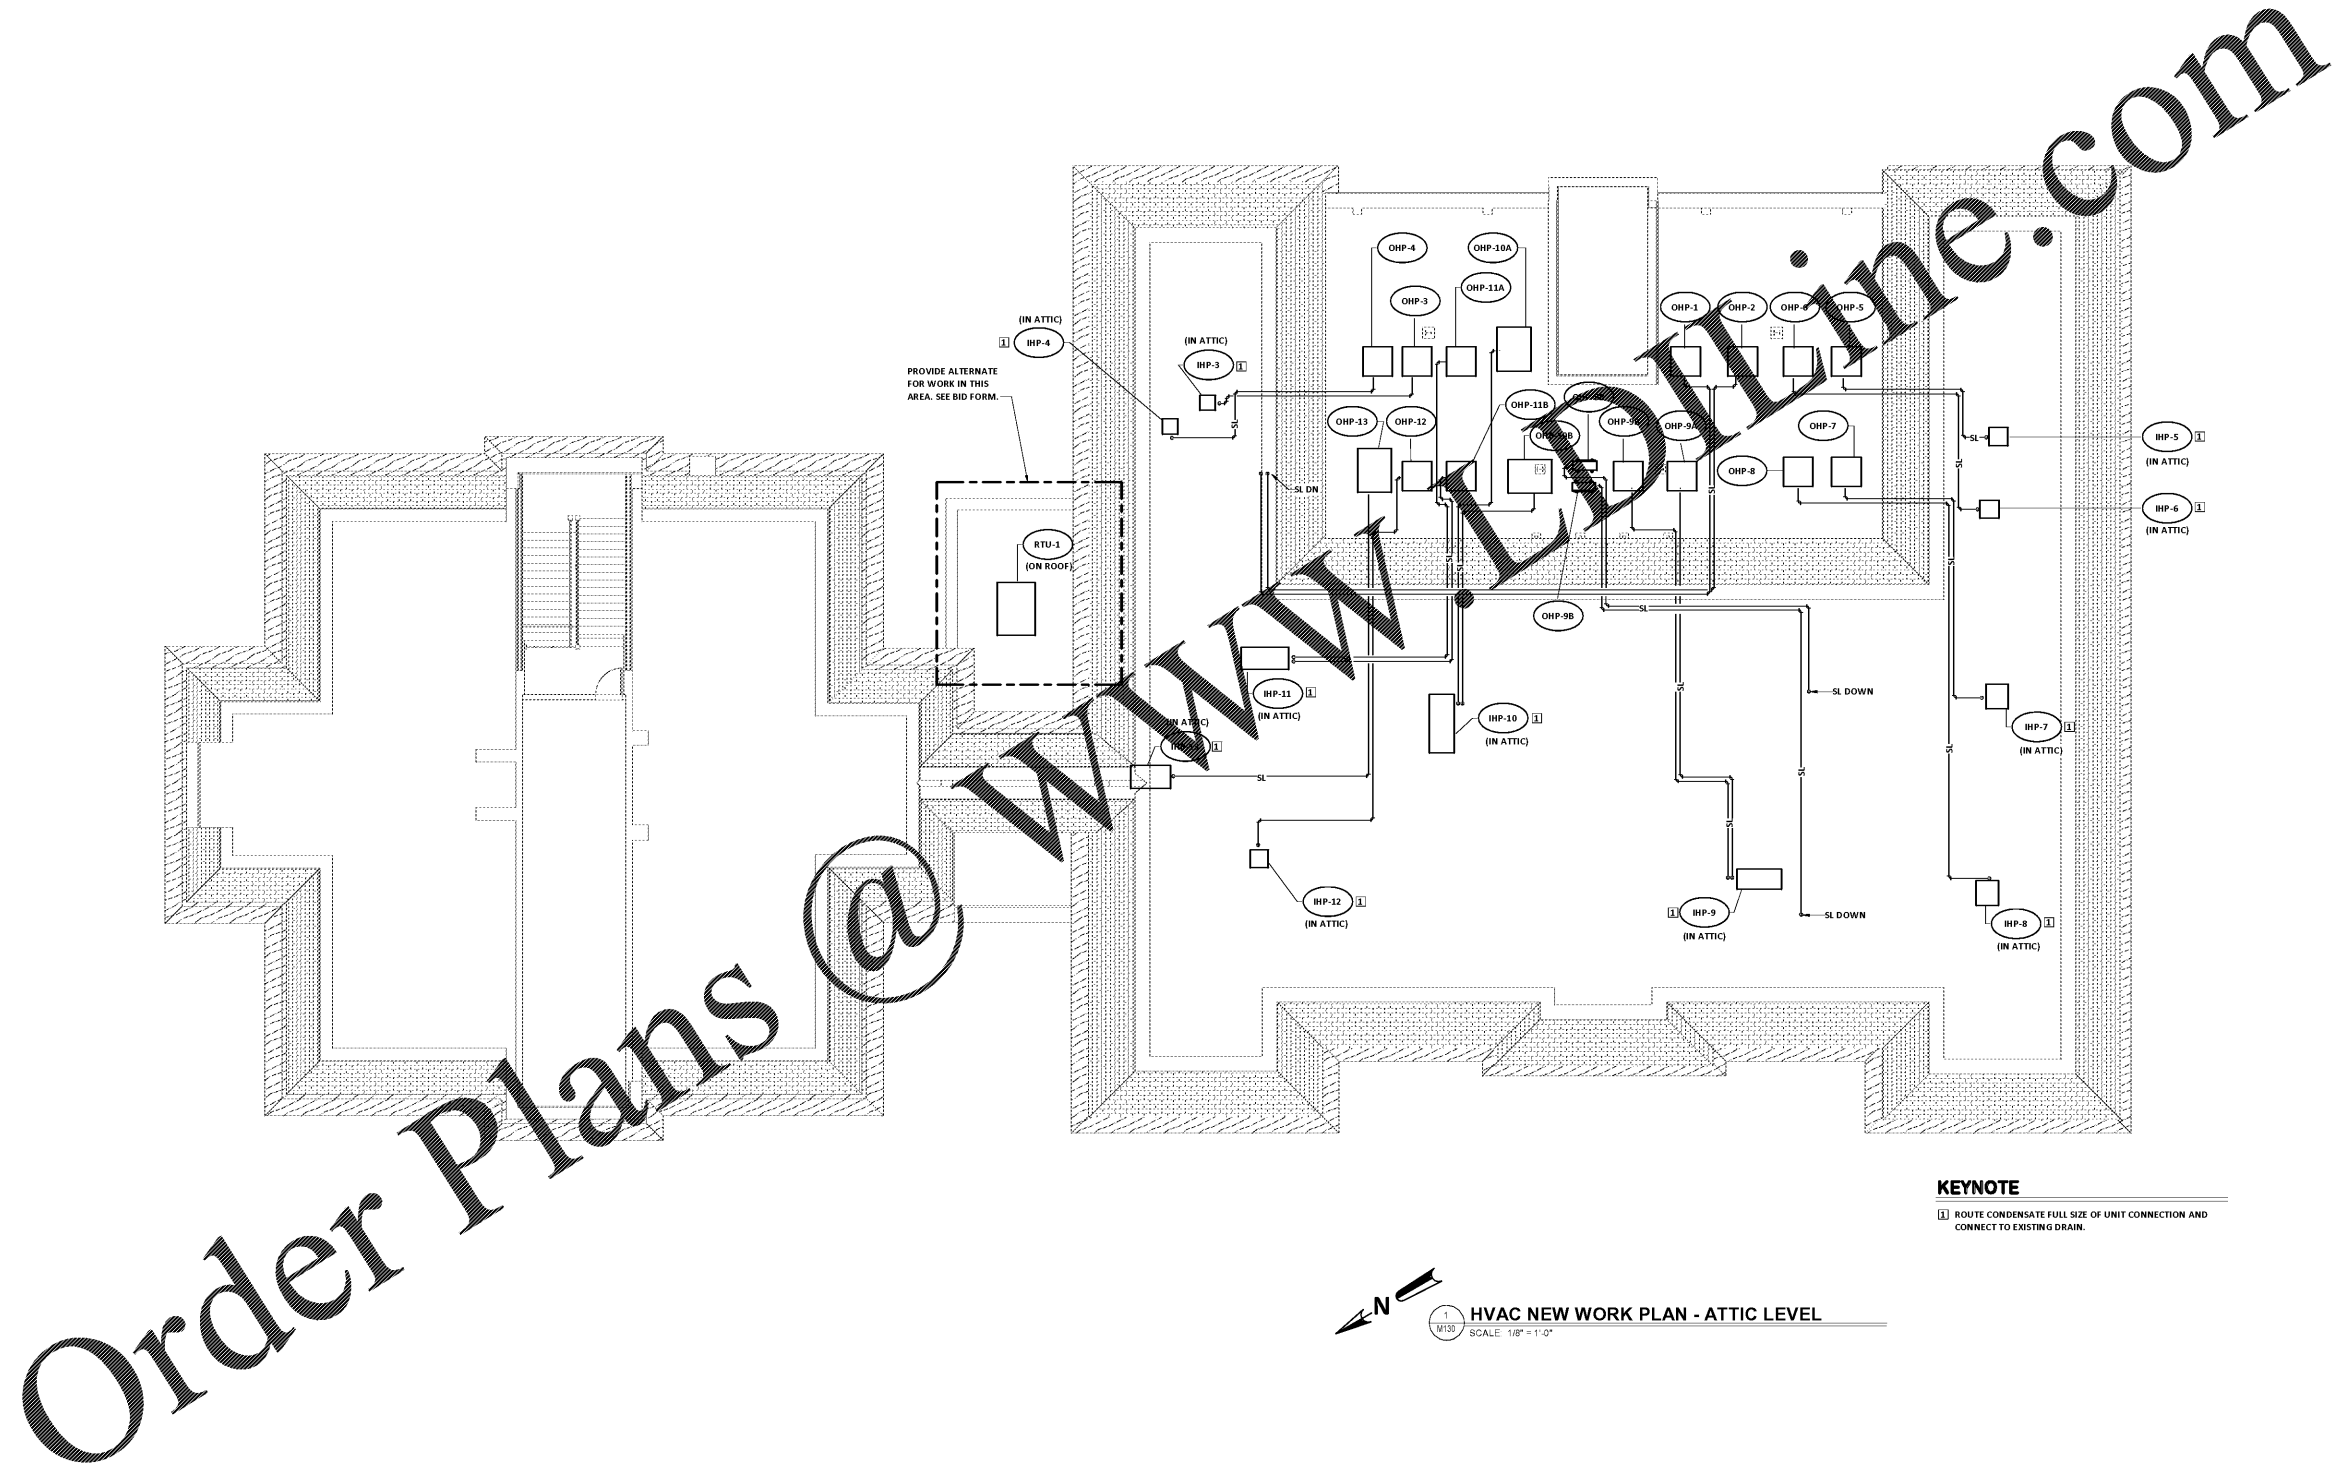

KEYNOTE
 [] ROUTE CONDENSATE FULL SIZE OF UNIT CONNECTION AND CONNECT TO EXISTING DRAIN.

HVAC NEW WORK PLAN - ATTIC LEVEL
 SCALE: 1/8" = 1'-0"

SHEET ISSUE:			
NO.	DATE	DESCRIPTION	BY
D	04/10/2020	Permit Set	JMF
E	07/02/2020	ISSUED FOR BIDS	JMF

ISSUED FOR BIDS: 07/02/2020
 PRINCIPAL IN CHARGE: JMF
 PROJECT ENGINEER: DJM
 DRAWN BY: RWW

SHEET TITLE:
**HVAC NEW WORK
 ROOF PLAN**

SHEET NO. PROJ. NO.
 019477.01

M130



PLOT DATE: 4/9/2020
 FILE NAME: 19088
 PLOT SCALE: 1 = 96
 RWW