


**KEYED NOTES:**

- 1 EXISTING HVAC UNIT IS BEING REPLACED WITH NEW. REPLACE BREAKER AB-27 WITH A 35A/2P BREAKER. PROVIDE NEW 600 DISCONNECT AND PULL NEW WIRE.
- 2 REMOVE EXISTING 30A/2P BREAKER AT POLE SPARE 27 AD 29 SERVING EXISTING THP-1 UNIT AND REPLACE WITH NEW 35A/2P BREAKER TO FEED IHP-1. REVISE PANELBOARDED SCHEDULE ACCORDINGLY.

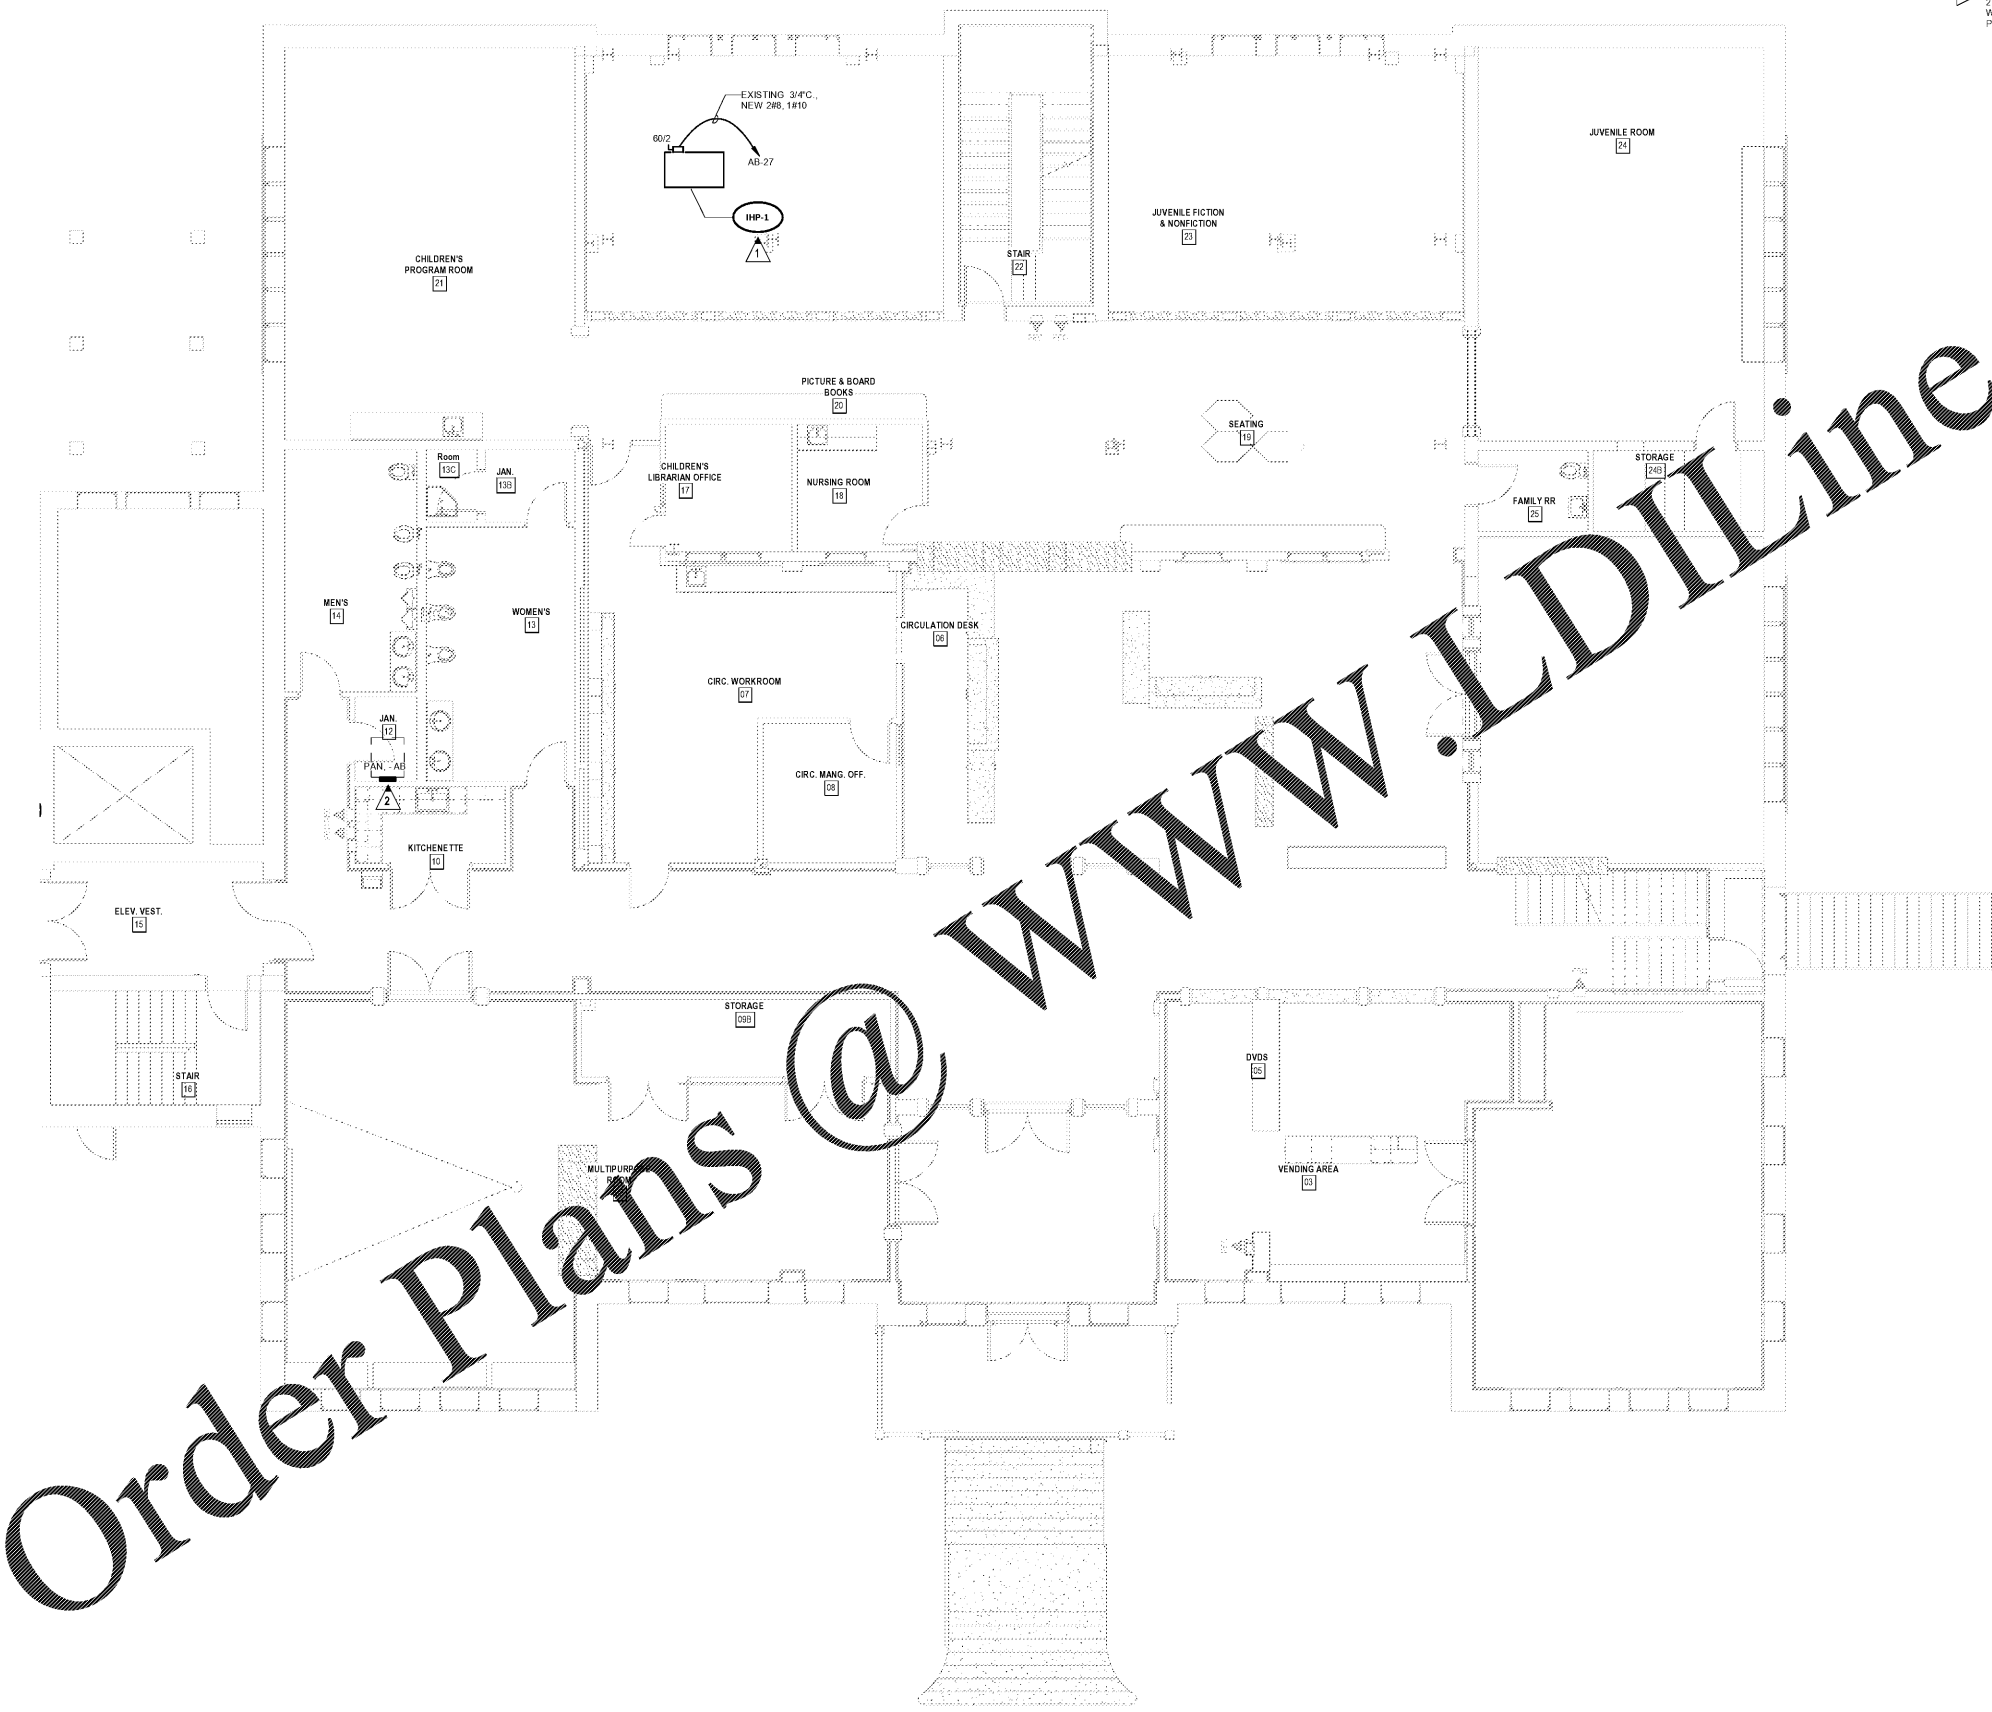

CONSULTANT LOGO  
**EDC** ELECTRICAL ENGINEERS  
 1201 BROAD ST., SUITE 1-A  
 AUGUSTA, GA 30901  
 PH: (706) 724-2681  
 FAX: (706) 724-8567  
 REG. STATE OF GA. EDC PROJECT # 19128



Order Plans @ www.LDILine.com

AIKEN COUNTY  
**AIKEN PUBLIC LIBRARY & NORTH WING  
 RENOVATION**  
 314 CHESTERFIELD ST. S. AIKEN, SC

SHEET ISSUE:

NO.	DATE	DESCRIPTION	BY
A	01/27/2020	SD PRICING SET	
B	03/09/2020	DD SET	
D	04/19/2020	PERMIT SET	
E	07/02/2020	ISSUED FOR BIDS	

ISSUED FOR BIDS: 07/02/2020  
 PRINCIPAL IN CHARGE: MAP  
 PROJECT ENGINEER: ALG  
 DRAWN BY: ALG

SHEET TITLE:  
**MECHANICAL  
 POWER PLAN -  
 FIRST LEVEL**

SHEET NO. PROJ. NO.  
 E401 019477.01

1 MECHANICAL POWER PLAN - FIRST LEVEL  
 E401 SCALE: 3/16" = 1'-0"

ALL RIGHTS RESERVED. THIS DOCUMENT IS THE PROPERTY OF MCMILIAN PAZDAN SMITH ARCHITECTURE. IT IS TO BE USED ONLY FOR THE PROJECT AND SITE SPECIFICALLY IDENTIFIED HEREIN. NO PART OF THIS DOCUMENT IS TO BE REPRODUCED, STORED IN A RETRIEVING SYSTEM, OR TRANSMITTED IN ANY FORM OR BY ANY MEANS, ELECTRONIC OR MECHANICAL, INCLUDING PHOTOCOPYING, RECORDING, OR BY ANY INFORMATION STORAGE AND RETRIEVAL SYSTEM, WITHOUT THE WRITTEN PERMISSION OF MCMILIAN PAZDAN SMITH ARCHITECTURE.