


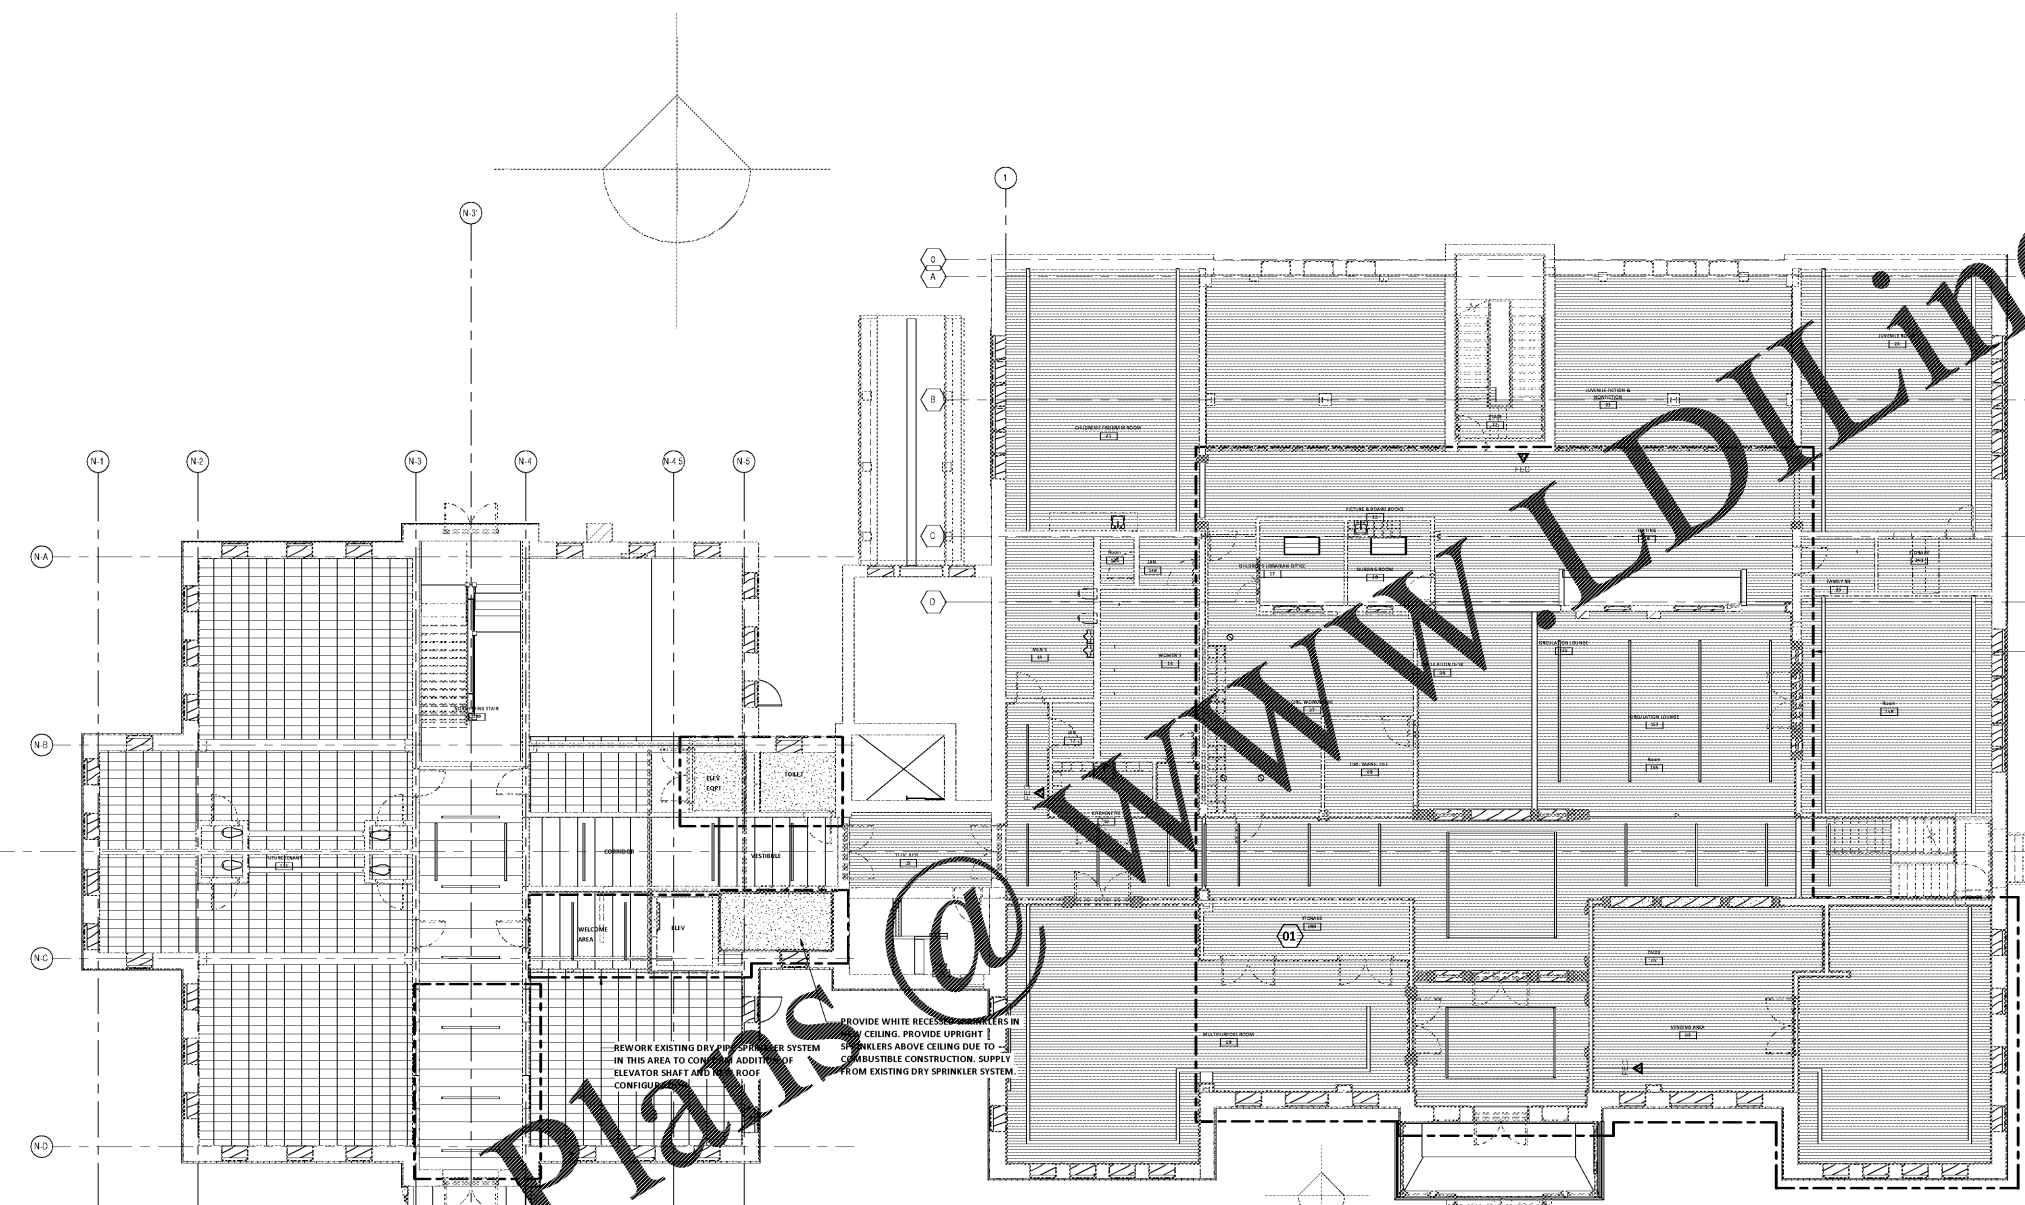

AREA HAZARD
ALL AREAS SHALL BE GARDED AS LIGHT HAZARD UNLESS NOTED
OTHER WISE

ORDINARY HAZARD GROUP 1



REWORK EXISTING SPRINKLER SYSTEM TO CONFORM TO NEW ROOM, WALL, CEILING, HVAC, AND LIGHTING CONFIGURATION.

PROVIDE WHITE RECESSED SPRINKLERS IN NEW TILE CEILING. PROVIDE UPRIGHT SPRINKLERS ABOVE CEILING DUE TO COMBUSTIBLE CONSTRUCTION. PROVIDE UPRIGHT WHITE SPRINKLERS IN SPACES WITH OUR CEILINGS.

REWORK EXISTING DRY PIPE SPRINKLER SYSTEM IN THIS AREA TO CONFORM TO NEW ROOM AND CEILING CONFIGURATION. PROVIDE UPRIGHT SPRINKLERS ABOVE CEILING DUE TO COMBUSTIBLE CONSTRUCTION. SUPPLY FROM EXISTING DRY SPRINKLER SYSTEM.

REWORK EXISTING SPRINKLER SYSTEM IN THIS AREA FOR NEW ROOM AND CEILING CONFIGURATION. PROVIDE UPRIGHT SPRINKLERS.

FIRE PROTECTION NEW WORK PLAN - FIRST FLOOR
SCALE: 1/8" = 1'-0"

SHEET ISSUE			
NO.	DATE	DESCRIPTION	BY
D	04/10/2020	Permit Set	JMF
E	07/02/2020	ISSUED FOR BIDS	JMF

ISSUED FOR BIDS 07/02/2020

PRINCIPAL IN CHARGE JMF
PROJECT ENGINEER JCP
DRAWN BY RWW

SHEET TITLE
**FIRE PROTECTION
NEW WORK FIRST
FLOOR PLAN**

SHEET NO. PRJ NO.
FP110 019477.01

FP110

SCALE: 1/8" = 1'-0"

PLOT DATE: 4/9/2020
FILE NAME: 19088
PLOT SCALE: 1 = 96
RWW

COPYRIGHT © 2020
PRUETT, FORD & ASSOCIATES, INC.
ALBUQUERQUE, NM 87102-3999

Order Plans @ www.LDILine.com