




JACKSON COUNTY
ANIMAL RESCUE CENTER AND GREEN ENERGY PARK
DILLSBORO, NORTH CAROLINA

SHEET ISSUE NO.	DATE	DESCRIPTION	BY
1	9/2/2020	ISSUE FOR BID + PERMIT	WR

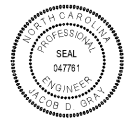


PRINCIPAL IN CHARGE: GARY WARNER
PROJECT ARCHITECT: WR
DRAWN BY: WR



SHEET TITLE:
UTILITY PLAN

SHEET NO. PROJ. NO.
C3.0 02-191340

CONTRACTOR IS EXPLICITLY ADMISED TO FIELD LOCATE AND VERIFY LOCATION OF ALL EXISTING UTILITIES PRIOR TO CONSTRUCTION. LOCATION OF EXISTING UNDERGROUND UTILITIES SHOWN ON PLANS IS APPROXIMATE BASED ON BEST AVAILABLE INFORMATION AND SHOULD BE CONSIDERED APPROXIMATE. CONTRACTOR TO REPORT ANY DISCREPANCIES TO LANDSCAPE ARCHITECT/ENGINEER PRIOR TO ANY CONSTRUCTION ACTIVITIES.

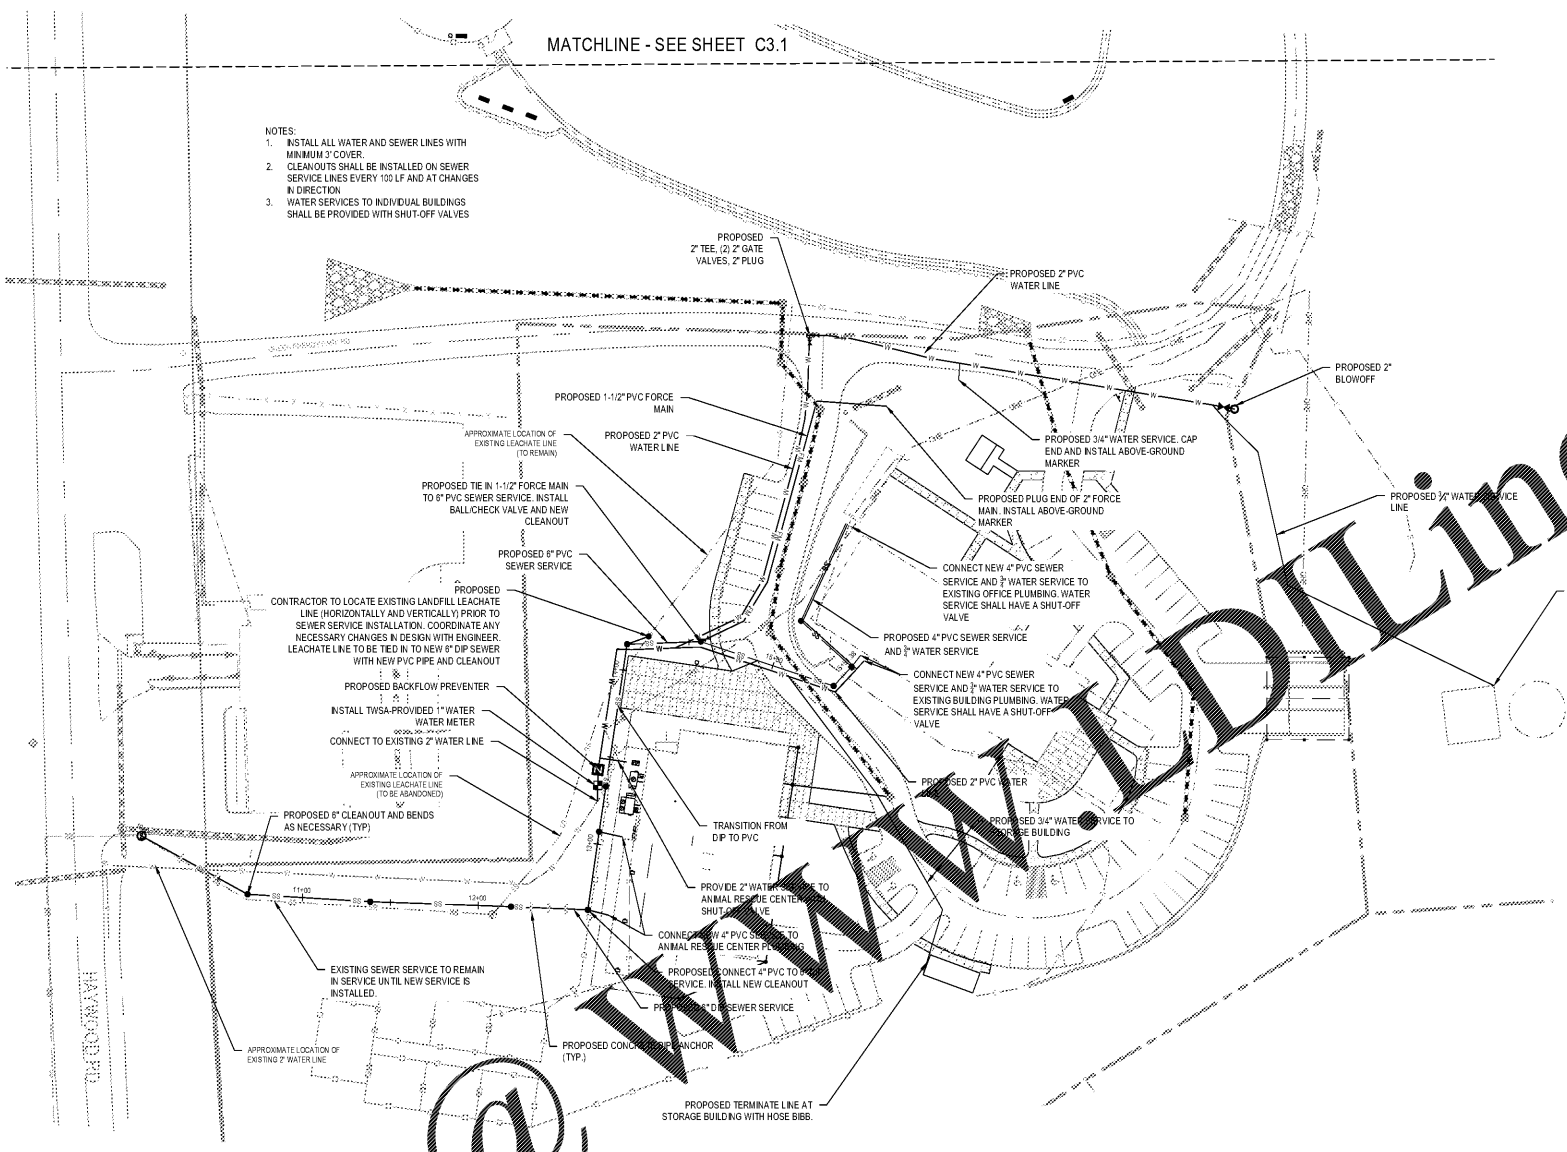

- NOTES:
1. INSTALL ALL WATER AND SEWER LINES WITH MINIMUM 3' COVER.
 2. CLEANOUTS SHALL BE INSTALLED ON SEWER SERVICE LINES EVERY 100 LF AND AT CHANGES IN DIRECTION.
 3. WATER SERVICES TO INDIVIDUAL BUILDINGS SHALL BE PROVIDED WITH SHUT-OFF VALVES.

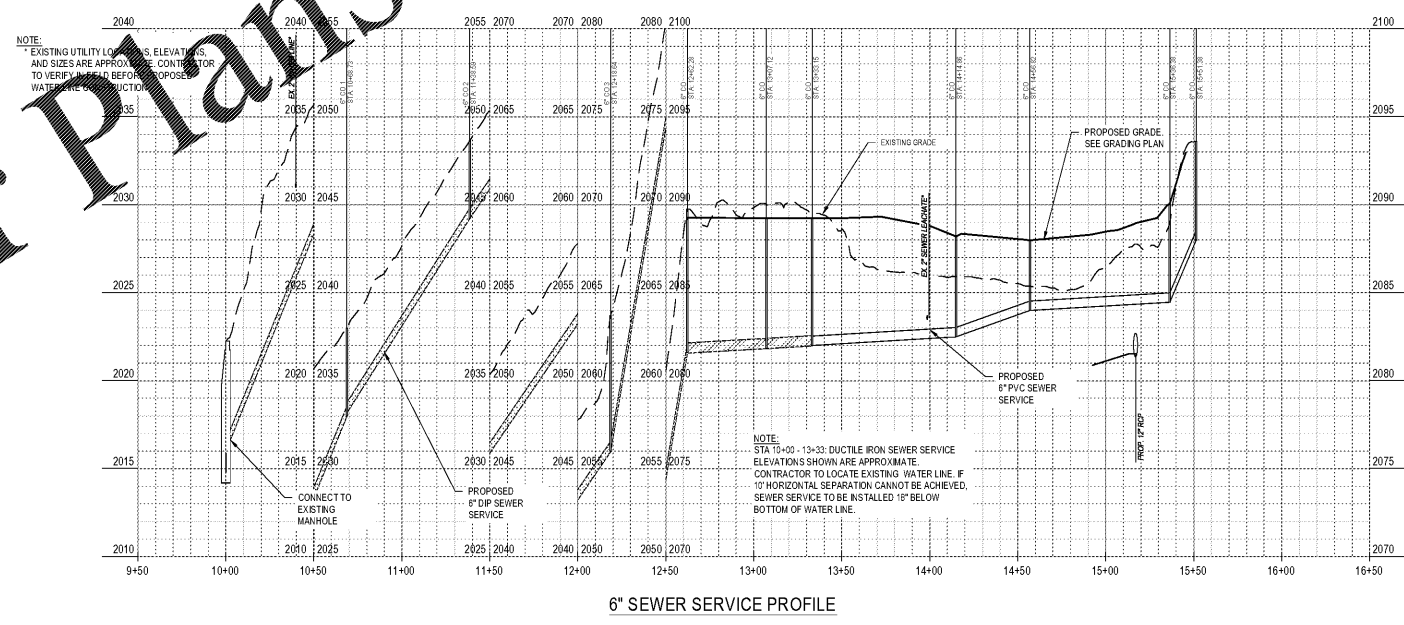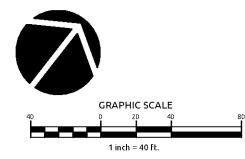

6" SEWER SERVICE PROFILE

ALL DRAWING SPECIFICATIONS AND NOTES ARE THE PROPERTY OF MCMILLAN PAZDAN SMITH ARCHITECTURE. THESE DRAWINGS ARE TO BE USED ONLY FOR THE PROJECT AND SITE SPECIFICALLY IDENTIFIED THEREIN. ANY REUSE OR MODIFICATION OF THESE DRAWINGS WITHOUT THE WRITTEN CONSENT OF MCMILLAN PAZDAN SMITH ARCHITECTURE IS STRICTLY PROHIBITED. THE USER ASSUMES ALL LIABILITY FOR ANY ERRORS OR OMISSIONS. MCMILLAN PAZDAN SMITH ARCHITECTURE SHALL NOT BE RESPONSIBLE FOR ANY CONSTRUCTION DEFECTS OR DAMAGES RESULTING FROM THE USE OF THESE DRAWINGS.

Order Plans @

www.DIline.com