 

 

 







REFLECTED CEILING PLAN LEGEND


-  2X2 ACOUSTICAL PANEL CEILING. SEE FINISH SCHEDULE
-  GYPSUM CEILING
-  2X4 LAY-IN LIGHT FIXTURE
-  HIGH BAY FIXTURE
-  1X4 UTILITY LIGHT FIXTURE PENDANT
-  DOWNLIGHT
-  SUPPLY DIFFUSER
-  RETURN DIFFUSER
-  FEMS STRUCTURE
-  SECURITY CAMERA

REFLECTED CEILING PLAN NOTES

1. ALL ACOUSTIC CEILING TILE IS CENTERED ON ROOM U/I O.

CONSULTANT LOGO

SEAL

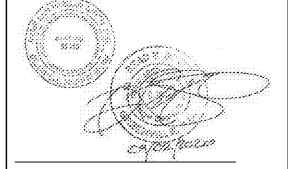


JACKSON COUNTY  
ANIMAL RESCUE CENTER AND GREEN ENERGY  
PARK  
DILLSBORO, NORTH CAROLINA

| SHEET ISSUE NO. | DATE      | DESCRIPTION            | BY |
|-----------------|-----------|------------------------|----|
| 1               | 9/22/2020 | ISSUE FOR BID + PERMIT |    |

PRINCIPAL IN CHARGE  
PROJECT ARCHITECT  
DRAWN BY: CP  
ADD

SHEET TITLE:  
**REFLECTED  
CEILING PLAN**

SHEET NO. PROJ. NO.  
A210 019216.00

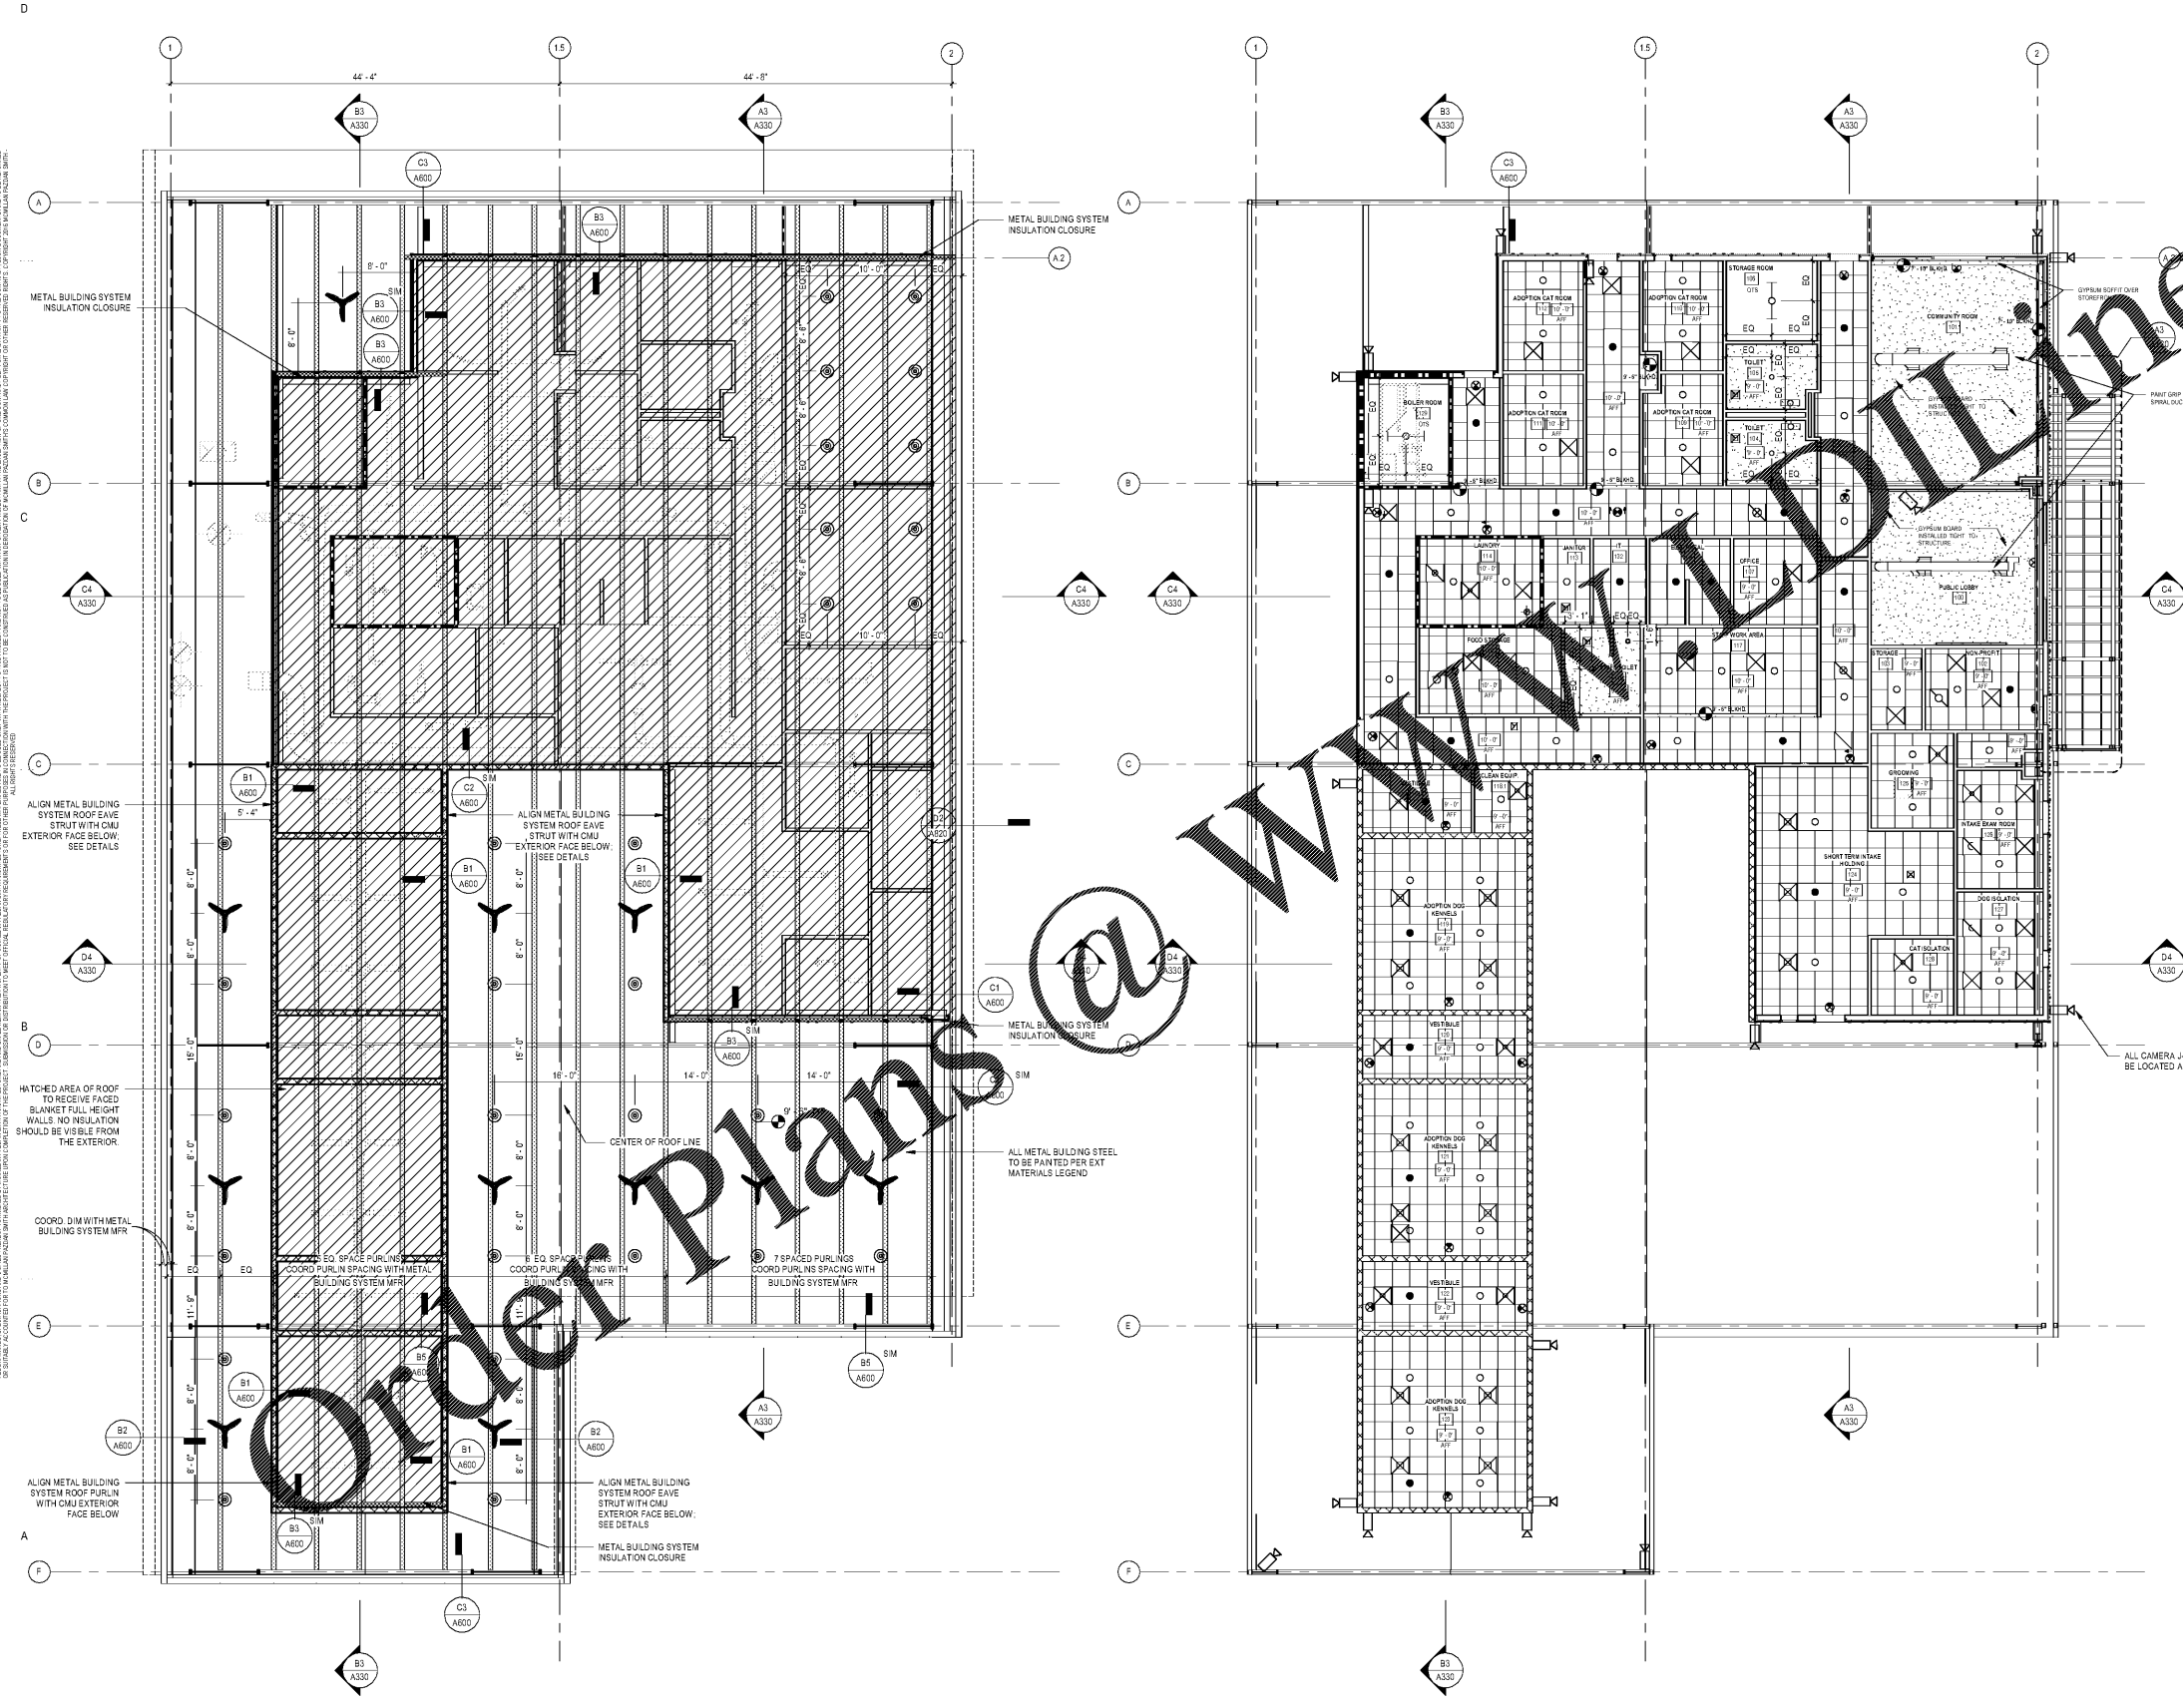

1 METAL BUILDING REFLECTED CEILING PLAN  
1/8" = 1'-0"

5 REFLECTED CEILING PLAN  
1/8" = 1'-0"