


1 MECHANICAL GROUND FLOOR PLAN - BUILDING G-B
1/4" = 1'-0"

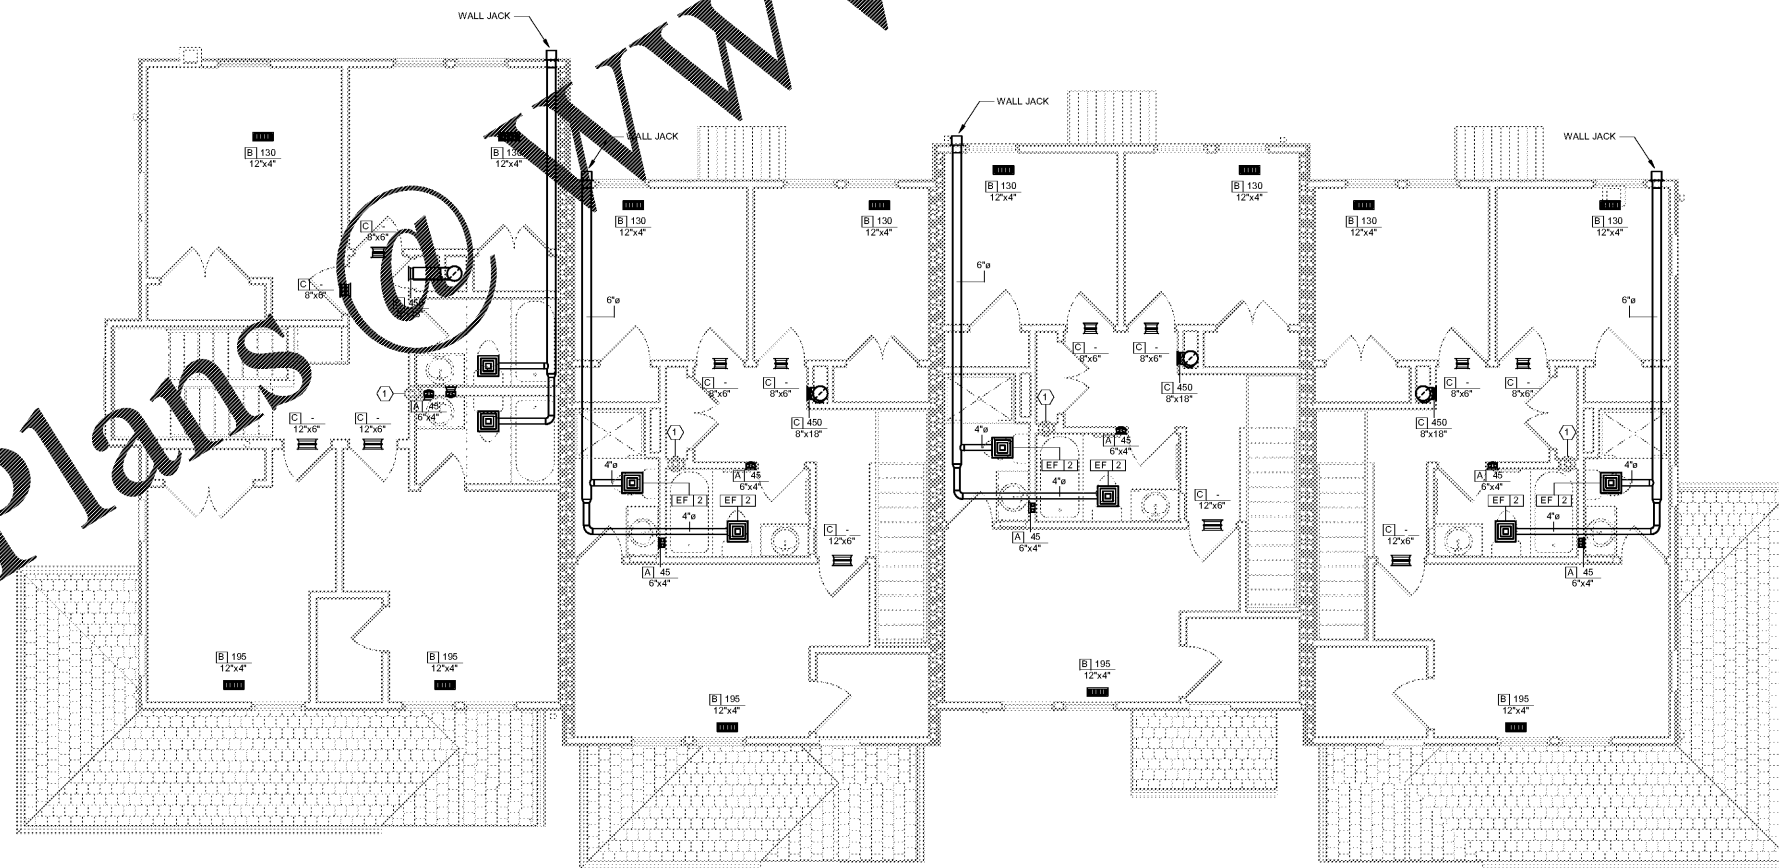

2 MECHANICAL SECOND FLOOR PLAN - BUILDING G-B
1/4" = 1'-0"

DRAWING NOTES

- A. PLEASE REFER TO SHEET M000 FOR PROJECT NOTES, LEGEND, AND SCHEDULES.
- B. PLEASE REFER TO SHEET M003 FOR TYPICAL AIR HANDLING UNIT SECTION VIEWS.
- C. PLEASE REFER TO SHEET M002 FOR MECHANICAL SECTIONS & DETAILS.
- D. FINAL LOCATION OF CONDENSING UNITS VARIES BY UNIT. SEE SITE CIVIL PLAN FOR EXACT LOCATIONS.
- E. WALL JACKS & VENT CAPS TO BE ROUTED TO AVOID TRIM AND BRACKETS AT EXTERIOR FACADE. SEE ARCH DWGS.
- F. ALL DUCT SIZES ARE INSIDE CLEAR DIMENSIONS.
- G. SUPPLY GRILLES IN SECOND FLOOR BATHROOMS TO BE MOUNTED AT 1'-0" A.F.F.
- H. NO MECHANICAL TO PENETRATE 2HR UNIT DEMISING WALLS AT TOWNHOMES.

KEY NOTES

- 1 LOCATION FOR RADON FAN IN ATTIC, IF ACTIVE SYSTEM IS REQUIRED.
- 2 ALL ROUND SUPPLY DUCT RUNS GOING TO DIFFUSERS CAN BE FLEX DUCT WITH RIGID FITTINGS (TYPICAL).
- 3 10\"/>
- 4 5\"/>



Architecture Planning Interiors Research
50 South B. B. King Boulevard
Memphis, Tennessee 38103
Telephone 901 521 1440
Fax 901 525 2760
E-mail info@lrk.com

Client:

**McCormack Baron
Salazar**

720 Olive St, Suite 2500

St. Louis, MO 63101

Issues and Revisions

Date	Issued / Revised
03/16/2020	50% CONSTRUCTION DOCUMENTS
05/18/2020	80% CONSTRUCTION DOCUMENTS
07/13/2020	PERMIT

BUILDING ADDRESSES

TYPE	ADDRESS
TYPE G-B	442, 444, 446, 448 BATHURST LANE 324, 326, 328, 330 SHIMMEL PLACE
TYPE H-A	373, 400 VANCE AVE 315, 364 FOOTE LANE 303 S DANNY THOMAS BLVD
TYPE L-C	365, 431 VANCE AVE 313 SHIMMEL PLACE
TYPE L-A	327 SHIMMEL PLACE 420, 503 FOOTE LANE 346 S DANNY THOMAS BLVD
TYPE M-A	402, 428 FOOTE LANE

©2020 LRK Inc.
Drawings, written material, and design concepts shall not be used or reproduced in whole or part in any form or format without prior written consent of LRK Inc. Do not scale drawings. Use given dimensions only. If not shown, verify correct dimensions with the Architect. Contractor shall check and verify all dimensions and conditions at job

Seal



LRK Project Number: 01.15100.02

Project Name:
**South City CNI
Phase 4**
Memphis TN

Drawing Name:
**MECHANICAL BUILDING
G-B FLOOR PLAN**

Drawn By: QWW

Checked By: RJH

GB-M201

Order Plans @

WWW.LDILine.com