


1 ELECTRICAL GROUND FLOOR PLAN - BUILDING G-B
1/4" = 1'-0"

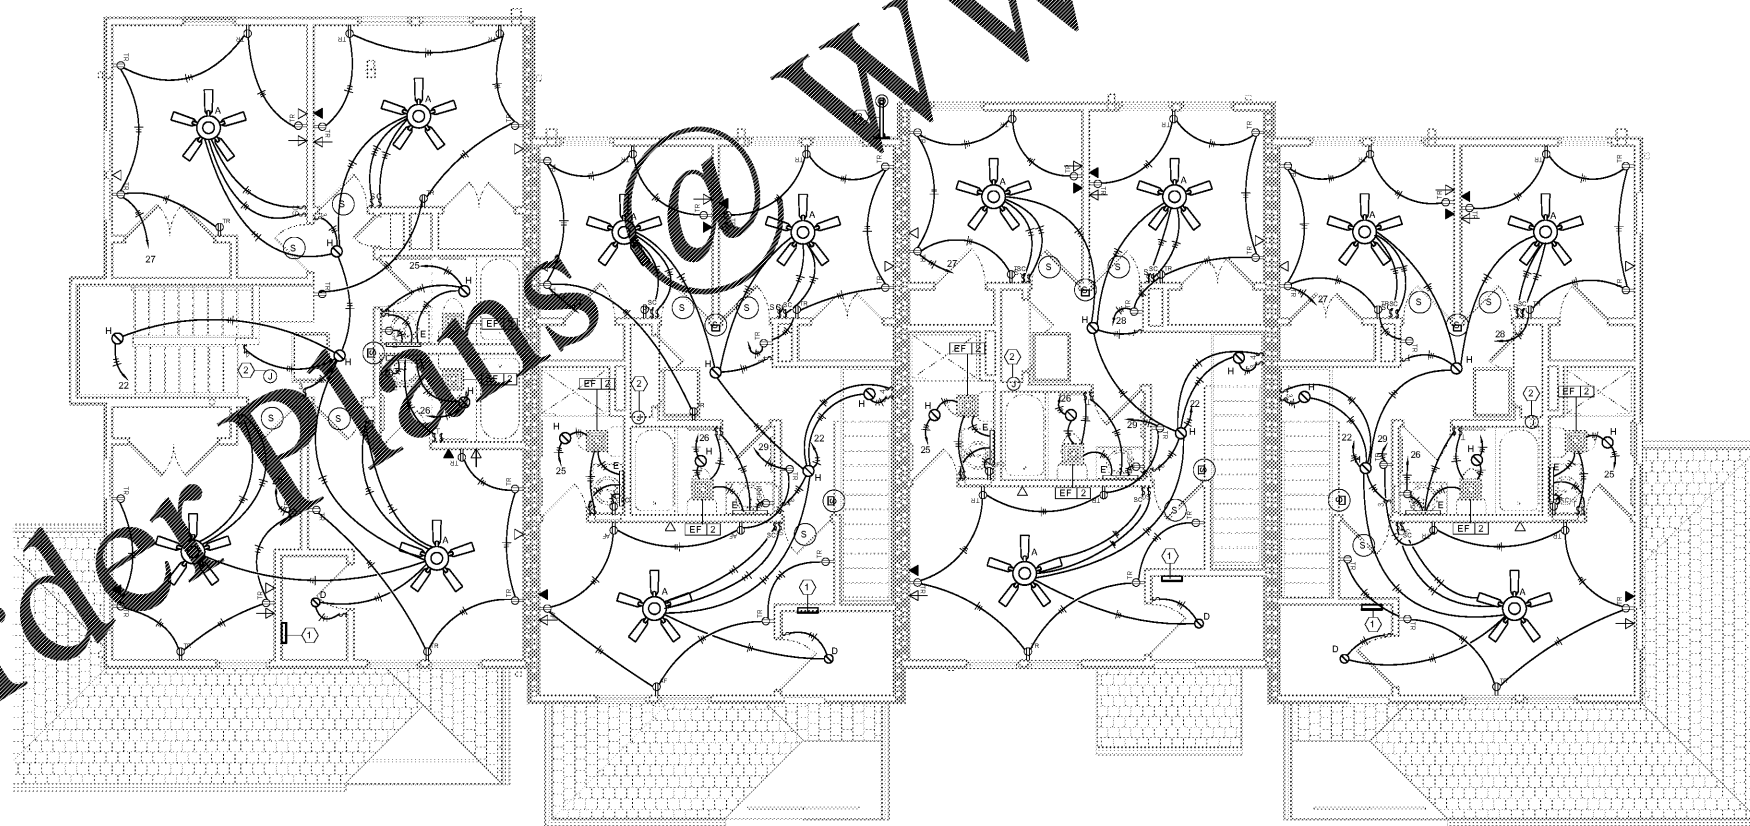


2 ELECTRICAL SECOND FLOOR PLAN - BUILDING G-B
1/4" = 1'-0"

DRAWING NOTES

- A. PLEASE REFER TO SHEET E000 FOR PROJECT NOTES, LEGEND, AND ABBREVIATIONS.
- B. FINAL LOCATION OF CONDENSING UNITS (DISCONNECTS) AND METER BANK VARIES BY UNIT.
- C. FRONT PORCH LIGHTS AND GFCI OUTLETS BY CONDENSING UNITS SHALL BE CONNECTED TO THE HOUSE PANEL. UP TO THREE HOUSE PANELS MAY BE TIED TO EACH HOUSE METER.
- D. PROVIDE WIRELESS DOORBELL FOR EACH UNIT.
- E. SEE SPECIFICATION SECTION 281300 FOR SECURITY SYSTEMS REQUIREMENTS.
- F. REFER TO SITE PLAN SHEET E002 FOR ELECTRICAL METER CENTER LOCATIONS.

KEY NOTES

- 1 PROVIDE 12"X12" RECESSED ENCLOSURE FOR CATV, DATA, TELEPHONE, SECURITY, ETC. TO DISTRIBUTE TO INDIVIDUAL ROOMS IN HOUSE. PROVIDE MEDIA BOX ENCLOSURE EQUIPPED WITH PRIMERX P3000. PROVIDE RECESSED IN BOTTOM OF BOX. RUN UTILITY CABLES TO ENCLOSURE TO OWNER'S BOX ON OUTSIDE WALL.
- 2 CIRCUIT FOR RADON FAN ATTIC. IF RADON SYSTEM IS PROVIDED, CIRCUIT SHALL BE TIED FROM HOUSE PANEL.
- 3 SIDE MOUNTED WEATHER STATION ON BUILDING. SEE SHEET E-300.
- 4 ATTIC ACCESS

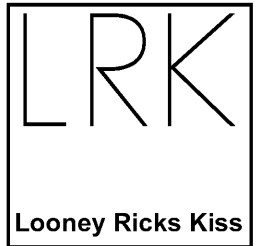

Architecture Planning Interiors Research
50 South B. B. King Boulevard
Memphis, Tennessee 38103
Telephone 901 521 1440
Fax 901 523 2760
E-mail info@lrk.com

Client:

**McCormack Baron
Salazar**

720 Olive St, Suite 2500

St. Louis, MO 63101

Issues and Revisions

Issue #	Date	Issued / Revised
1	03/16/2020	50% CONSTRUCTION DOCUMENTS
2	05/18/2020	80% CONSTRUCTION DOCUMENTS
3	07/13/2020	PERMIT

BUILDING ADDRESSES

- TYPE G-B
442, 444, 446, 448 BATHURST LANE
334, 236, 238, 330 SHIMMEL PLACE
- TYPE H-A
373, 400 VANCE AVE
315, 364 FOOTE LANE
363 S DANNY THOMAS BLVD
- TYPE L-C
365, 431 VANCE AVE
315 SHIMMEL PLACE
- TYPE L-A
327 SHIMMEL PLACE
420, 505 FOOTE LANE
340 S DANNY THOMAS BLVD
- TYPE M-A
402, 428 FOOTE LANE

©2020 LRK Inc.
Drawings, written material, and design concepts shall not be used or reproduced in whole or part in any form or format without prior written consent of LRK Inc. Do not scale drawings. Use given dimensions only. If not shown, verify correct dimensions with the Architect. Contractor shall check and verify all dimensions and conditions at job

Seal



LRK Project Number: 01.15100.02

Project Name:
**South City CNI
Phase 4**
Memphis TN

Drawing Name:
**ELECTRICAL BUILDING
G-B FLOOR PLANS**

Drawn By: PTH

Checked By: RJH

GB-E201