


Order Plans @ WWW.DLINE.COM

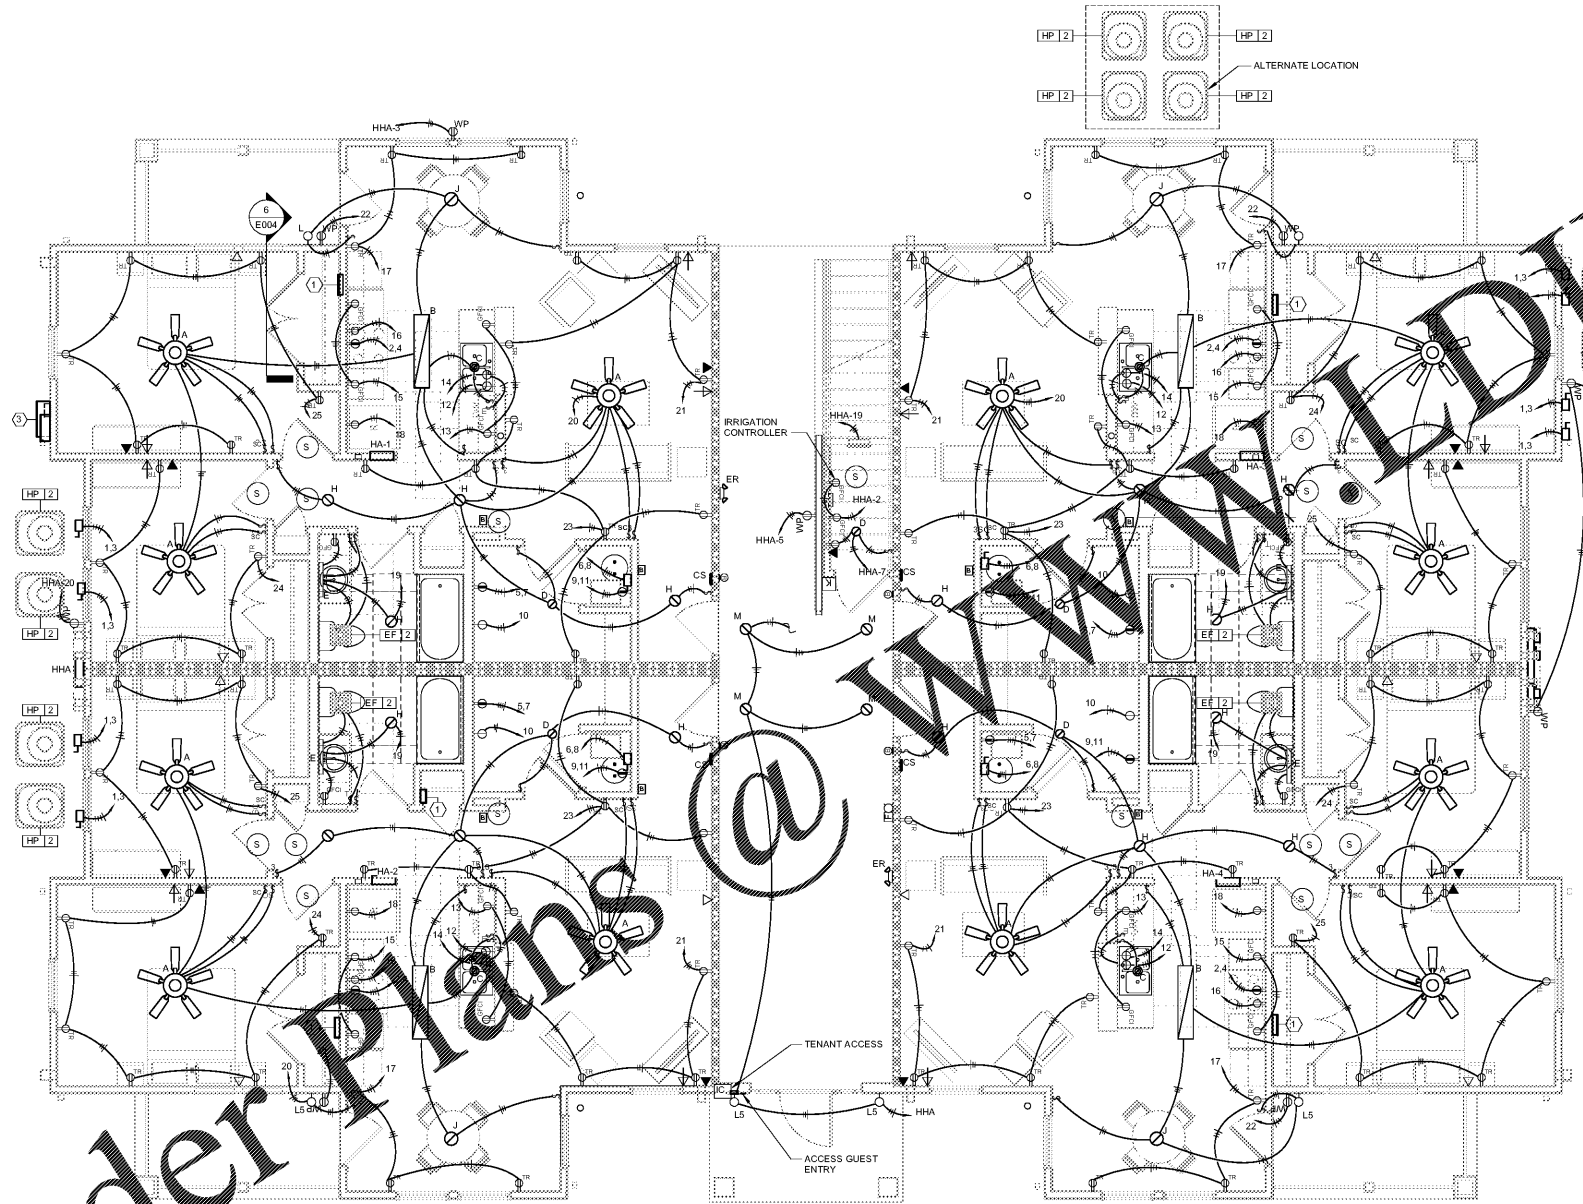

1 ELECTRICAL GROUND FLOOR PLAN - BUILDING H-A  
1/4" = 1'-0"

DRAWING NOTES

- A. PLEASE REFER TO SHEET E000 FOR PROJECT NOTES, LEGEND, AND ABBREVIATIONS.
- B. FINAL LOCATION OF CONDENSING UNITS (DISCONNECTS) AND METER BANK VARIES BY UNIT.
- C. FRONT PORCH LIGHTS AND GFCI OUTLETS BY CONDENSING UNITS SHALL BE CONNECTED TO THE HOUSE PANEL. UP TO THREE HOUSE PANELS MAY BE TIED TO EACH HOUSE METER.
- D. PROVIDE WIRELESS DOORBELL FOR EACH UNIT.
- E. SEE SPECIFICATION SECTION 281300 FOR SECURITY SYSTEMS REQUIREMENTS.
- F. REFER TO SITE PLAN SHEET E002 FOR ELECTRICAL METER CENTER LOCATIONS.

KEY NOTES

- 1 PROVIDE 12"x12" RECESSED ENCLOSURE FOR DATA, TELEPHONE, SECURITY, ETC. TO DISTRIBUTE TO INDIVIDUAL ROOMS IN UNITS. PROVIDE MEDIA BOX ENCLOSURE EQUAL TO PRIMEX P3000. PROVIDE RECESSED ENCLOSURE BOTTOM OF BOX. RUN UTILITY CABLES FROM ENCLOSURE TO OWNER'S BOX ON OUTSIDE WALL.
- 2 PROVIDE HEARING AND VISUAL FEATURES IN THIS UNIT.
- 3 COMMUNICATION AND UTILITY ENTRY POINT - REFER TO DETAIL 8 ON SHEET E004.



Architecture Planning Interiors Research  
50 South B.B. King Boulevard  
Memphis, Tennessee 38103  
Telephone 901 521 1440  
Fax 901 523 2760  
E-mail info@lrk.com

Client:  
**McCormack Baron Salazar**

720 Olive St, Suite 2500  
St. Louis, MO 63101

Issues and Revisions

Date	Issued / Revised
03/16/2020	50% CONSTRUCTION DOCUMENTS
05/18/2020	80% CONSTRUCTION DOCUMENTS
07/13/2020	PERMIT

BUILDING ADDRESSES

TYPE G.B.	ADDRESS
	442, 444, 446, 448 BATHURST LANE
	324, 226, 228, 330 SHWAEI PLACE
TYPE H.A. <th>ADDRESS</th>	ADDRESS
	373, 460 VANCE AVE
	315, 364 FOOTE LANE
	383 S DANNY THOMAS BLVD
TYPE L.C. <th>ADDRESS</th>	ADDRESS
	365, 431 VANCE AVE
	315 SHWAEI PLACE
TYPE L.A. <th>ADDRESS</th>	ADDRESS
	327 SHWAEI PLACE
	420, 353 FOOTE LANE
	346 S DANNY THOMAS BLVD
TYPE M.A. <th>ADDRESS</th>	ADDRESS
	402, 428 FOOTE LANE

©2020 LRK Inc.  
Drawings, written material, and design concepts shall not be used or reproduced in whole or part in any form or format without prior written consent of LRK Inc. Do not scale drawings. Use given dimensions only. If not shown, verify correct dimensions with the Architect. Contractor shall check and verify all dimensions and conditions at job

Seal



LRK Project Number: 01.15100.42

Project Name:  
**South City CNI Phase 4**  
Memphis TN

Drawing Name:  
**ELECTRICAL BUILDING H-A FLOOR PLANS**

Drawn By: PTH  
Checked By: RJH

**HA-E201**