



Architecture Planning Interiors Research
50 South B.B. King Boulevard
Memphis, Tennessee 38103
Telephone 901 521 1440
Fax 901 523 2760
E-mail info@lrk.com

Client:
McCormack Baron Salazar

720 Olive St, Suite 2500
St. Louis, MO 63101

Issues and Revisions

Date	Issued / Revised
03/16/2020	50% CONSTRUCTION DOCUMENTS
05/18/2020	80% CONSTRUCTION DOCUMENTS
07/13/2020	PERMIT

BUILDING ADDRESSES

TYPE G-B	442, 444, 446, 448 BATHURST LANE
TYPE H-A	324, 226, 228, 330 SHWAEI PLACE
TYPE H-A	373, 460 VANCE AVE
TYPE H-A	315, 364 FOOTE LANE
TYPE H-A	363 S DANNY THOMAS BLVD
TYPE L-C	365, 431 VANCE AVE
TYPE L-C	315 SHWAEI PLACE
TYPE L-A	327 SHWAEI PLACE
TYPE L-A	420, 353 FOOTE LANE
TYPE M-A	346 S DANNY THOMAS BLVD
TYPE M-A	402, 428 FOOTE LANE

©2020 LRK Inc.
Drawings, written material, and design concepts shall not be used or reproduced in whole or part in any form or format without prior written consent of LRK Inc. Do not scale drawings. Use given dimensions only. If not shown, verify correct dimensions with the Architect. Contractor shall check and verify all dimensions and conditions at job



LRK Project Number: 01.15100.42

Project Name:
South City CNI Phase 4
Memphis TN


Drawing Name:
ELECTRICAL BUILDING H-A FLOOR PLAN

Drawn By: PTH
Checked By: RJH

HA-E202

- DRAWING NOTES
- PLEASE REFER TO SHEET E000 FOR PROJECT NOTES, LEGEND, AND ABBREVIATIONS.
 - FINAL LOCATION OF CONDENSING UNITS (DISCONNECTS) AND METER BANK VARIES BY UNIT.
 - FRONT PORCH LIGHTS AND GFCI OUTLETS BY CONDENSING UNITS SHALL BE CONNECTED TO THE HOUSE PANEL. UP TO THREE HOUSE PANELS MAY BE TIED TO EACH HOUSE METER.
 - PROVIDE WIRELESS DOORBELL FOR EACH UNIT.
 - SEE SPECIFICATION SECTION 281300 FOR SECURITY SYSTEMS REQUIREMENTS.
 - REFER TO SITE PLAN SHEET E002 FOR ELECTRICAL METER CENTER LOCATIONS.

- KEY NOTES
- PROVIDE 12"X12" RECESSED ENCLOSURE FOR EACH TELEPHONE, SECURITY, ETC. TO DISTRIBUTE TO INDIVIDUAL ROOMS. PROVIDE METER BOX ENCLOSURE EQUAL TO PRIMEX P3000. PROVIDE RECEPTACLE IN FORM OF BOX. RUN UTILITY CABLES FROM ENCLOSURE TO OWNER'S BOX ON OUTSIDE WALL.
 - SIDE MOUNTED WEATHER STATION ON BUILDING DETAIL 3 ON SHEET IR-300.
 - CIRCUIT FOR RADON FAN IN UNIT. IF ACTIVE SYSTEM IS REQUIRED. CIRCUIT SHALL BE FED FROM HOUSE PANEL.

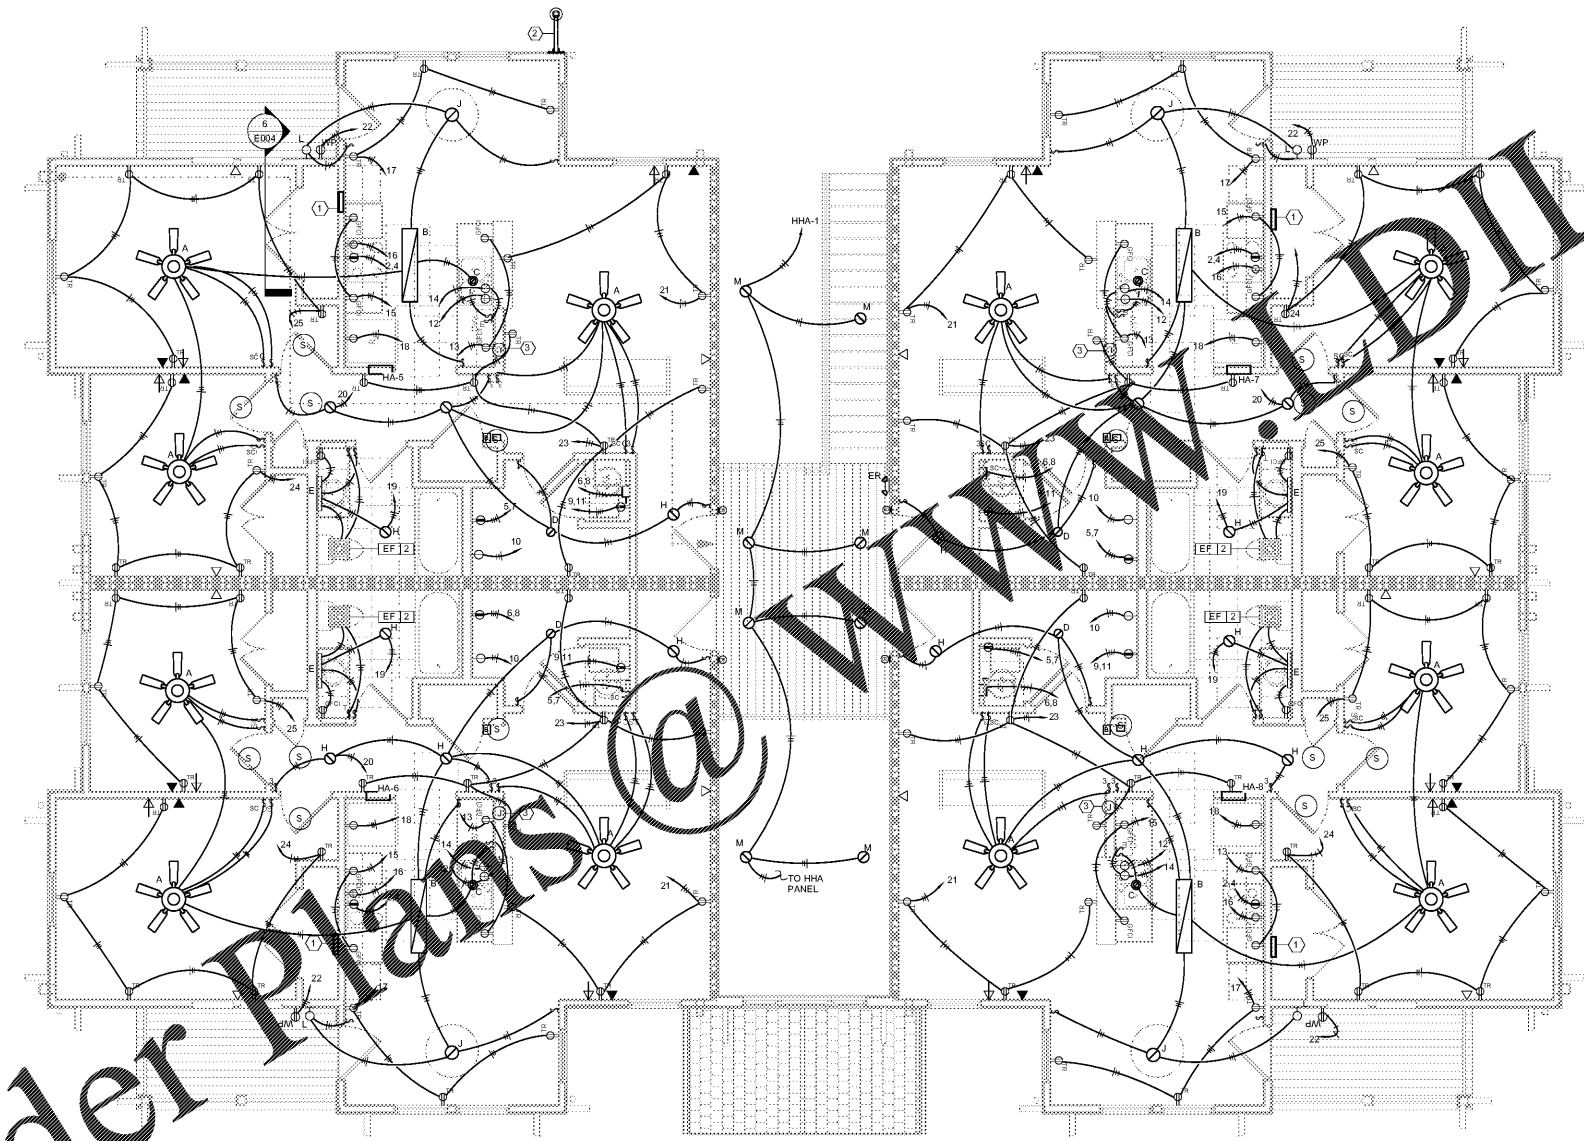

1 ELECTRICAL SECOND FLOOR PLAN - BUILDING H-A
1/4" = 1'-0"

Order Plans @ www.dline.com