


DRAWING NOTES

- A. PLEASE REFER TO SHEET M000 FOR PROJECT NOTES, LEGEND, AND SCHEDULES.
- B. PLEASE REFER TO SHEET M003 FOR TYPICAL AIR HANDLING UNIT SECTION VIEWS.
- C. PLEASE REFER TO SHEET M002 FOR MECHANICAL SECTIONS & DETAILS.
- D. FINAL LOCATION OF CONDENSING UNITS VARIES BY UNIT. SEE SITE CIVIL PLAN FOR EXACT LOCATIONS.
- E. WALL JACKS & VENT CAPS TO BE ROUTED TO AVOID TRIM AND BRACKETS AT EXTERIOR FACADE. SEE ARCH DWGS.
- F. ALL DUCT SIZES ARE INSIDE CLEAR DIMENSIONS.
- G. ALL CEILING MOUNTED DIFFUSERS AND GRILLES IN GARDEN APARTMENTS, EXCEPT ON TOP FLOOR, SHALL BE FURNISHED WITH RADIATION DAMPERS. FIRE DAMPER IS REQUIRED ON AHJ SUPPLY PLENUM.

KEY NOTES

- 1 COORDINATE WITH ELECTRICAL BREAKER PANEL IS IN THIS WALL.
- 2 FIRE-RATE THE PENETRATION. DUCT MUST BE MINIMUM 26 GAUGE METAL.

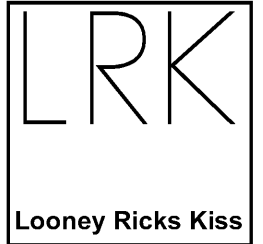

Architecture Planning Interiors Research
 50 South B.B. King Boulevard
 Memphis, Tennessee 38103
 Telephone 901 521 1440
 Fax 901 523 2760
 E-mail info@lrk.com

Client:
McCormack Baron Salazar

720 Olive St, Suite 2500
 St. Louis, MO 63101

Issues and Revisions

Date	Issued / Revised
03/16/2020	50% CONSTRUCTION DOCUMENTS
05/18/2020	80% CONSTRUCTION DOCUMENTS
07/13/2020	PERMIT

BUILDING ADDRESSES

TYPE G-B	442, 444, 446, 448 BATHURST LANE
TYPE H-A	324, 226, 230, 330 ISHMAEL PLACE
TYPE H-B	373, 460 VANCE AVE
TYPE H-C	315, 364 FOOT LANE
TYPE H-D	363 S DANNY THOMAS BLVD
TYPE L-C	365, 431 VANCE AVE
TYPE L-D	315 ISHMAEL PLACE
TYPE L-E	327 ISHMAEL PLACE
TYPE L-F	420, 353 FOOT LANE
TYPE M-A	346 S DANNY THOMAS BLVD
TYPE M-B	402, 428 FOOT LANE

©2020 LRK Inc.
 Drawings, written material, and design concepts shall not be used or reproduced in whole or part in any form or format without prior written consent of LRK Inc. Do not scale drawings. Use given dimensions only. If not shown, verify correct dimensions with the Architect. Contractor shall check and verify all dimensions and conditions at job.

Seal




LRK Project Number: 01.15100.02

Project Name:
South City CNI Phase 4
 Memphis TN

Drawing Name:
MECHANICAL BUILDING I-C FIRST FLOOR PLAN

Drawn By: QWW
 Checked By: RJH

IC-M201

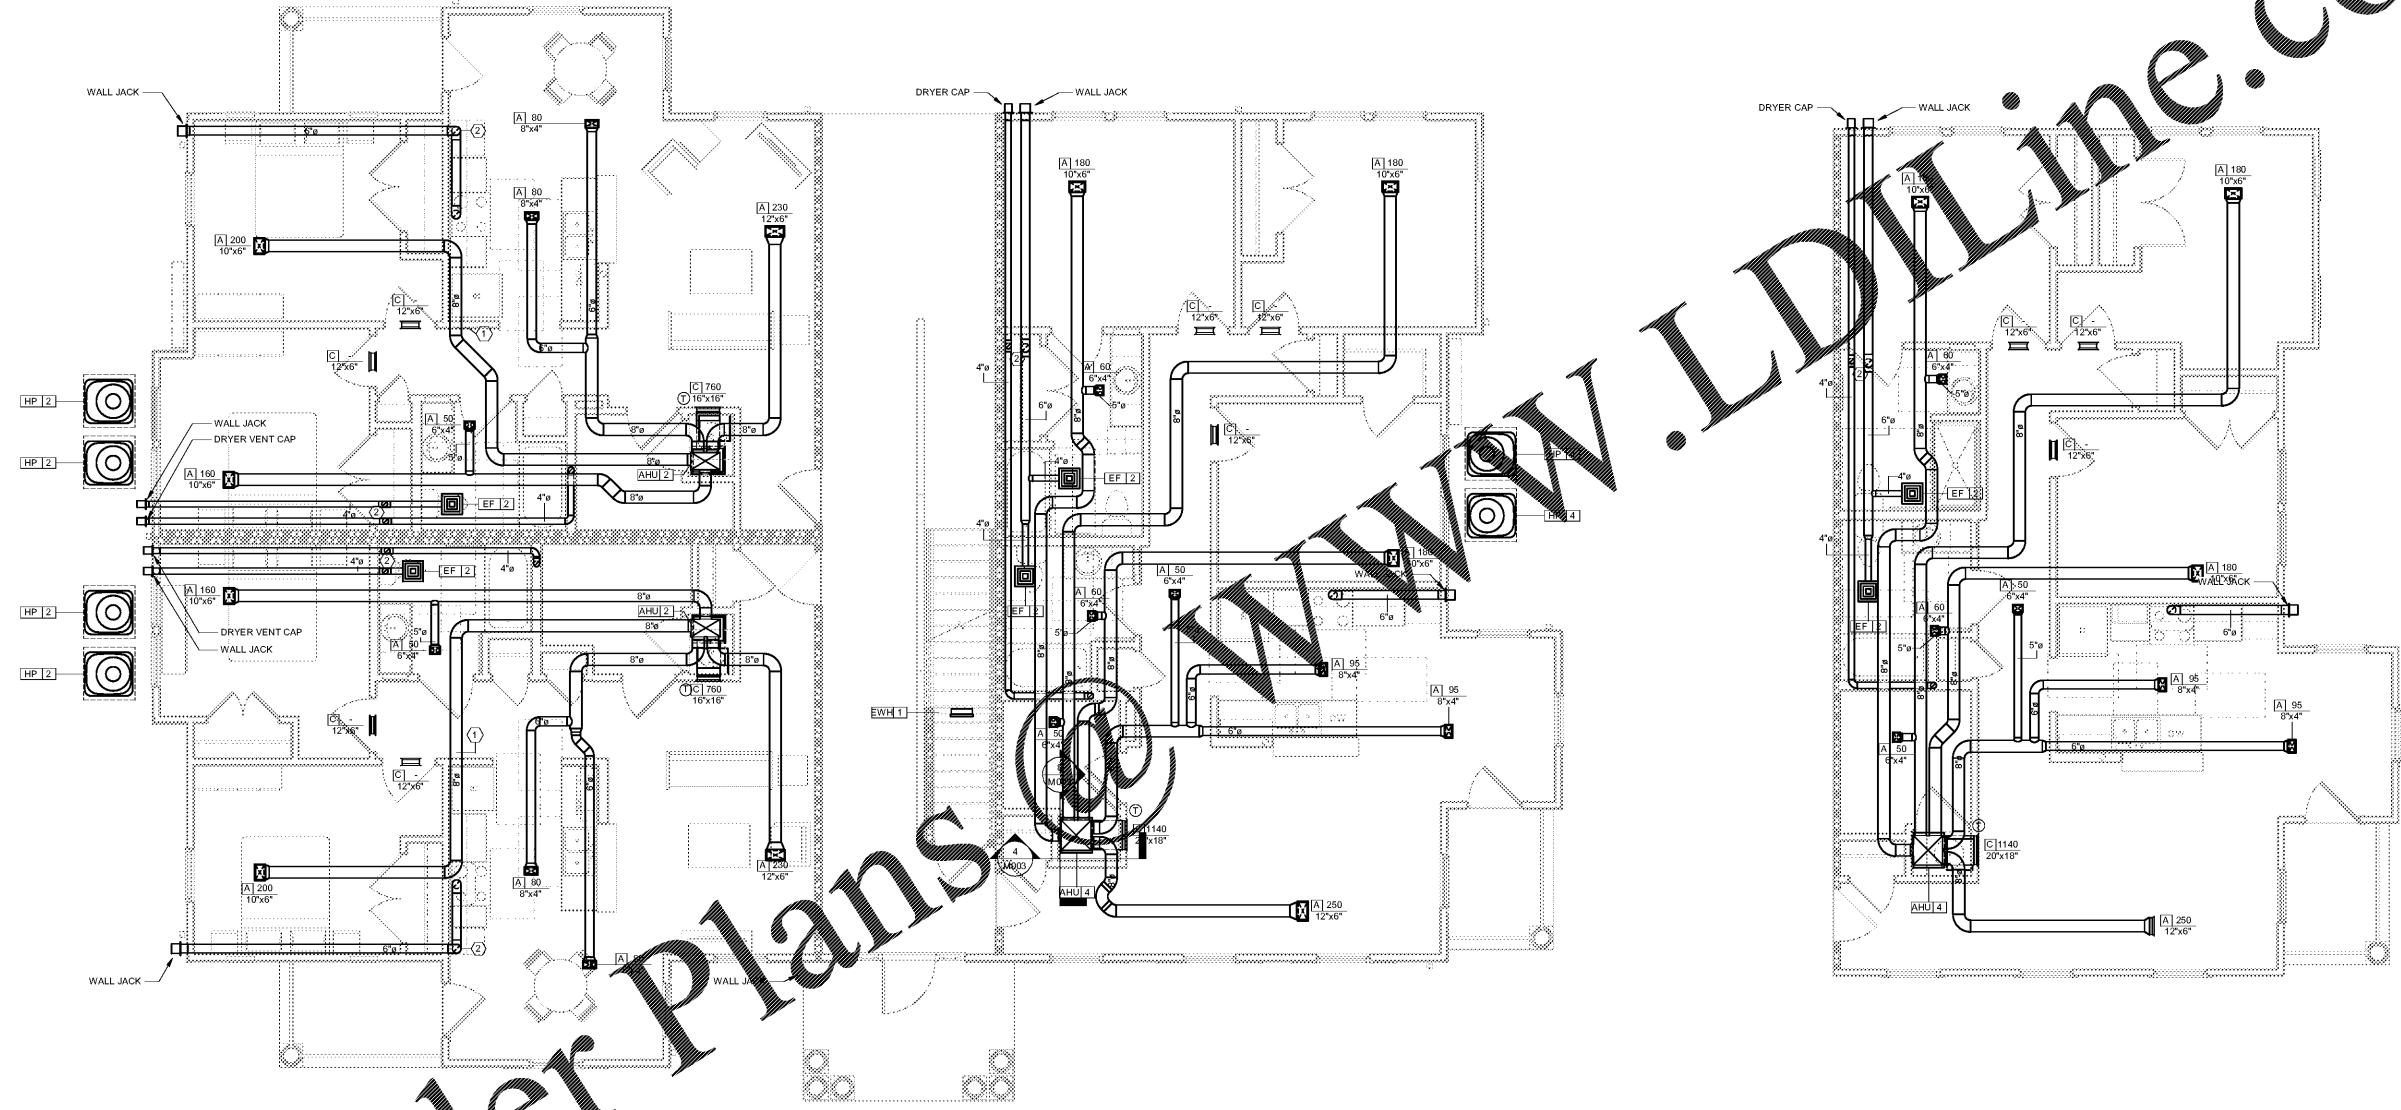

1 MECHANICAL GROUND FLOOR PLAN - BUILDING I-C
 1/4" = 1'-0"

2 MECHANICAL GROUND FLOOR PLAN - UNIT C1U - UFAS
 1/4" = 1'-0"

Order Plans @ www.LDOnline.com