


DRAWING NOTES

- A. PLEASE REFER TO SHEET M000 FOR PROJECT NOTES, LEGEND, AND SCHEDULES.
- B. PLEASE REFER TO SHEET M003 FOR TYPICAL AIR HANDLING UNIT SECTION VIEWS.
- C. PLEASE REFER TO SHEET M002 FOR MECHANICAL SECTIONS & DETAILS.
- D. FINAL LOCATION OF CONDENSING UNITS VARIES BY UNIT. SEE SITE CIVIL PLAN FOR EXACT LOCATIONS.
- E. WALL JACKS & VENT CAPS TO BE ROUTED TO AVOID TRIM AND BRACKETS AT EXTERIOR FACADE. SEE ARCH DWGS.
- F. ALL DUCT SIZES ARE INSIDE CLEAR DIMENSIONS.
- G. ALL CEILING MOUNTED DIFFUSERS AND GRILLES IN GARDEN APARTMENTS, EXCEPT ON TOP FLOOR, SHALL BE FURNISHED WITH RADIATION DAMPERS. FIRE DAMPER IS REQUIRED ON AHU SUPPLY PLENUM.

KEY NOTES

- 1 LOCATION FOR RADON FAN IN ATTIC, IF ACTIVE SYSTEM IS REQUIRED.
- 2 ALL ROUND SUPPLY DUCT RUNS GOING TO DIFFUSERS CAN BE FLEX DUCT WITH RIGID FITTINGS (TYPICAL).
- 3 COORDINATE WITH ELECTRICAL. BREAKER PANEL IS IN THIS WALL.

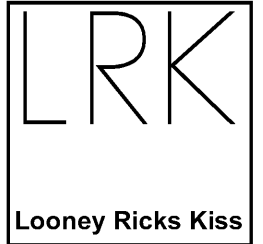

Architecture Planning Interiors Research  
 50 South B.B. King Boulevard  
 Memphis, Tennessee 38103  
 Telephone 901 521 1440  
 Fax 901 523 2760  
 E-mail info@lrk.com

Client:  
**McCormack Baron Salazar**

720 Olive St, Suite 2500  
 St. Louis, MO 63101

Issues and Revisions

Date	Issued / Revised
03/16/2020	50% CONSTRUCTION DOCUMENTS
05/18/2020	80% CONSTRUCTION DOCUMENTS
07/13/2020	PERMIT

BUILDING ADDRESSES

TYPE	ADDRESS
TYPE G.B.	442, 444, 446, 448 BATLIFF LANE
	324, 296, 230, 330 ISHMAEL PLACE
TYPE H.A.	373, 440 VANCE AVE
	315, 364 FOOLE LANE
	363 S DANNY THOMAS BLVD
TYPE L.C.	365, 431 VANCE AVE
	315 ISHMAEL PLACE
TYPE L.A.	327 ISHMAEL PLACE
	420, 353 FOOLE LANE
	345 S DANNY THOMAS BLVD
TYPE M.A.	402, 428 FOOLE LANE

©2020 LRK Inc.  
 Drawings, written material, and design concepts shall not be used or reproduced in whole or part in any form or format without prior written consent of LRK Inc. Do not scale drawings. Use given dimensions only. If not shown, verify correct dimensions with the Architect. Contractor shall check and verify all dimensions and conditions at job

Seal




LRK Project Number: 01.15100.02

Project Name:  
**South City CNI Phase 4**  
 Memphis TN

Drawing Name:  
**MECHANICAL BUILDING I-C SECOND FLOOR PLAN**

Drawn By: QWW  
 Checked By: RJH

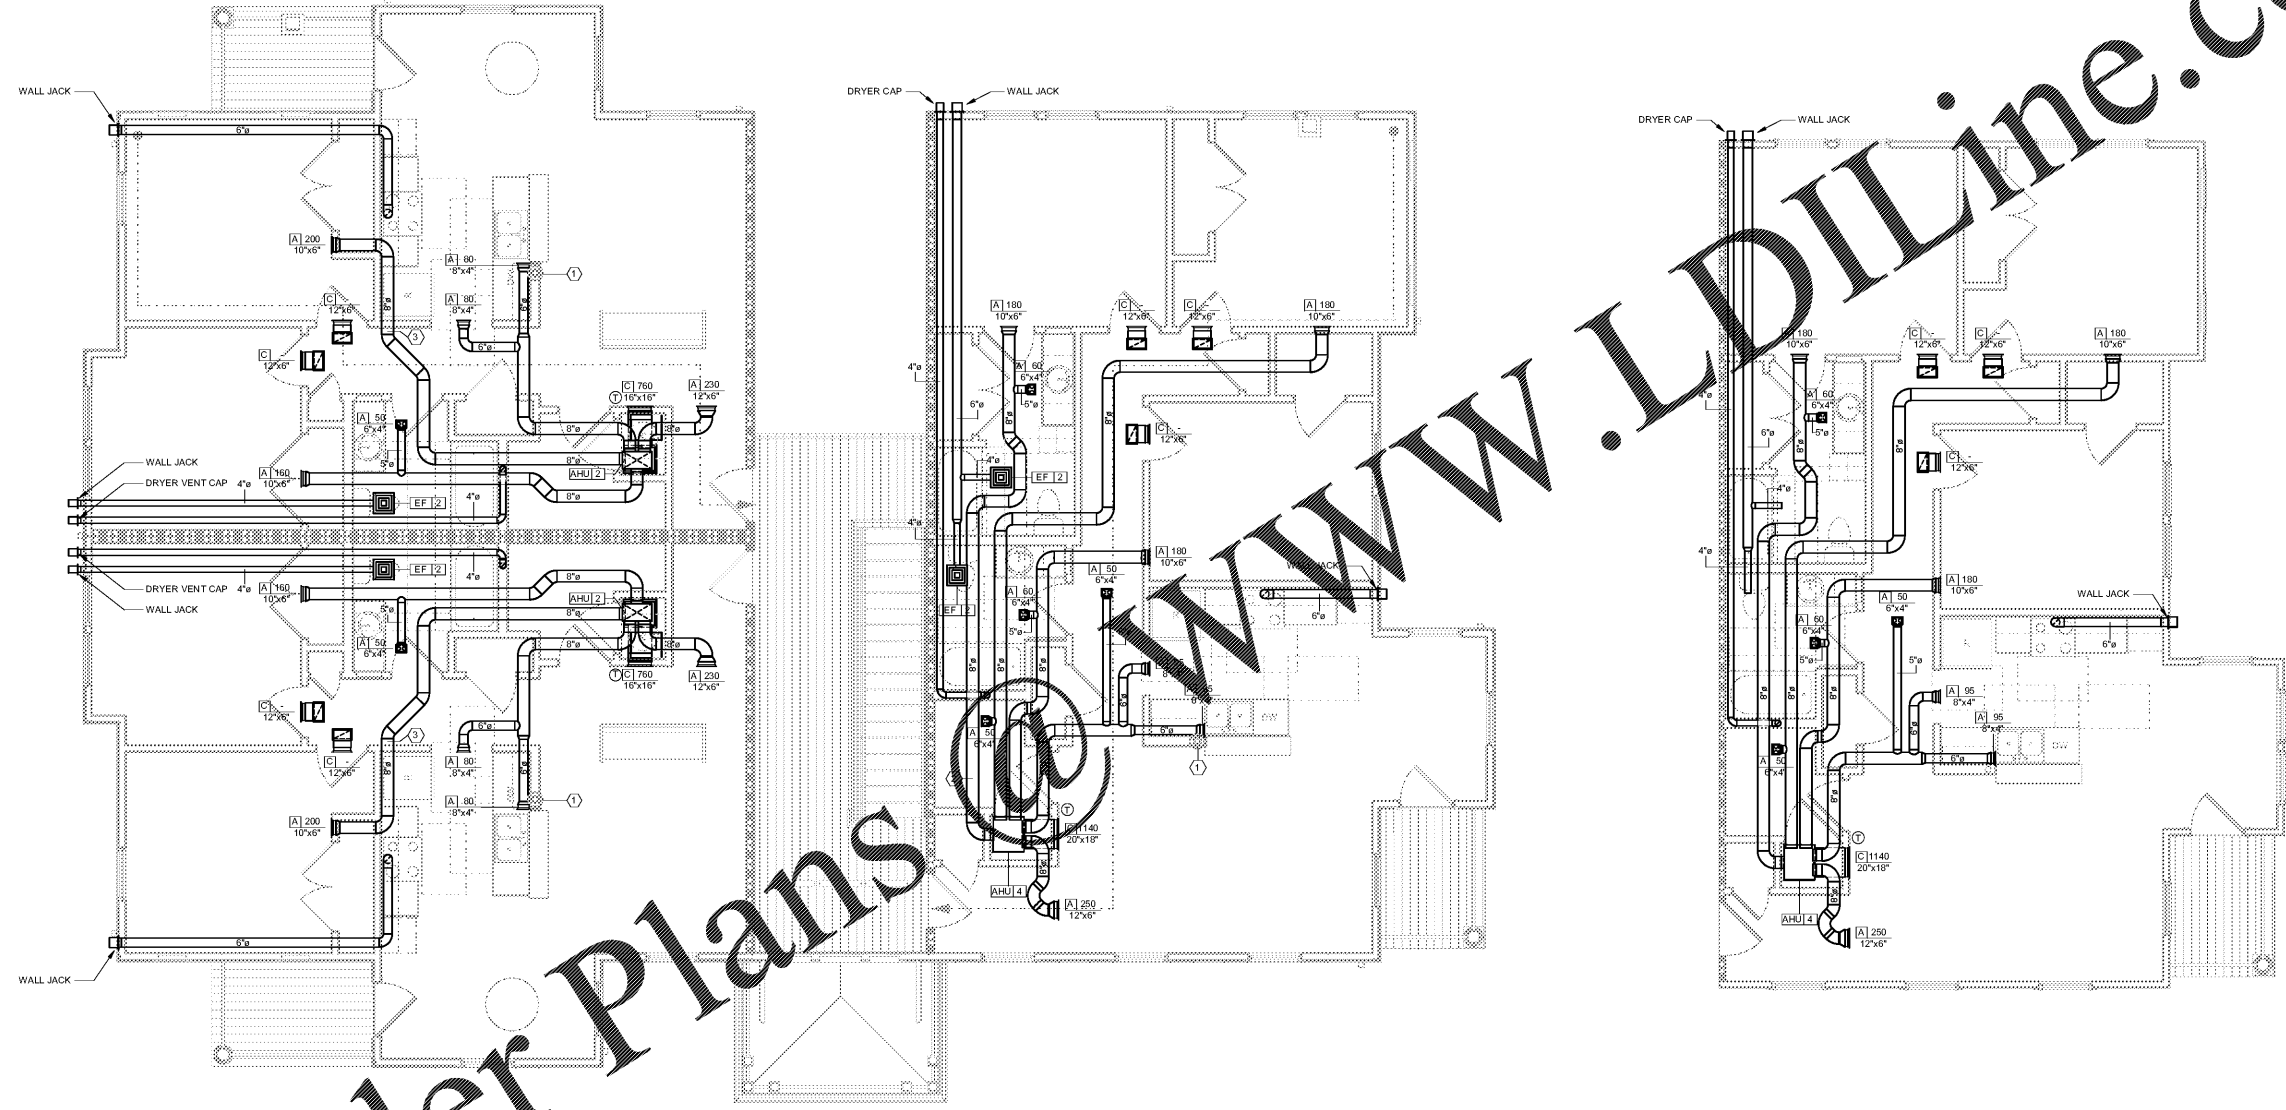

1 MECHANICAL SECOND FLOOR PLAN - BUILDING LC  
 1/4" = 1'-0"

2 MECHANICAL SECOND FLOOR PLAN - UNIT C1U - UFAS  
 1/4" = 1'-0"

Order Plans

WWW.LDILine.com

IC-M202