



Architecture Planning Interiors Research
50 South B.B. King Boulevard
Memphis, Tennessee 38103
Telephone 901 521 1440
Fax 901 525 2760
E-mail info@lrk.com

Client:
McCormack Baron Salazar

720 Olive St, Suite 2500
St. Louis, MO 63101

Issues and Revisions

Δ	Date	Issued / Revised
1	03/16/2020	50% CONSTRUCTION DOCUMENTS
2	05/18/2020	80% CONSTRUCTION DOCUMENTS
3	07/13/2020	PERMIT

BUILDING ADDRESSES

TYPE G-B	442, 444, 446, 448 BATHURST LANE 324, 226, 228, 230 SHIMMEL PLACE
TYPE H-A	373, 440 VANCE AVE 315, 364 FOOTE LANE 363 S DANNY THOMAS BLVD
TYPE I-C	365, 431 VANCE AVE 315 SHIMMEL PLACE
TYPE L-A	327 SHIMMEL PLACE 420, 355 FOOTE LANE 345 S DANNY THOMAS BLVD
TYPE M-A	402, 428 FOOTE LANE

©2020 LRK Inc.
Drawings, written material, and design concepts shall not be used or reproduced in whole or part in any form or format without prior written consent of LRK Inc. Do not scale drawings. Use given dimensions only. If not shown, verify correct dimensions with the Architect. Contractor shall check and verify all dimensions and conditions at job



LRK Project Number: 01.15100.42

Project Name:
South City CNI Phase 4
Memphis TN


Drawing Name:
ELECTRICAL BUILDING I-C SECOND FLOOR PLAN

Drawn By: Author
Checked By: Checker

IC-E202

- DRAWING NOTES**
- PLEASE REFER TO SHEET E000 FOR PROJECT NOTES, LEGEND, AND ABBREVIATIONS.
 - FINAL LOCATION OF CONDENSING UNITS (DISCONNECTS) AND METER BANK VARIES BY UNIT.
 - FRONT PORCH LIGHTS AND GFCI OUTLETS BY CONDENSING UNITS SHALL BE CONNECTED TO THE HOUSE PANEL. UP TO THREE HOUSE PANELS MAY BE TIED TO EACH HOUSE METER.
 - PROVIDE WIRELESS DOORBELL FOR EACH UNIT.
 - SEE SPECIFATION SECTION 281300 FOR SECURITY SYSTEMS REQUIREMENTS.
 - REFER TO SITE PLAN SHEET E002 FOR ELECTRICAL METER CENTER LOCATIONS.

- KEY NOTES**
- PROVIDE 1/2X1/2" RECESSED ENCLOSURE FOR TV, TELEPHONE, SECURITY, ETC. TO DISTRIBUTE TO INDIVIDUAL ROOMS. UNIT, FROM THE METER BOX. ENCLOSURE EQUAL TO PRIMEX P3000. PROVIDE RECEPTACLE IN BOTTOM OF BOX. RUN UTILITY CABLES FROM ENCLOSURE TO METER'S BOX. OUTSIDE WALL.
 - CIRCUIT FOR RADON FAN IN UNIT, IF ACTIVE. CIRCUIT IS REQUIRED. CIRCUIT SHALL BE FED FROM HOUSE PANEL.

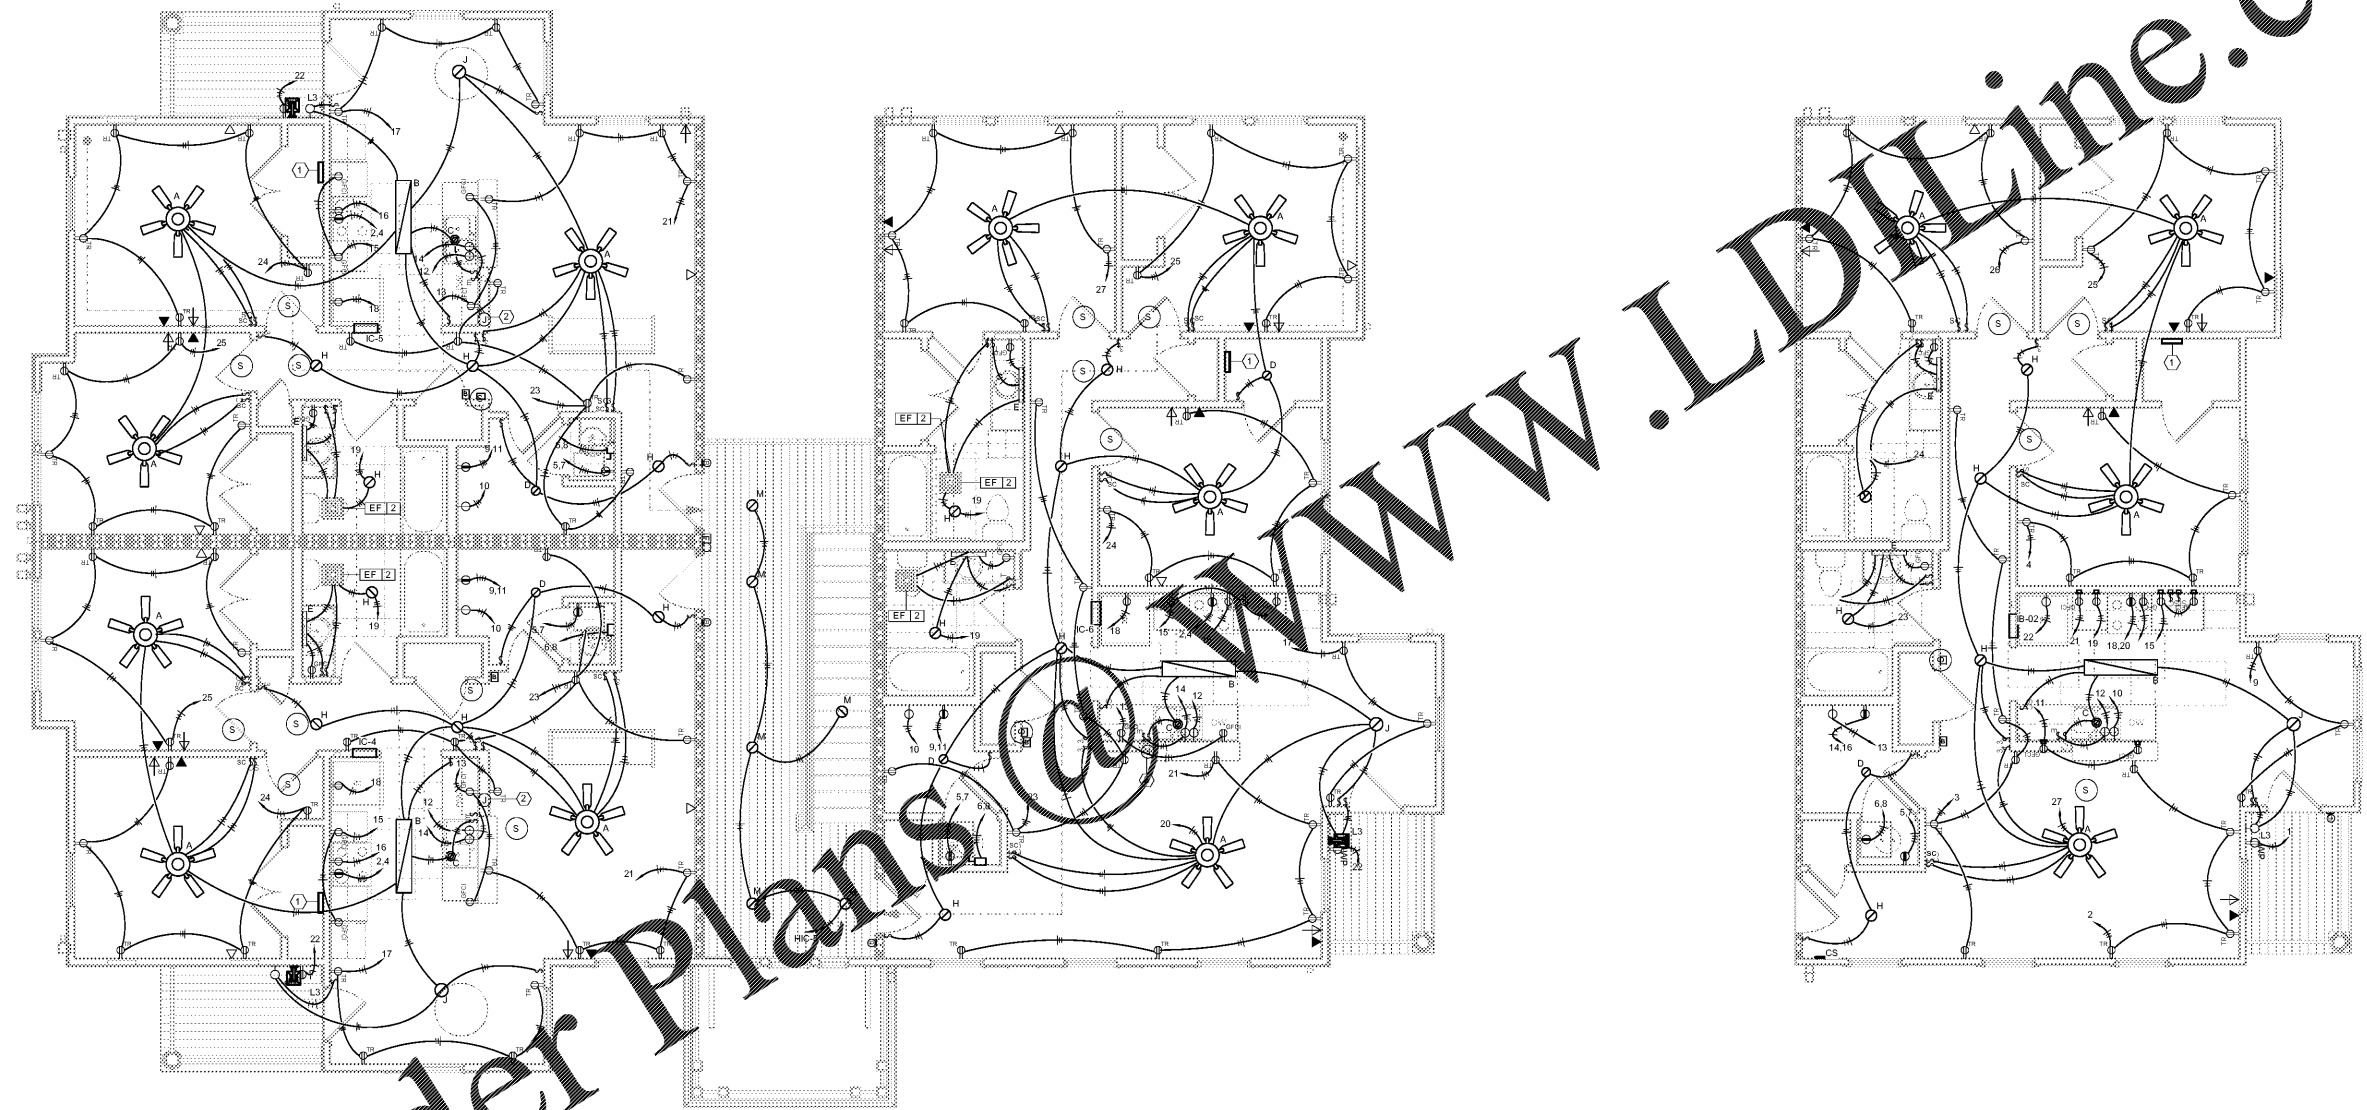

1 ELECTRICAL SECOND FLOOR PLAN - BUILDING I-C
1/4" = 1'-0"

2 ELECTRICAL SECOND FLOOR PLAN - UNIT C1U - UFAS
1/4" = 1'-0"

Order Plans @ www.LDOnline.com