


1 PLUMBING UNDERSLAB FLOOR PLAN - BUILDING I-C
1/4" = 1'-0"

GENERAL NOTES:

A. FLOOR DRAINS IN MECHANICAL CLOSETS SHALL NOT BE LOCATED UNDER WATER HEATER DRAIN PANS OR UNDER AIR HANDLING UNITS. FLOOR DRAINS SHALL BE LOCATED IN AN EASILY ACCESSIBLE LOCATION BETWEEN AIR HANDLER AND WATER HEATER. OVERFLOW DRAIN FROM WATER HEATER SHALL BE PIPED TO FLOOR DRAIN. WATER HEATER DRAIN PIPE AND CONDENSATE DRAIN PIPE SHALL BE SECURED TO FLOOR DRAIN STRAINER WITH 2\"/>

- KEY NOTES**
1. ROUTE RADON VENT PIPING INSIDE WALL. COORDINATE WITH HVAC CONTRACTOR.
 2. ROUTE SANITARY FROM FD TO HOUSE SIDE OF BATHTUB/SHOWER P-TRAP.
 3. FOR BUILDINGS G2 & H3 ONLY, PROVIDE A 2\"/>

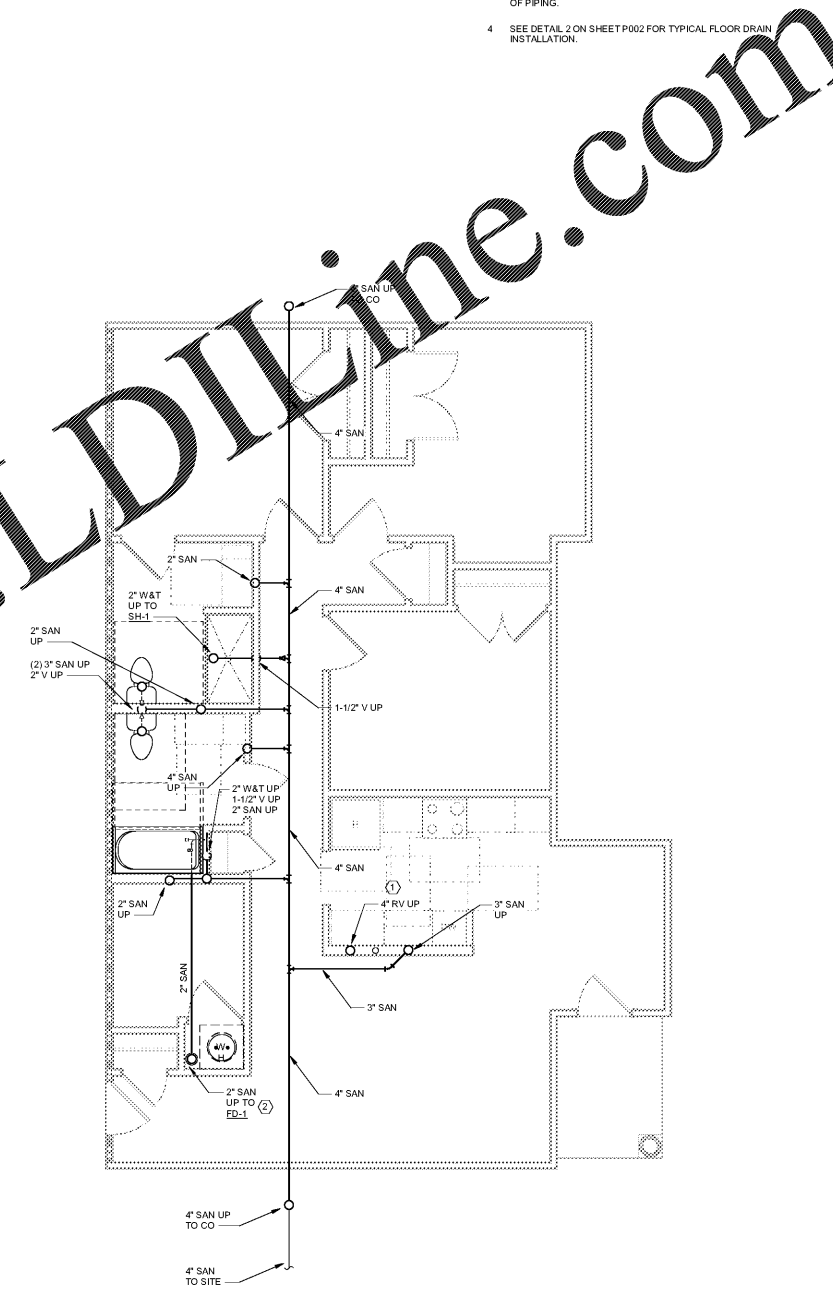

2 PLUMBING UNDERSLAB FLOOR PLAN - UNIT C1U - UFAS
1/4" = 1'-0"

Order Plans @

WWW.LDILINE.COM



Architecture Planning Interiors Research
50 South B.B. King Boulevard
Memphis, Tennessee 38103
Telephone 901 521 1440
Fax 901 525 2760
E-mail info@lrk.com

Client:
McCormack Baron Salazar

720 Olive St, Suite 2500
St. Louis, MO 63101

Issues and Revisions

Date	Issued / Revised
03/16/2020	50% CONSTRUCTION DOCUMENTS
05/18/2020	80% CONSTRUCTION DOCUMENTS
07/13/2020	PERMIT

BUILDING ADDRESSES

TYPE	ADDRESS
TYPE G.B.	442, 444, 446, 448 BATLUFF LANE
TYPE H.A.	324, 296, 298, 330 SHWAMEL PLACE
TYPE H.B.	373, 440 VANCE AVE
TYPE H.C.	316, 364 FOOTE LANE
TYPE H.D.	363 S DANNY THOMAS BLVD
TYPE L.C.	365, 431 VANCE AVE
TYPE L.H.	313 SHWAMEL PLACE
TYPE L.L.	327 SHWAMEL PLACE
TYPE L.M.	420, 50 FOOTE LANE
TYPE M.A.	346 S DANNY THOMAS BLVD
TYPE M.B.	402, 428 FOOTE LANE

©2020 LRK Inc.
Drawings, written material, and design concepts shall not be used or reproduced in whole or part in any form or format without prior written consent of LRK Inc. Do not scale drawings. Use given dimensions only. If not shown, verify correct dimensions with the Architect. Contractor shall check and verify all dimensions and conditions at job.



LRK Project Number: 01.15100.02

Project Name:
South City CNI Phase 4
Memphis TN

Drawing Name:
PLUMBING BUILDING I-C UNDERGROUND FLOOR PLAN

Drawn By: EDM
Checked By: JEW

IC-P201