

DRAWING NOTES

- A. PLEASE REFER TO SHEET M000 FOR PROJECT NOTES, LEGEND, AND SCHEDULES.
- B. PLEASE REFER TO SHEET M003 FOR TYPICAL AIR HANDLING UNIT SECTION VIEWS.
- C. PLEASE REFER TO SHEET M002 FOR MECHANICAL SECTIONS & DETAILS.
- D. FINAL LOCATION OF CONDENSING UNITS VARIES BY UNIT. SEE SITE CIVIL PLAN FOR EXACT LOCATIONS.
- E. WALL JACKS & VENT CAPS TO BE ROUTED TO AVOID TRIM AND BRACKETS AT EXTERIOR FACADE. SEE ARCH DWGS.
- F. ALL DUCT SIZES ARE INSIDE CLEAR DIMENSIONS.
- G. ALL CEILING MOUNTED DIFFUSERS AND GRILLES IN GARDEN APARTMENTS, EXCEPT ON TOP FLOOR, SHALL BE FURNISHED WITH RADIATION DAMPERS. FIRE DAMPER IS REQUIRED ON AHU SUPPLY PLENUM.

KEY NOTES

- 1. COORDINATE WITH ELECTRICAL BREAKER PANEL IS IN THIS WALL.
- 2. ALL ROUND SUPPLY DUCT RUNS GOING TO DIFFUSERS CAN BE FLEX DUCT WITH RIGID FITTINGS (TYPICAL).
- 3. SEE M004 FOR ENLARGED, SECTION, AND AXONOMETRIC VIEWS.
- 4. FIRE-RATE THE PENETRATION, DUCT MUST BE MINIMUM 26 GAUGE METAL.



Architecture Planning Interiors Research
 50 South B.B. King Boulevard
 Memphis, Tennessee 38103
 Telephone 901 521 1440
 Fax 901 525 2760
 E-mail info@lrk.com

Client:
McCormack Baron Salazar

720 Olive St, Suite 2500
 St. Louis, MO 63101

Issues and Revisions

Issue #	Date	Issued / Revised
1	03/16/2020	50% CONSTRUCTION DOCUMENTS
2	05/18/2020	80% CONSTRUCTION DOCUMENTS
3	07/13/2020	PERMIT

BUILDING ADDRESSES

TYPE G.B.	TYPE H.A.	TYPE L.C.	TYPE L.A.	TYPE M.A.
442, 444, 446, 448 BATHURST LANE	373, 440 WANCE AVE	365, 431 WANCE AVE	337 SHWAEI PLACE	402, 428 FOOTE LANE
324, 296, 298, 330 SHWAEI PLACE	316, 364 FOOTE LANE	313 SHWAEI PLACE	420, 355 FOOTE LANE	
	333 S DANNY THOMAS BLVD		346 S DANNY THOMAS BLVD	

©2020 LRK, Inc.
 Drawings, written material, and design concepts shall not be used or reproduced in whole or part in any form or format without prior written consent of LRK, Inc. Do not scale drawings. Use given dimensions only. If not shown, verify correct dimensions with the Architect. Contractor shall check and verify all dimensions and conditions at job site.




LRK Project Number 01.15100.02

Project Name:
South City CNI Phase 4
 Memphis TN

Drawing Name:
MECHANICAL BUILDING L-A FIRST FLOOR PLAN

Drawn By: QWW
 Checked By: RJH

LA-M201

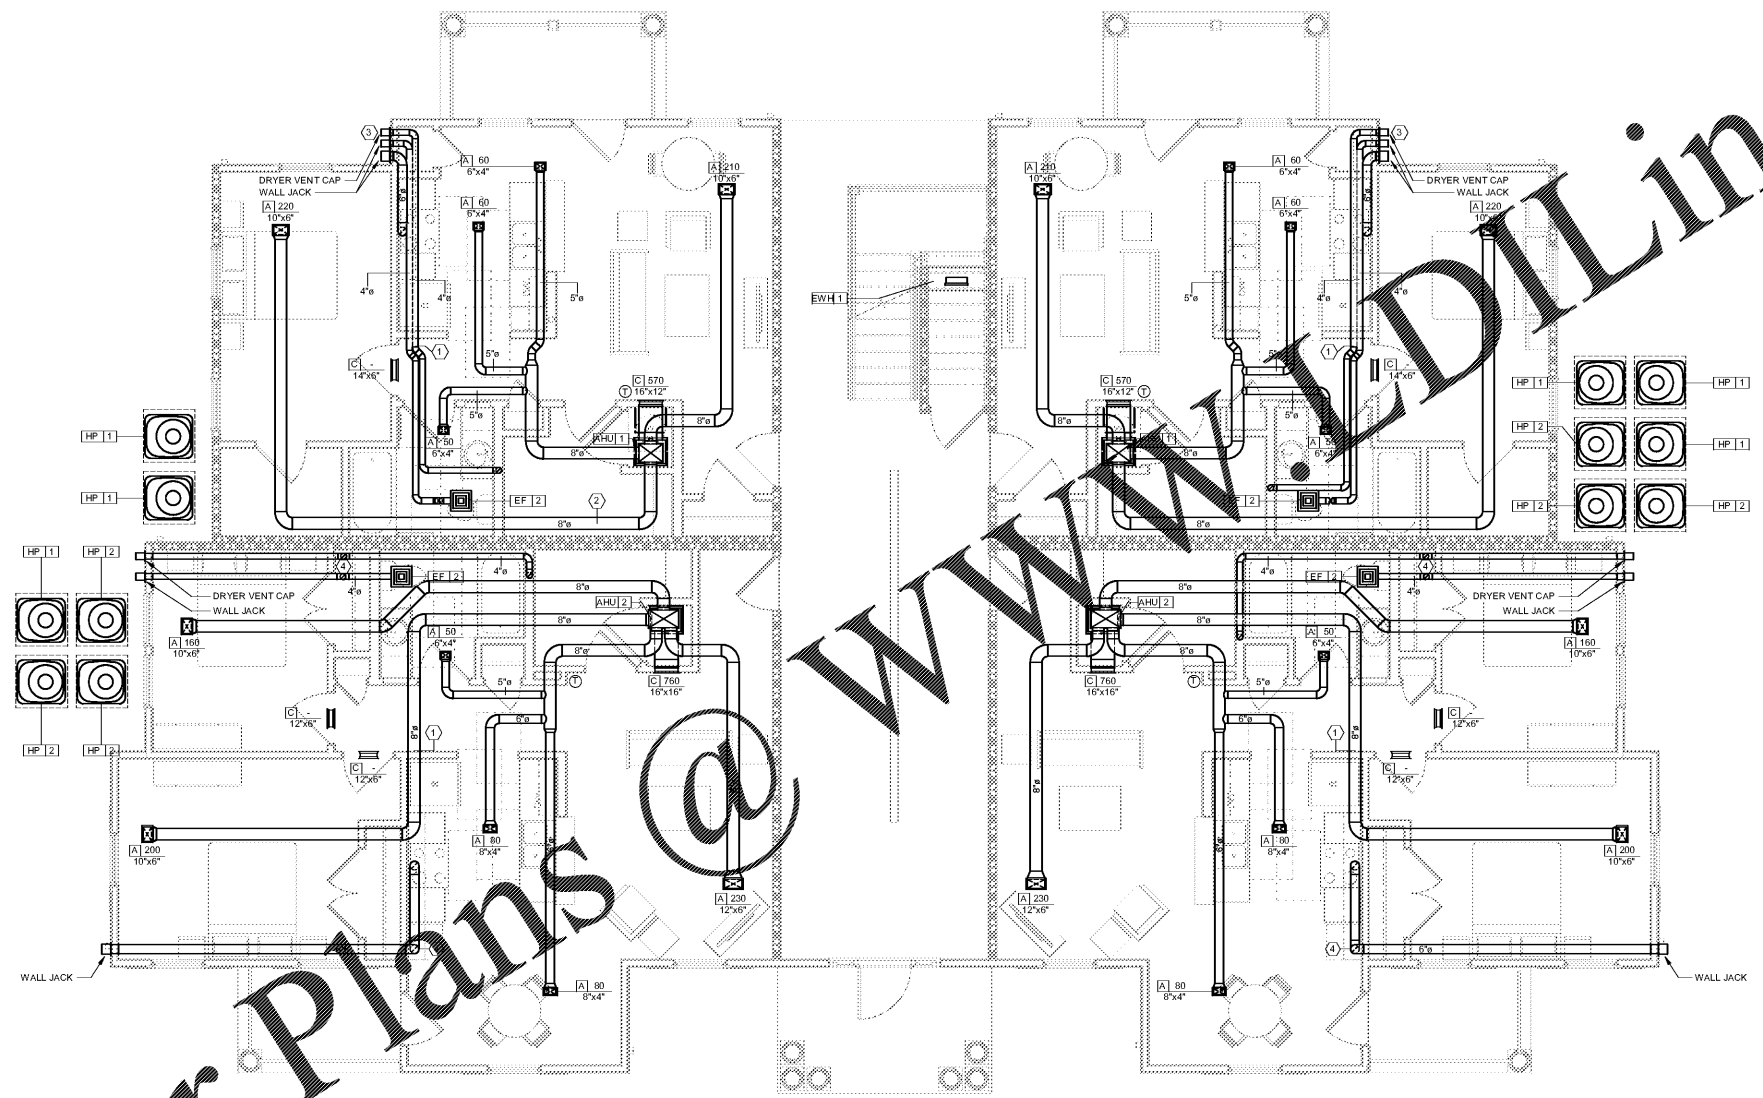

MECHANICAL GROUND FLOOR PLAN - BUILDING L-A
 1/4" = 1'-0"

Order Plans @

WWW.DILine.com