

GENERAL NOTES:

- A. FLOOR DRAINS IN MECHANICAL CLOSETS SHALL NOT BE LOCATED UNDER WATER HEATER DRAIN PANS OR UNDER AIR HANDLING UNITS. FLOOR DRAINS SHALL BE LOCATED IN AN EASILY ACCESSIBLE LOCATION BETWEEN AIR HANDLERS AND WATER HEATER. OVERFLOW DRAIN FROM WATER HEATER SHALL BE PIPED TO FLOOR DRAIN. WATER HEATER DRAIN PIPE AND CONDENSATE DRAIN PIPE SHALL BE SECURED TO FLOOR DRAIN STRAINER WITH ZP-TIES. CONDENSATE AND OVERFLOW PIPING SHALL BE RUN SO THAT IT IS OUT OF THE PATH OF TRAVEL.

KEY NOTES:

- 1 (2) 3/4" CW DP TO AP-1.
- 2 PROVIDE 3/4" CW & 3/4" HW TO DWH-1. SEE DETAIL 6 ON SHEET P003 FOR TYPICAL DOMESTIC WATER HEATER PIPING ARRANGEMENT.
- 3 ROUTE RADON VENT PIPING UP TO ATTIC SPACE AND CAP FOR FUTURE CONNECTION OF EXHAUST FAN AND EXTENSION UP TO ROOF.
- 4 ROUTE SANITARY FROM FD TO HOUSE SIDE OF BATHTUB/SHOWER P-TRAP.
- 5 1/2" CW DP, 1/2" HW DP, 3" SAN DN, 1-1/2" V UP AND 2" SAN UP.
- 6 ROUTE PIPING FOR OB-1 INSIDE PROVIDED WALL, TO THE LEFT SIDE OF LAUNDRY ROOM (TYP).



Looney Ricks Kiss

Architecture Planning Interiors Research
 50 South B.B. King Boulevard
 Memphis, Tennessee 38103
 Telephone 901 521 1440
 Fax 901 525 2760
 E-mail info@lrk.com

Client:

McCormack Baron Salazar

720 Olive St, Suite 2500

St. Louis, MO 63101

Issues and Revisions

Date	Issued / Revised
03/16/2020	50% CONSTRUCTION DOCUMENTS
05/18/2020	80% CONSTRUCTION DOCUMENTS
07/13/2020	PERMIT

BUILDING ADDRESSES

TYPE	ADDRESS
TYPE G-B	442, 444, 446, 448 BATLUFF LANE 324, 226, 228, 230 SHWAMEL PLACE
TYPE H-A	373, 460 VANCE AVE 315, 364 FOOTE LANE 383 S DANNY THOMAS BLVD
TYPE L-C	365, 431 VANCE AVE 315 SHWAMEL PLACE
TYPE L-A	327 SHWAMEL PLACE 420, 503 FOOTE LANE 383 S DANNY THOMAS BLVD
TYPE M-A	402, 426 FOOTE LANE

©2020 LRK Inc.
 Drawings, written material, and design concepts shall not be used or reproduced in whole or part in any form or format without prior written consent of LRK Inc. Do not scale drawings. Use given dimensions only. If not shown, verify correct dimensions with the Architect. Contractor shall check and verify all dimensions and conditions at job

Seal



LRK Project Number: 01.15100.02

Project Name:

South City CNI Phase 4

Memphis TN


Drawing Name:

PLUMBING BUILDING L-A SECOND FLOOR

Drawn By: EDM

Checked By: JEK

LA-P203

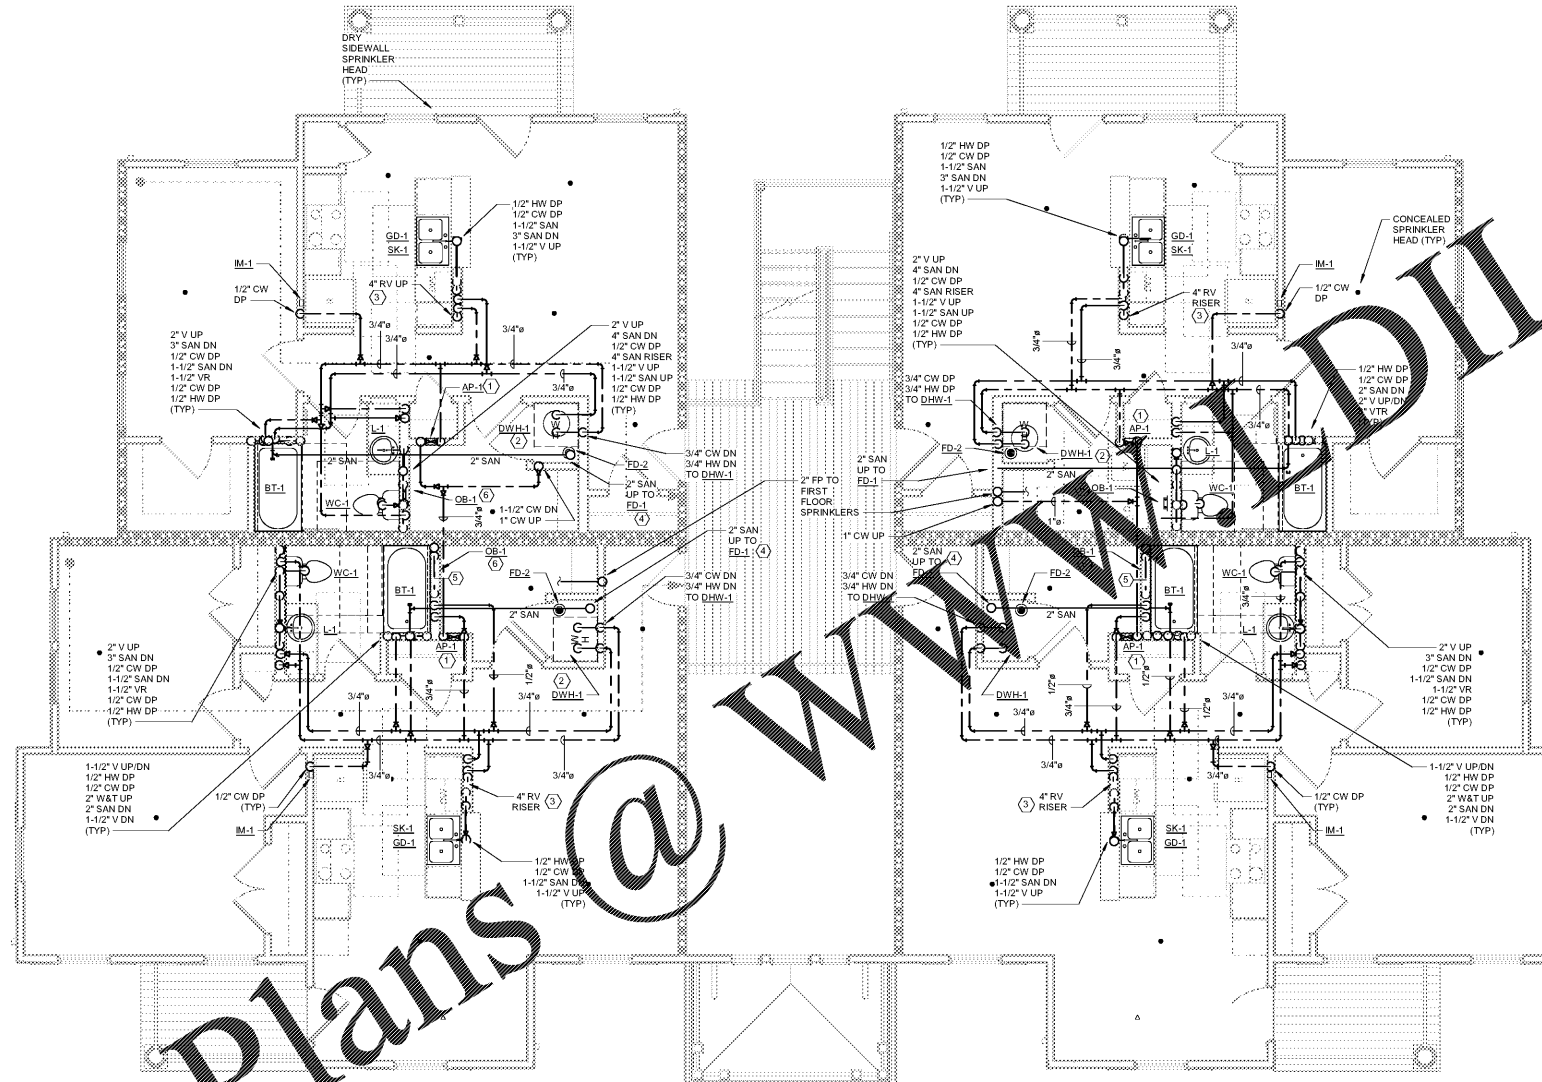

1 PLUMBING SECOND FLOOR PLAN BUILDING L-A
 1/4" = 1'-0"

Order Plans @ www.dlLine.com

WWW.DLLine.com