

- DRAWING NOTES**
- A. PLEASE REFER TO SHEET E000 FOR PROJECT NOTES, LEGEND, AND ABBREVIATIONS.
 - B. FINAL LOCATION OF CONDENSING UNITS (DISCONNECTS) AND METER BANK VARIES BY UNIT.
 - C. FRONT PORCH LIGHTS AND GFCI OUTLETS BY CONDENSING UNITS SHALL BE CONNECTED TO THE HOUSE PANEL. UP TO THREE HOUSE PANELS MAY BE TIED TO EACH HOUSE METER.
 - D. PROVIDE WIRELESS DOORBELL FOR EACH UNIT.
 - E. SEE SPECIFICATION SECTION 281300 FOR SECURITY SYSTEMS REQUIREMENTS.
 - F. REFER TO SITE PLAN SHEET E002 FOR ELECTRICAL METER CENTER LOCATIONS.

- KEY NOTES**
- 1. PROVIDE 12X12" RECESSED ENCLOSURE FOR CANNOTATION TELEPHONE, SECURITY, ETC. TO DISTRIBUTE TO INDIVIDUAL ROOMS IN UNIT. PROVIDE METER BOX ENCLOSURE EQUAL TO PRIMEX P3000. PROVIDE RECEPTACLE IN BOTTOM OF BOX. RUN UTILITY CABLES FROM ENCLOSURE TO OWNER'S EXTERIOR OUTSIDE WALL.



Architecture Planning Interiors Research
 50 South B.B. King Boulevard
 Memphis, Tennessee 38103
 Telephone 901 521 1440
 Fax 901 523 2760
 E-mail info@lrk.com

Client:
McCormack Baron Salazar

720 Olive St, Suite 2500
 St. Louis, MO 63101

Issues and Revisions

Δ	Date	Issued / Revised
1	03/16/2020	50% CONSTRUCTION DOCUMENTS
2	05/18/2020	80% CONSTRUCTION DOCUMENTS
3	07/13/2020	PERMIT

BUILDING ADDRESSES

TYPE	ADDRESS
TYPE G.B.	442, 444, 446, 448 BATHURST LANE
	324, 296, 236, 330 SHIMMEL PLACE
TYPE H.A.	374, 440 VANCE AVE
	316, 364 FOOTE LANE
TYPE L.C.	363 S DANNY THOMAS BLVD
TYPE L.C.	365, 431 VANCE AVE
	313 SHIMMEL PLACE
TYPE L.A.	327 SHIMMEL PLACE
	420, 353 FOOTE LANE
	346 S DANNY THOMAS BLVD
TYPE M.A.	402, 428 FOOTE LANE

©2020 LRK Inc.
 Drawings, written material, and design concepts shall not be used or reproduced in whole or part in any form or format without prior written consent of LRK Inc. Do not scale drawings. Use given dimensions only. If not shown, verify correct dimensions with the Architect. Contractor shall check and verify all dimensions and conditions at job




LRK Project Number: 01.15100.02

Project Name:
South City CNI Phase 4
 Memphis TN

Drawing Name:
ELECTRICAL BUILDING M-A-2 GROUND FLOOR PLAN

Drawn By: PTH
 Checked By: RJH

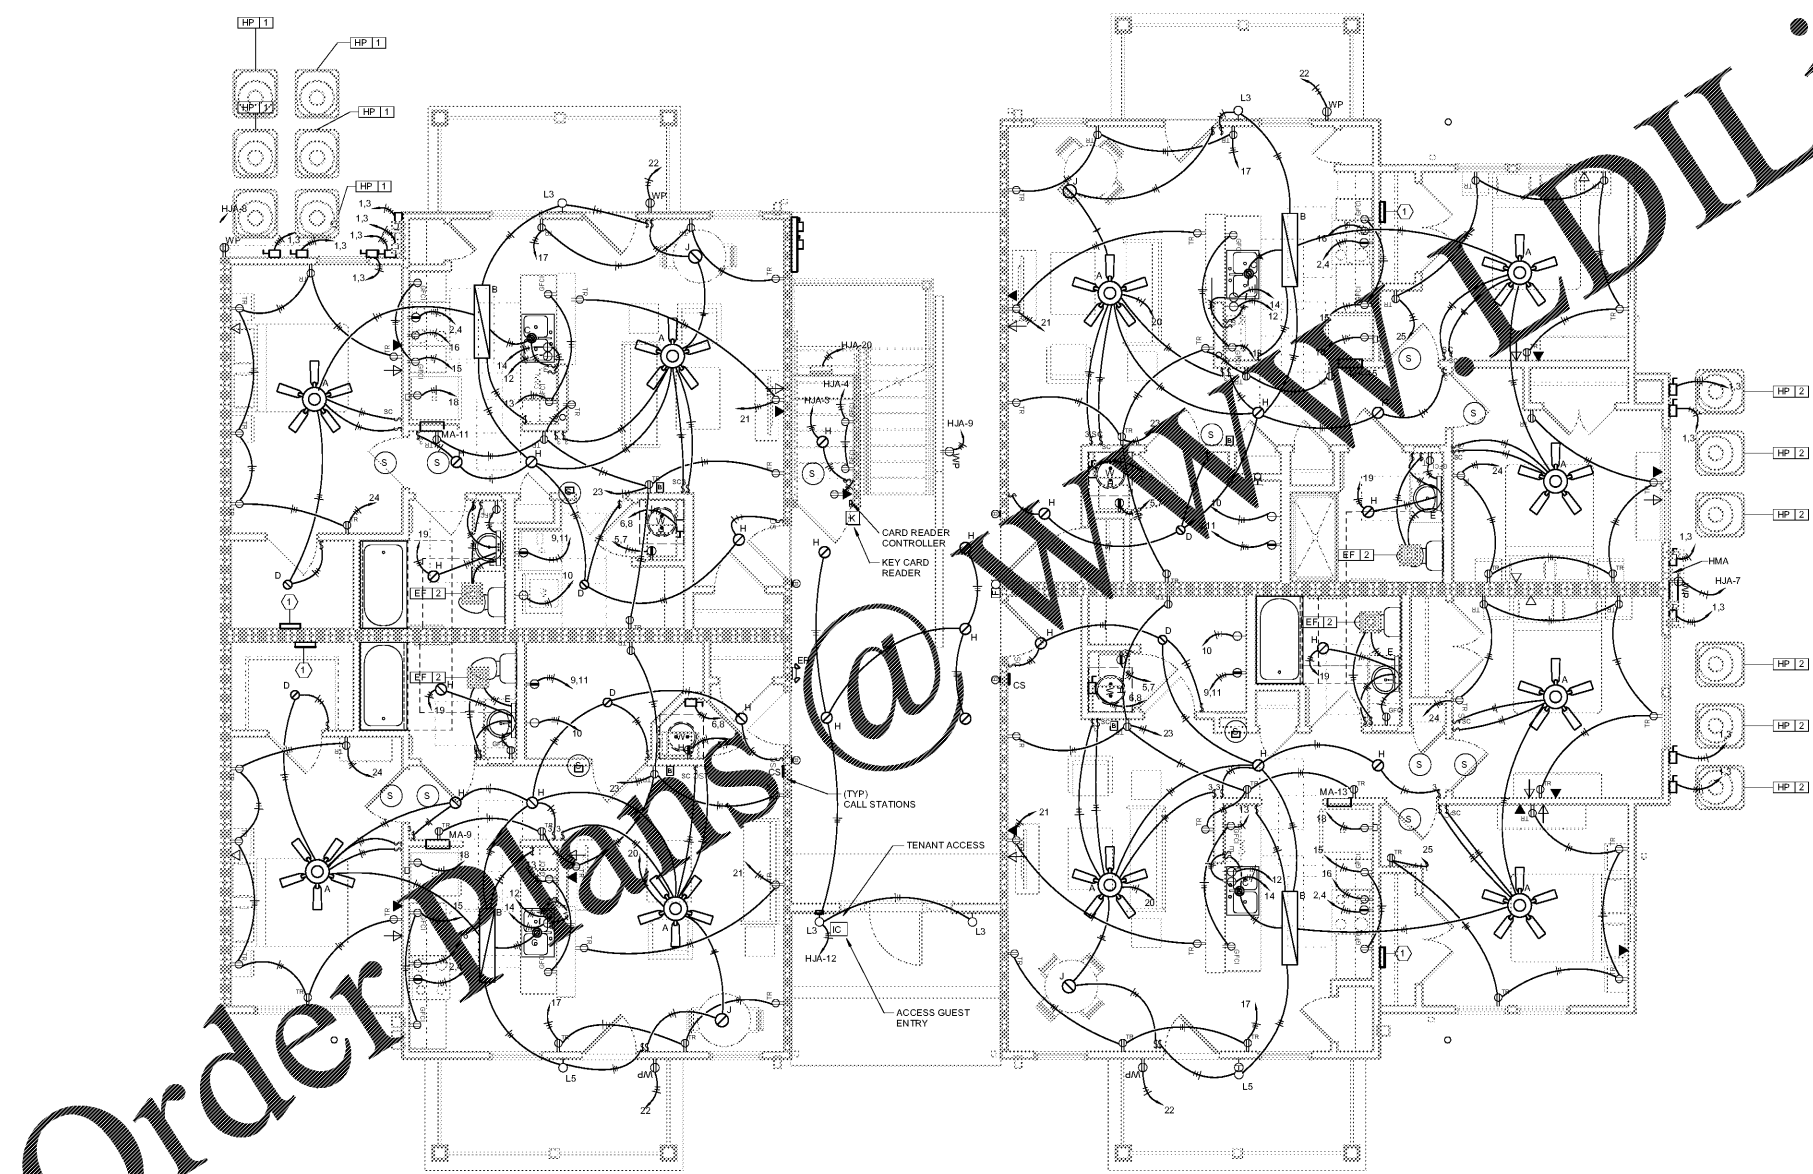

Order Plans @ WWW.DILine.com

1. ELECTRICAL GROUND FLOOR PLAN - BUILDING M-A-2
 1/4" = 1'-0"

MA-E202