



© 2019 STARBUCKS COFFEE COMPANY

**STARBUCKS®**  
2401 UTAH AVENUE SOUTH  
SEATTLE, WASHINGTON 98134  
(206) 318-1575

THESE DRAWINGS AND THE PROJECT MANUAL ARE CONFIDENTIAL AND SHALL REMAIN THE SOLE PROPERTY OF STARBUCKS CORPORATION, WHICH IS THE OWNER OF THE COPYRIGHT IN THIS WORK. THEY SHALL NOT BE REPRODUCED IN WHOLE OR IN PART, SHARED WITH THIRD PARTIES OR USED IN ANY MANNER ON OTHER PROJECTS OR EXTENSIONS TO THIS PROJECT WITHOUT THE PRIOR WRITTEN CONSENT OF STARBUCKS CORPORATION. THESE DRAWINGS AND SPECIFICATIONS ARE INTENDED TO EXPRESS DESIGN INTENT FOR A PROTOTYPICAL STARBUCKS STORE (WHICH IS SUBJECT TO CHANGE AT ANYTIME) AND DO NOT REFLECT ACTUAL SITE CONDITIONS. NEITHER PARTY SHALL HAVE ANY OBLIGATION OR LIABILITY TO THE OTHER (EXCEPT AS STATED ABOVE) UNTIL A WRITTEN AGREEMENT IS FULLY EXECUTED BY BOTH PARTIES.

STARBUCKS TEMPLATE VERSION: I2020-02-10

**Design Forum Architects Inc.**

2506 Byers Rd  
Miami, OH 43142  
Tel: (614) 804-7700

Donald J. Rehrman  
Architect In Charge  
License: AR0017303

**Design Forum Engineering**

2506 Byers Rd  
Miami, OH 43142  
Tel: (614) 804-7700

Timothy L. Raderding, PE  
Professional Engineer  
License: 62078

PROJECT NAME:  
**HARDEN & POLK**

PROJECT ADDRESS:  
1310 LAKESIDE VILLAGE CIR  
LAKELAND, FL 33803

STORE #: 2965  
PROJECT #: 21120-060  
ISSUE DATE: 08/17/20  
DESIGNER: RAI MONTERO  
PRODUCTION DESIGNER: ANDY MCLLOUD  
CHECKED BY: RAI MONTERO

Revision Schedule

Rev	Date	By	Description

SHEET TITLE:  
**BUILDING FLOOR PENETRATION PLAN**  
SCALE: AS SHOWN

SHEET NUMBER:  
**A-102**


**GENERAL NOTES**

- A. ALL STUB-UP DIMENSIONS ARE RELATIVE TO FINISHED WALL LOCATIONS (SHOWN AS OUTLINE ON THIS PLAN). REFER TO FLOOR PLAN FOR WALL PENETRATIONS.
- B. FLOOR SINK/ DRAIN: REFER TO CUT SHEETS FOR COMPONENT SPECIFICATIONS AND OUTLET REQUIREMENTS.
- C. WASTE LINE PENETRATIONS: REFER TO PLUMBING PLANS FOR INDIVIDUAL LINE LOCATIONS.
- D. STUB-UP PENETRATIONS: REFER TO ELECTRICAL AND PLUMBING PLANS FOR INDIVIDUAL STUB-UP LOCATIONS.
- E. TOILET FLOOR PENETRATION: REFER TO CUT SHEETS FOR STUB-UP LOCATION RELATIVE TO FINISHED WALL.
- F. FLOOR PENETRATIONS AT MOP SINK: REFER TO PLUMBING PLANS FOR INDIVIDUAL LINE SPECIFICATION.
- G. PENETRATION TO BE LOCATED ON CENTERLINE OF WALL OR AS REQUIRED PER CONDITIONS.
- H. ALL OUTLETS IN CAFE TO MATCH SURROUNDING COLOR RECEPTACLES AND COVER PLATE.
- J. LOCATION OF DUPLEX OUTLET AT 18" AFF. COORDINATE LOCATIONS WITH STARBUCKS CM. REFER TO ELECTRICAL SHEETS FOR MORE INFORMATION.
- K. DUPLEX FLOOR OUTLET. COORDINATE FLOOR RECEPTACLES LOCATION WITH TABLE LEG.
- L. LOCATION OF POWER AND DATA OUTLETS BEHIND MENU BOARDS. CENTER OUTLETS BEHIND MENU BOARDS. REFER TO DETAIL 211-508 FOR MORE INFORMATION.
- M. REFER TO SHEET I-106 FOR FLOOR FINISHES.
- N. EXISTING HOSE BIB.
- P. POWER STRIP AT SIT-HERE BAR.
- Q. EXISTING EXTERIOR GFCI OUTLET.

**LEGEND**


- FLOOR SINK
- FLOOR PENETRATION
- ELECTRICAL PENETRATION AREA
- DATUM POINT
- DRAIN FLOOR SINK (RESTROOMS)
- DATA OUTLET
- FLOOR OUTLET
- WALL OUTLET

NOTE: SEE SHEET I-101.1 FOR PLUMBING FIXTURE SCHEDULE.

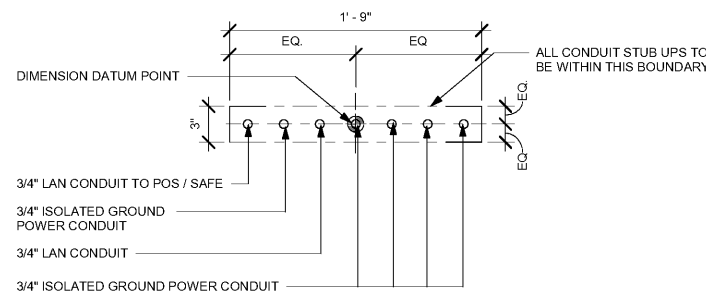


**2 STUB UPS - FRONTBAR**

Scale: 1 1/2" = 1'-0"

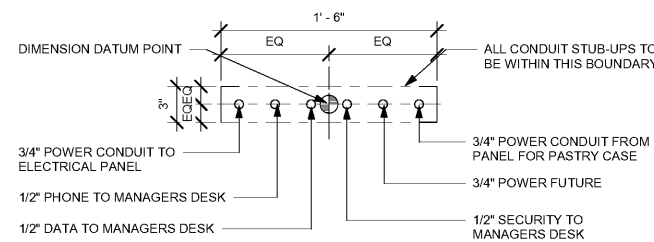

**3 STUB UPS - DOUBLE POS/SAFE**

Scale: 1 1/2" = 1'-0"

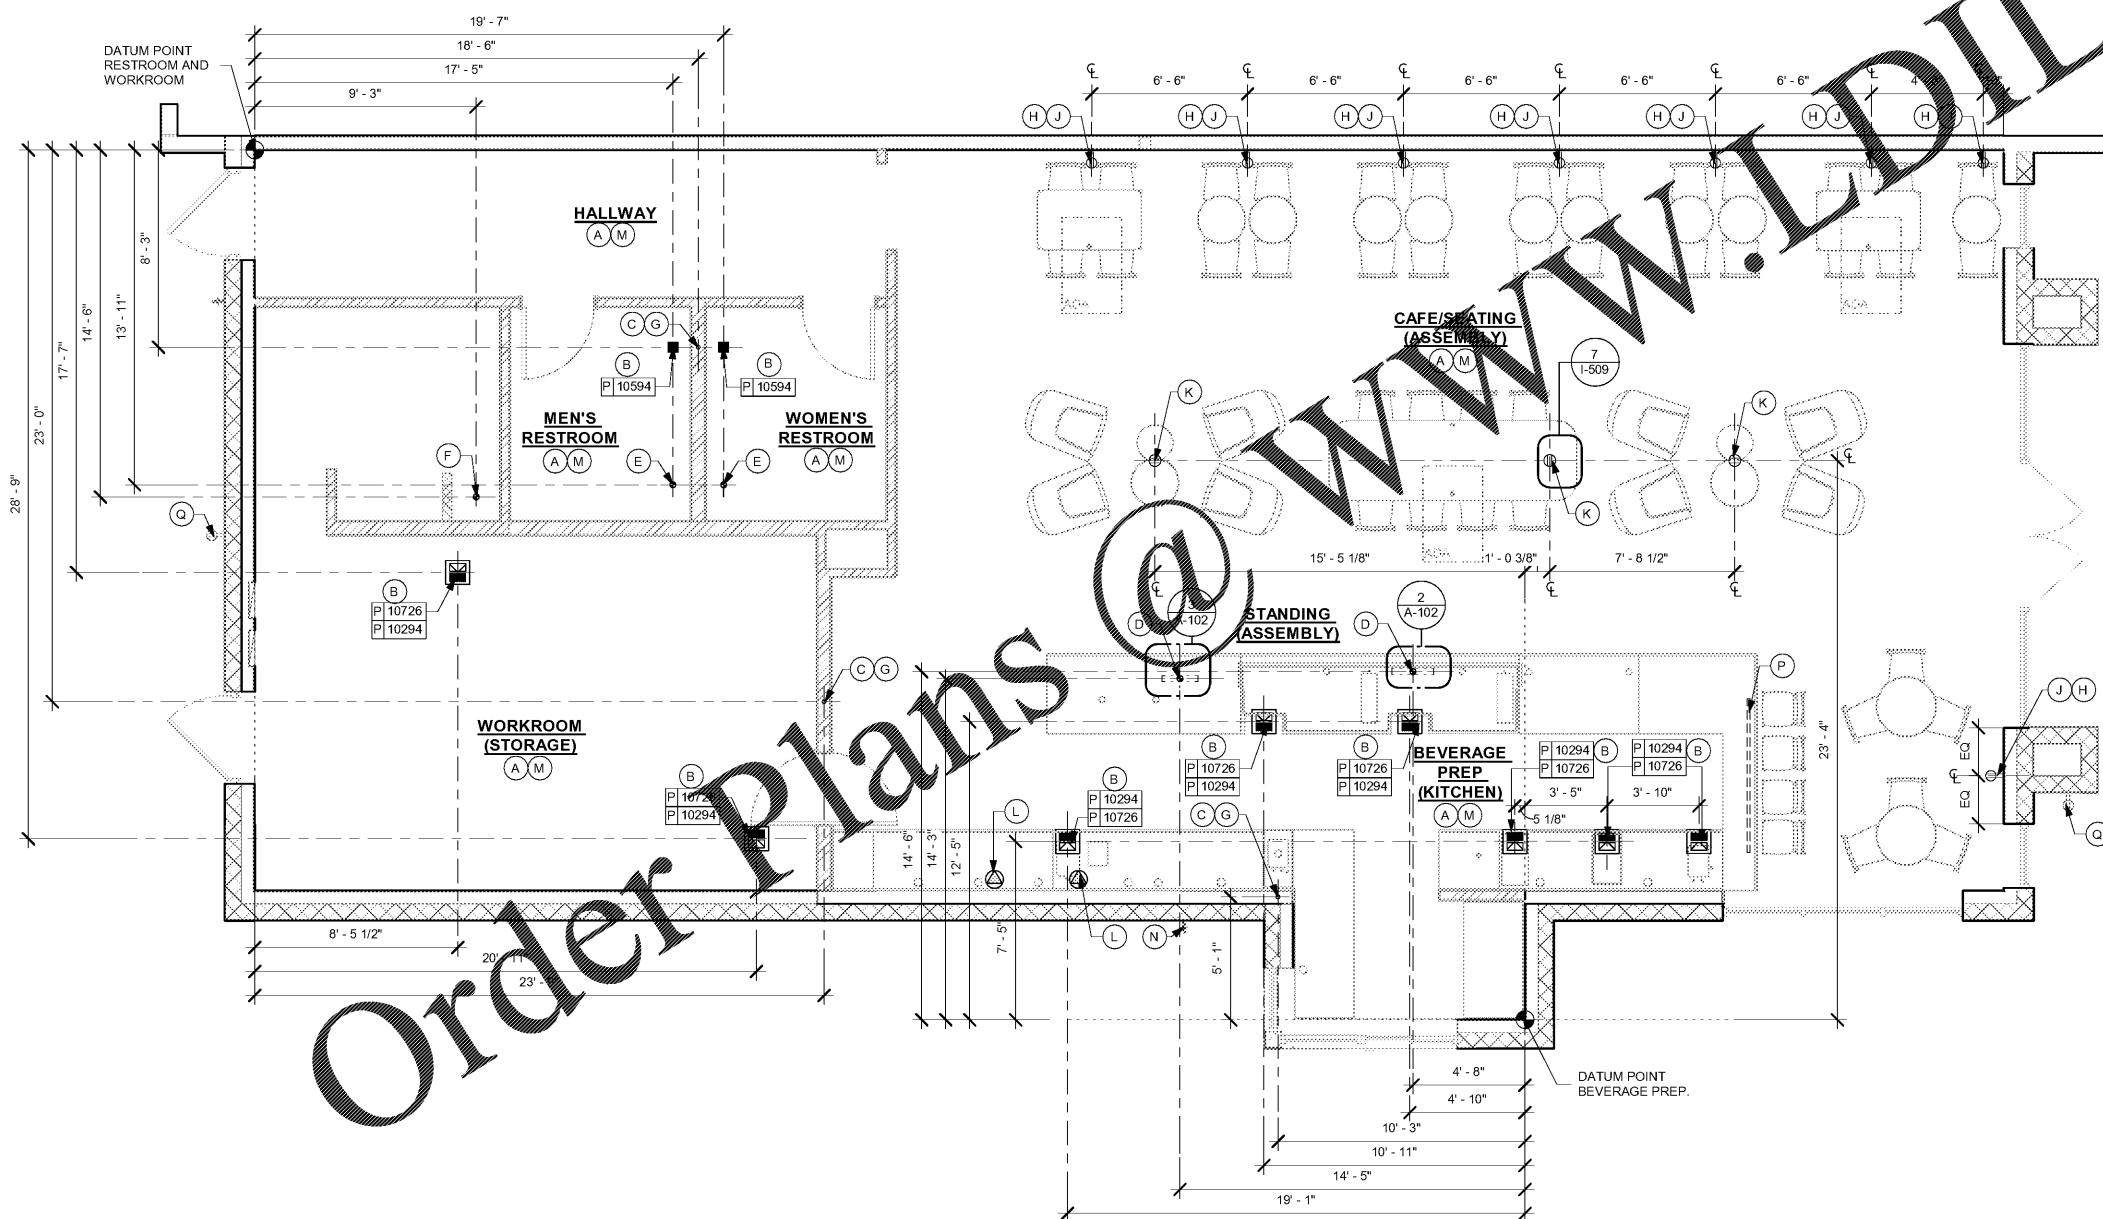

**1 BUILDING FLOOR PENETRATION PLAN**

Scale: 1/4" = 1'-0"

