


LIGHTING FIXTURE SCHEDULE - "L"						
DESIGN ID	COUNT	DESCRIPTION	FURN. BY	INST. BY	BULB	COMMENTS
EXIT						
19044	2	LED EXIT SIGN WITH EMERGENCY LIGHT - WHITE AND RED	SB	GC	INTEGRATED LED	
19047	3	LED EXIT SIGN WITH EMERGENCY LIGHT - BLACK AND GREEN	SB	GC	INTEGRATED LED	
19057	2	LED EMERGENCY LIGHT DOUBLE - BLACK	SB	GC	INTEGRATED LED	
RECESSED CAN						
19023	66	CAN - LED MOUNTING FRAME - 2IN 50MM - NEW CEILING	SB	GC		
19115	59	CAN - LED ADJUSTABLE GIMBAL WITH DRIVER - 2IN 50MM - BLACK - 1000LM SPOT	SB	GC		
19117	7	CAN - LED ADJUSTABLE GIMBAL WITH DRIVER - 2IN 50MM - BLACK - 1000LM FLOOD	SB	GC		
SCONCE						
14894	6	LED PICTURE LIGHT TRADITIONAL - 24IN 610MM - BRONZE	SB	GC	INTEGRATED LED	
20748	2	SCONCE - KUZCO PLUTO TRIPLE - CHROME	SB	GC	INTEGRATED LED	VD: LITE SITE; SKU#08905; PROVIDED BY: KUZCO, FINISH: CHROME
STRIP						
14410	6	STRIP - LED TAPE - VARIABLE LENGTH - 315LM PER FT	SB	GC	INTEGRATED LED	LENGTH REQUIRED: (1) 28' - 4" LENGTH (4) 1' - 11" LENGTH (1) 1' - 8" LENGTH
TRACK						
12946	1	TRACK - WITH CONNECTORS - 4FT 122CM - BLACK - 1 CIRCUIT	SB	GC		ALL BAR / CAFE TRACK LIGHTING TO BE RUN THROUGH 1A / 2A CURRENT LIMITING DEVICE #RCLF12BL-TCL2BL; SEE ELECTRICAL DRAWINGS FOR ADDITIONAL INFORMATION
12947	1	TRACK - WITH CONNECTORS - 8FT 244CM - BLACK - 1 CIRCUIT	SB	GC		ALL BAR / CAFE TRACK LIGHTING TO BE RUN THROUGH 1A / 2A CURRENT LIMITING DEVICE #RCLF12BL-TCL2BL; SEE ELECTRICAL DRAWINGS FOR ADDITIONAL INFORMATION
12948	2	TRACK - WITH CONNECTORS - 16FT 488CM - BLACK - 1 CIRCUIT	SB	GC		ALL BAR / CAFE TRACK LIGHTING TO BE RUN THROUGH 1A / 2A CURRENT LIMITING DEVICE #RCLF12BL-TCL2BL; SEE ELECTRICAL DRAWINGS FOR ADDITIONAL INFORMATION
12949	1	TRACK - WITH CONNECTORS - 12FT 365CM - BLACK - 1 CIRCUIT	SB	GC		ALL BAR / CAFE TRACK LIGHTING TO BE RUN THROUGH 1A / 2A CURRENT LIMITING DEVICE #RCLF12BL-TCL2BL; SEE ELECTRICAL DRAWINGS FOR ADDITIONAL INFORMATION
15056	1	TRACK - WITH CONNECTORS - 6FT 183CM - BLACK - 1 CIRCUIT	SB	GC		ALL BAR / CAFE TRACK LIGHTING TO BE RUN THROUGH 1A / 2A CURRENT LIMITING DEVICE #RCLF12BL-TCL2BL; SEE ELECTRICAL DRAWINGS FOR ADDITIONAL INFORMATION
19083	16	TRACK - LED FIXTURE - 2IN 50MM - BLACK - 900LM FLOOD	SB	GC	INTEGRATED LED	
TROFFER						
15057	7	TROFFER - LED RECESSED - 24X48IN 600X1200MM - WHITE - 3900LM	SB	GC	INTEGRATED LED	

LIGHTING LEGEND

- A 2" RECESSED CAN (ADJUSTABLE) BLACK 1000 LM - SPOT LIGHT
- B 2" RECESSED CAN (ADJUSTABLE) BLACK 1000 LM - FLOOD LIGHT
- C TRACK HEAD: BLACK 900 LM - FLOOD LIGHT


LEGEND

- DATUM
- TRACK LIGHTING
- STRIP LIGHTING
- RECESSED CAN LIGHT
- TROFFER
- RESTROOM SCONCE
- EXIT SECURITY LIGHT
- SPEAKER (WALL MOUNTED)
- SPEAKER (RECESSED - CEILING MOUNTED)
- PICTURE LIGHT

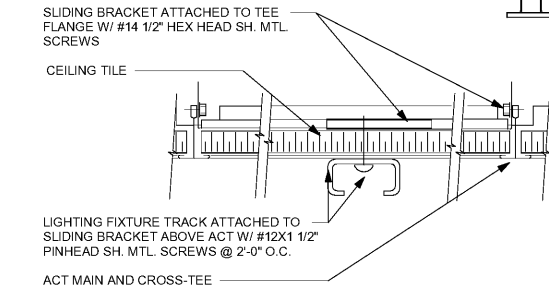

2 TRACK LIGHT - ACT MOUNT

Scale: 6" = 1'-0"

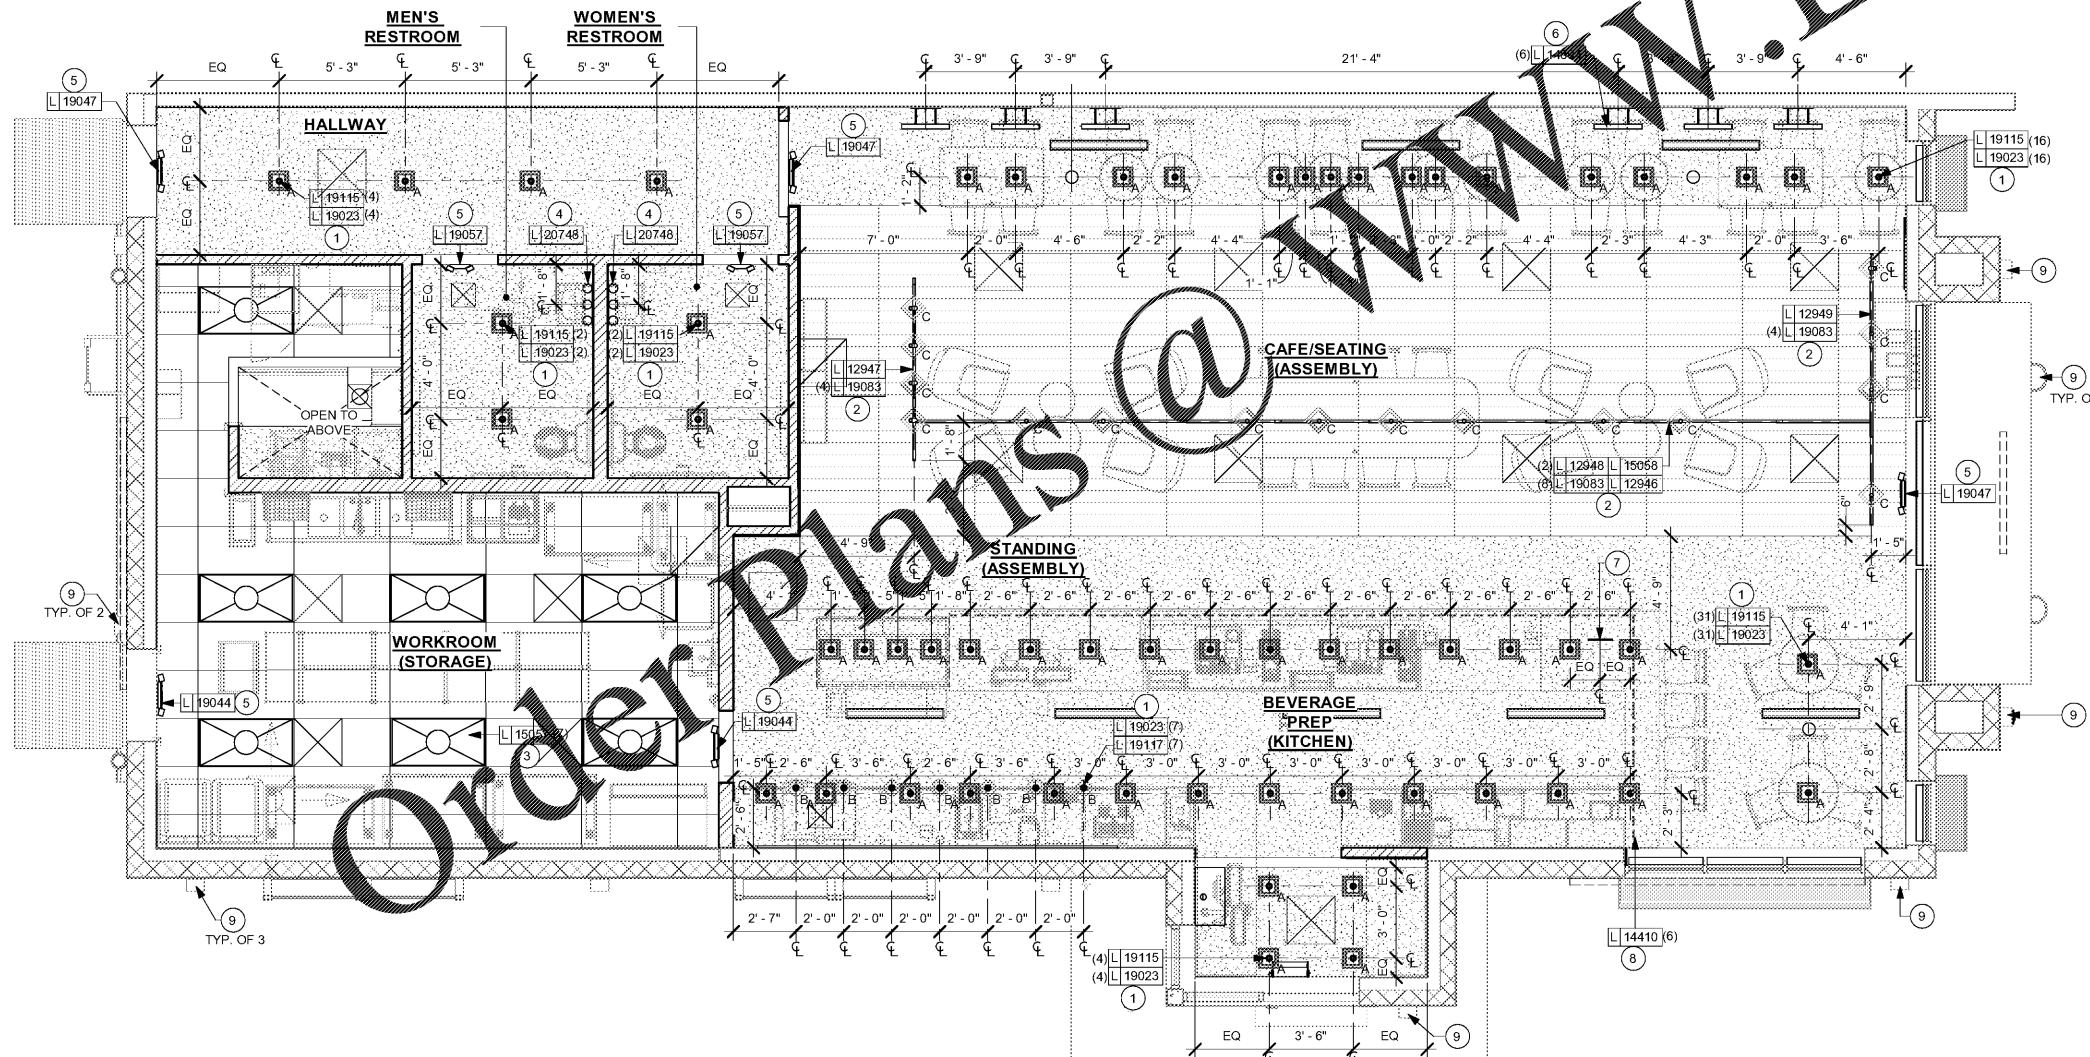

1 DIMENSIONED CEILING AND LIGHTING PLAN

Scale: 1/4" = 1'-0"

GENERAL NOTES

- WHERE ACOUSTICAL CEILING MEETS WALL, PROVIDE ANGLE WALL MOLDING FOR REVEAL. MATCH CEILING GRID COLOR WHEN APPLICABLE.
- PAINT SUBSTITUTIONS ARE NOT ALLOWED. USE STARBUCKS' NATIONAL ACCOUNT COLOR CODE WHEN ORDERING PAINTS. SEE SHEET I-602 FOR PAINT SCHEDULES.
- ALL FIXTURES IN FOOD PREPARATION AREA SHALL HAVE SHATTERPROOF LAMPS IF THE FIXTURE IS NOT LENSED.
- PROVIDE GROMMETS FOR ALL CEILING PENETRATIONS FOR FIXTURES/SUPPORTS.
- ADJUST FOCUS OF ALL TRACK AND RECESSED DOWNLIGHTS TO FULLY ILLUMINATE ALL AIRWORK, MENU BOARDS AND MERCHANDISE BAYS.
- IF PENDANT SUSPENDED LENGTH EXCEEDS 48" (1220MM) FROM CEILING, REPLACE WITH SURFACE-MOUNTED PENDANT AND SUSPEND WITH GC-SUPPLIED CONDUIT AND J-BOX TO DIMENSIONED HEIGHT.
- CENTER EMERGENCY/EXIT LIGHTS ABOVE DOORS, UON.

KEYED NOTES

- INSTALL RECESSED CAN LIGHTS AS INDICATED.
- INSTALL SURFACE MOUNTED TRACK LIGHTING AS INDICATED.
- INSTALL RECESSED TROFFER LIGHTS AS INDICATED.
- MOUNT RESTROOM WALL SCONCE WITH CENTER OF J-BOX AT 6' - 8" AFF AS INDICATED ON RESTROOM ELEVATIONS.
- LOCATIONS OF ALL EGRESS LIGHTING FOR REFERENCE ONLY. GC TO VERIFY WITH LOCAL FIRE MARSHAL PRIOR TO INSTALLATION.
- INSTALL PICTURE LIGHTS LOCATED IN CAFE AREA AS INDICATED. REFER TO INTERIOR ELEVATION FOR MOUNTING HEIGHT.
- INSTALL MOP SIGNAGE AS INDICATED. POWER TO BE PROVIDED THROUGH SOFFIT. REFER TO INTERIOR ELEVATION FOR MOUNTING HEIGHT.
- INSTALL LED STRIP LIGHT UNDER FRONT BAR COUNTER AS INDICATED.
- EXISTING EXTERIOR WALL SCONCE.

RESPONSIBILITY LEGEND

FURN. BY	INST. BY
SB - FURNISHED BY STARBUCKS	GC - INSTALLED BY GENERAL CONTRACTOR
GC - INSTALLED BY GENERAL CONTRACTOR	SB - INSTALLED BY STARBUCKS
	VD - INSTALLED BY VENDOR

NOTE: ALL RESPONSIBILITIES TO BE CONFIRMED WITH STARBUCKS CONSTRUCTION MANAGER PRIOR TO ORDERING / CONSTRUCTION.



STARBUCKS
2401 UTAH AVENUE SOUTH
SEATTLE, WASHINGTON 98134
(206) 318-1575

THESE DRAWINGS AND THE PROJECT MANUAL ARE CONFIDENTIAL AND SHALL REMAIN THE SOLE PROPERTY OF STARBUCKS CORPORATION, WHICH IS THE OWNER OF THE COPYRIGHT IN THIS WORK. THEY SHALL NOT BE REPRODUCED IN WHOLE OR IN PART, SHARED WITH THIRD PARTIES OR USED IN ANY MANNER ON OTHER PROJECTS OR EXTENSIONS TO THIS PROJECT WITHOUT THE PRIOR WRITTEN CONSENT OF STARBUCKS CORPORATION. THESE DRAWINGS AND SPECIFICATIONS ARE INTENDED TO EXPRESS DESIGN INTENT FOR A PROTOTYPICAL STARBUCKS STORE (WHICH IS SUBJECT TO CHANGE AT ANYTIME) AND DO NOT REFLECT ACTUAL SITE CONDITIONS. NEITHER PARTY SHALL HAVE ANY OBLIGATION, NOR LIABILITY TO THE OTHER EXCEPT AS STATED ABOVE UNTIL A WRITTEN AGREEMENT IS FULLY EXECUTED BY BOTH PARTIES.

STARBUCKS TEMPLATE VERSION: I2020-02-10

Design Forum Architects Inc.
2506 Byers Rd
Miami, OH 43142
Tel: (614) 804-7700

Donald J. Rehrman
Architect in Charge
License: AR0017303

Design Forum Engineering
2506 Byers Rd
Miami, OH 43142
Tel: (614) 804-7700

Timothy L. Hadering, PE
Professional Engineer
License: 62078

PROJECT NAME:
HARDEN & POLK

PROJECT ADDRESS:
1310 LAKESIDE VILLAGE CIR
LAKELAND, FL 33803

STORE #: 2965
PROJECT #: 21120-060
ISSUE DATE: 08/17/20
DESIGNER: RAI MONTERO
PRODUCTION DESIGNER: ANDY MCLLOUD
CHECKED BY: RAI MONTERO

Revision Schedule			
Rev	Date	By	Description

SHEET TITLE:
DIMENSIONED CEILING AND LIGHTING PLAN
SCALE: 1/4" = 1'-0"

SHEET NUMBER:
A-105