

PAINT SCHEDULE					
COLOR CODE	DESCRIPTION	LRV	FURN. BY	INST. BY	COMMENTS
SW7019-ES	SW - GAUNTLET GRAY - EGGSHELL	17	GC	GC	USE PRIMER CP-1
SW7019-SG	SW - GAUNTLET GRAY - SEMIGLOSS	17	GC	GC	USE PRIMER CP-1
SW7045-ES	SW - INTELLECTUAL GRAY - EGGSHELL	36	GC	GC	USE PRIMER CP-1
SW7045-SG	SW - INTELLECTUAL GRAY - SEMIGLOSS	36	GC	GC	USE PRIMER CP-1
SW7049-ES	SW - NUANCE - EGGSHELL	74	GC	GC	USE PRIMER CP-1

WALL TREATMENT (AREA) SCHEDULE - "Q"					
DESIGN ID	AREA	DESCRIPTION	FURN. BY	INST. BY	COMMENTS
PLASTIC					
11469	1268 SF	FRP - WHITE	GC	GC	
TILE					
14744	538 SF	TILE - PRO ARCHITECTURA - GREY PN11 - 4X12IN 100X300MM	SB	GC	GROUT: MAPEI - 02 PEWTER, OR EQUAL
20243	363 SF	TILE - COLOR STUDIO - WHITE - BRICK MOSAIC - 12X12IN 300X300MM SHEET	SB	GC	GROUT: MAPEI - 47 CHARCOAL, OR EQUAL
WALLCOVERING					
20623	347 SF	VINYL WALLCOVERING - BURLAP - RETREAT	SB	GC	
WOOD CLADDING					
X9202	180 SF	WOOD - WALNUT - PLANK - VERTICAL	SB	GC	FINISH: WD0077 (MAD100) BY CASEWORK VENDOR

WALL TREATMENT (LENGTH) SCHEDULE - "R"					
DESIGN ID	LENGTH	DESCRIPTION	FURN. BY	INST. BY	COMMENTS
CHAIR RAIL					
X9201	46' - 6 3/4"	1" METAL CHAIR RAIL	GC	GC	FINISH: MT0028; MOUNTED TO 31IN (784MM) AFF SEE DETAIL: 2/I-502 ;BY CASEWORK VENDOR
TRIM					
X9203	23' - 0"	METAL TRIM AT WOOD CLADDING EDGES	GC	GC	FINISH: MT0028; LOCATION: CAFE; SEE DETAIL: 7/I-502 ;BY CASEWORK VENDOR
WAINSCOT					
14302	46' - 6 3/4"	VINYL WAINSCOT - ASPERO - BLACK	SB	GC	MOUNTED TO 31IN (784MM) AFF

LEGEND

- 1 INDICATES PARTIAL HEIGHT - FRP* [Q11469]
- 2 INDICATES BACKBAR WALL TILE* [Q20243]
- 3 INDICATES CHAIR RAIL AND WAINSCOT UP TO 2' - 7" AFF AND WALLCOVERING ABOVE* [RX9201] [R14302] [Q20623]
- 4 INDICATES WOOD CLADDING - WD0077 (MAD100-V)* [QX9202]
- 5 INDICATES FULL HEIGHT FRP - WHITE* [Q11469]
- 6 INDICATES RESTROOM WALL TILE** [Q14744]
- 7 INDICATES HOT ROLLED STEEL CORNER GUARD FOR BOH INSTALL 6" (150mm) TO CEILING HEIGHT (AS APPLIED). [C10829]
- * SEE INTERIOR FINISH ELEVATIONS FOR TAGGED LOCATION OF WALL FINISH MATERIAL.
- ** SEE RESTROOM PLAN & ELEVATIONS FOR TAGGED LOCATION OF WALL FINISH MATERIAL.

GENERAL NOTES

- A. WORKROOM TO BE FINISHED PER LOCAL CODE REQUIREMENTS.
 - B. GENERAL CONTRACTOR TO PROVIDE AND INSTALL WORKROOM WALL FINISHES.
 - C. FLOORS, WALLS AND CEILING FINISHES IN FOOD PREPARATION AREAS SHALL BE SMOOTH, NON-TOXIC, NON-ABSORBENT, DURABLE AND EASILY CLEANABLE. PAINT SHALL BE WASHABLE, SEMI-GLOSS OR HIGH-GLOSS FINISH.
 - D. CHANGE PAINT COLOR ONLY AT INSIDE CORNERS UNLESS OTHERWISE INDICATED.
- PAINT SUBSTITUTIONS ARE NOT ALLOWED. USE STARBUCKS' NATIONAL ACCOUNT "COLOR CODE" ORDERING PAINTS.
- PAINT FINISHES SHALL BE APPLIED AS FOLLOWS, UNLESS NOTED OTHERWISE:
1. WOODS AND METAL SURFACES SHALL BE SEMI-GLOSS OR EQUAL.
 2. ACCENT AND TRIM PAINTS TO BE SEMI-GLOSS OR EQUAL.
 - a. WALL AND CEILING PAINTS TO BE EGGSHELL OR EQUAL.
 3. PAINTS IN BOH, RESTROOM(S) OR CAFE BAR SHALL BE SEMI-GLOSS OR EQUAL.
- G. ALL WOOD SURFACES (DOORS, TRIM, SHELVES, CABINETRY) SHALL BE SEALED.
 - H. REFER TO CASEWORK FINISH SCHEDULE FOR CASEWORK FINISH MATERIAL INFORMATION.
 - I. REFER TO INTERIOR FINISH ELEVATIONS FOR ARTWORK/ GRAPHICS LOCATIONS.
 - J. REFER TO MANUFACTURER'S INSTRUCTIONS INCLUDED WITH ARTWORK/GRAPHICS FOR PROPER INSTALLATION.
 - K. ALL FLOOR AND WALL JUNCTIONS IN STORAGE AND FOOD PREPARATION AREAS SHALL HAVE A 6" COVED BASE.
 - L. INSTALL BLOCKING AND HANGERS FOR WALL SHELVING BEFORE INSTALLING BACK BAR TILE.

KEYED NOTES

1. INSTALL FULL HEIGHT FRP AT WORKROOM WALLS AS INDICATED.
2. PROVIDE FIRE TREATED BLOCKING AS REQUIRED TO SUPPORT WALL ATTACHMENTS (SEE BUILDING FLOOR PLAN ON SHEET A-101 FOR MORE INFORMATION).
3. REFER TO SHEET I-502 FOR WALL FINISH DETAILS.
4. FRP BENEATH BACKBAR AT EXPOSED WALLS EXCEPT AT WARMING STATION. EXTEND FROM TOP OF WALL BASE TO UNDERSIDE OF COUNTERTOP.
5. RECESSED ELECTRICAL PANELS BY LL.
6. MOP SINK FULL HEIGHT FRP AT ENCLOSURE (SEE PLUMBING PLANS FOR MORE INFORMATION).
7. BACKBAR TILE TO RETURN TO MULLIONS WITHIN DRIVE-THRU WINDOW OPENING AS INDICATED.
8. INSTALL WALL TILE AT RESTROOMS AS INDICATED.
9. INSTALL CORNER GUARD AT OUTSIDE CORNER AS INDICATED. SEE DETAILS: 8/I-502.
10. PAINT WALL ABOVE STOREFRONT GLAZING AS INDICATED ON INTERIOR FINISH ELEVATIONS.
11. PAINT WALL AS INDICATED ON INTERIOR FINISH ELEVATIONS.
12. INSTALL CHAIR RAIL AND WAINSCOT AS INDICATED.
13. INSTALL METAL FLAT BAR AT DT OPENING AS INDICATED.
14. INSTALL WOOD END CAP AS INDICATED.
15. INSTALL METAL TRIM AT WOOD CLADDING CORNERS AS INDICATED.

RESPONSIBILITY LEGEND

FURN. BY	INST. BY
SB - FURNISHED BY STARBUCKS	GC - INSTALLED BY GENERAL CONTRACTOR
GC - INSTALLED BY GENERAL CONTRACTOR	SB - INSTALLED BY STARBUCKS
	VD - INSTALLED BY VENDOR

NOTE: ALL RESPONSIBILITIES TO BE CONFIRMED WITH STARBUCKS CONSTRUCTION MANAGER PRIOR TO ORDERING / CONSTRUCTION.



© 2019 STARBUCKS COFFEE COMPANY

STARBUCKS®
2401 UTAH AVENUE SOUTH
SEATTLE, WASHINGTON 98134
(206) 318-1575

THESE DRAWINGS AND THE PROJECT MANUAL ARE CONFIDENTIAL AND SHALL REMAIN THE SOLE PROPERTY OF STARBUCKS CORPORATION, WHICH IS THE OWNER OF THE COPYRIGHT IN THIS WORK. THEY SHALL NOT BE REPRODUCED IN WHOLE OR IN PART, SHARED WITH THIRD PARTIES OR USED IN ANY MANNER ON OTHER PROJECTS OR EXTENSIONS TO THIS PROJECT WITHOUT THE PRIOR WRITTEN CONSENT OF STARBUCKS CORPORATION. THESE DRAWINGS AND SPECIFICATIONS ARE INTENDED TO EXPRESS DESIGN INTENT FOR A PROTOTYPICAL STARBUCKS STORE (WHICH IS SUBJECT TO CHANGE AT ANYTIME) AND DO NOT REFLECT ACTUAL SITE CONDITIONS. NEITHER PARTY SHALL HAVE ANY OBLIGATION OR LIABILITY TO THE OTHER (EXCEPT STATED ABOVE) UNTIL A WRITTEN AGREEMENT IS FULLY EXECUTED BY BOTH PARTIES.

STARBUCKS TEMPLATE VERSION: I2020-02-10

Design Forum Architects Inc.
2506 Byers Rd
Miami, OH 45342
Tel: (614) 804-7700
Donald J. Rehrman
Architect in Charge
License: AR0017303

Design Forum Engineering
2506 Byers Rd
Miami, OH 45342
Tel: (614) 804-7700
Timothy L. Hadering, PE
Professional Engineer
License: 62078

PROJECT NAME:
HARDEN & POLK

PROJECT ADDRESS:
1310 LAKESIDE VILLAGE CIR
LAKELAND, FL 33803


STORE #: 2965
PROJECT #: 21120-060
ISSUE DATE: 08/17/20
DESIGNER: RAI MONTERO
PRODUCTION DESIGNER: ANDY MCLOUD
CHECKED BY: RAI MONTERO

Revision Schedule			
Rev	Date	By	Description

SHEET TITLE:
WALL FINISH PLAN


SCALE: 1/4" = 1'-0"

SHEET NUMBER:
I-107

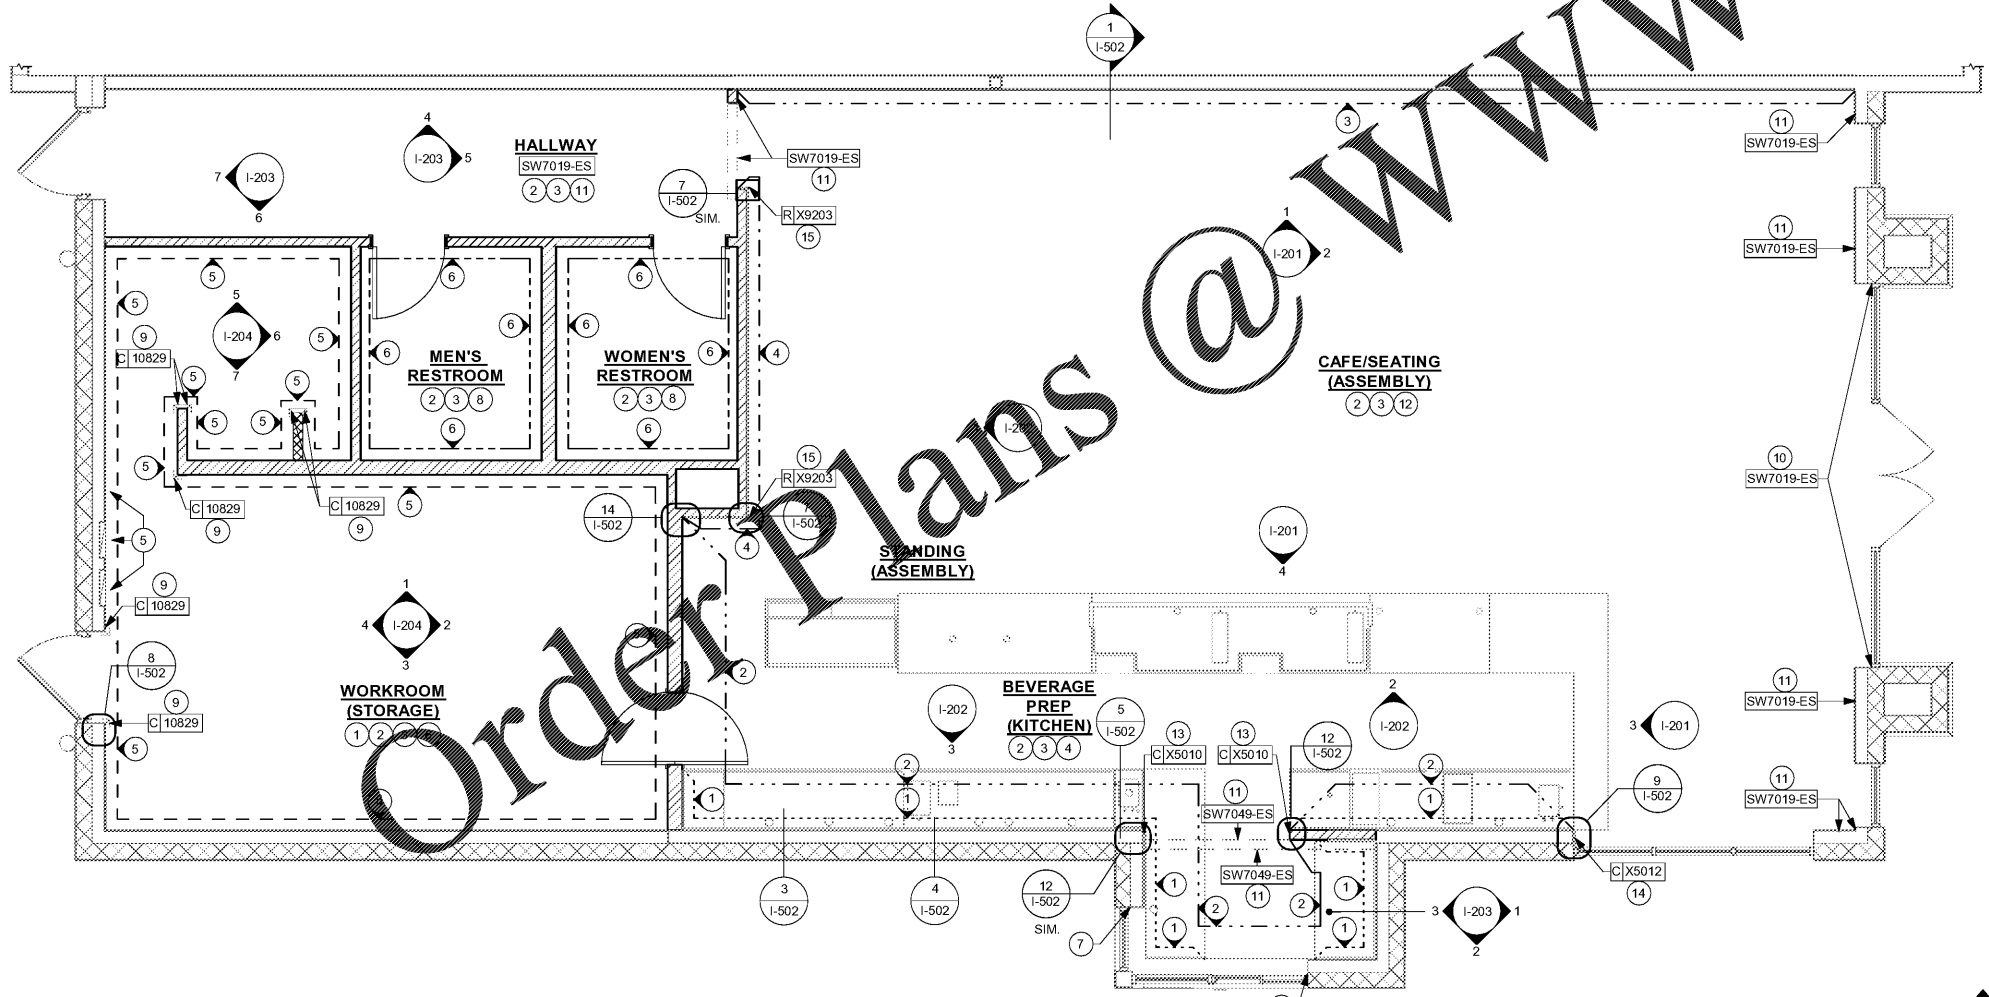

1 WALL FINISH PLAN

 Scale: 1/4" = 1'-0"



Scale: 1/4" = 1'-0"