

**TRACK SCHEDULE**

DESIGN ID	QUANTITY	DESCRIPTION	RESP.	MODEL	LAMP	MAX WATTS
12946	1	TRACK - WITH CONNECTORS - 4FT - BLACK	VD	TRACK: (1) JUNO R4BL END FEED CONN: (1) JUNO R38BL		0
12947	1	TRACK - WITH CONNECTORS - 8FT - BLACK	VD	TRACK: (2) JUNO R4BL END FEED CONN: (1) JUNO R38BL MINI CONNECTOR: (1) JUNO R23BL		0
12948	2	TRACK - WITH CONNECTORS - 16FT - BLACK	VD	TRACK: (4) JUNO R4BL END FEED CONN: (1) JUNO R38BL MINI CONNECTOR: (3) JUNO R23BL ADJUSTABLE CONN: (1) JUNO R20BL		0
12949	1	TRACK - WITH CONNECTORS - 12FT - BLACK	VD	TRACK: (3) JUNO R4BL END FEED CONN: (1) JUNO R38BL MINI CONNECTOR: (2) JUNO R23BL ADJUSTABLE CONN: (1) JUNO R20BL		0
15058	1	TRACK - WITH CONNECTORS - 6FT 183CM - BLACK	VD	TRACK: (1) JUNO R4BL & (1) R2BL END FEED CONN: (1) JUNO R38BL MINI CONNECTOR: (3) JUNO R23BL ADJUSTABLE CONN: (1) JUNO R20BL		0
19083	16	TRACK - LED FIXTURE - 2IN 50MM - BLACK - 900LM FLOOD	VD	GE LIGHTING #LTCIDA110FL927PQJ1BLCK	INTERGRAL LED	14

**LIGHTING FIXTURE SCHEDULE 'L'**

DESIGN ID	QUANTITY	DESCRIPTION	RESP.	MODEL	LAMP	MAX WATTS
14410	38	LED STRIP - 3W/LF REFER TO ARCHITECTURAL SCHEDULE FOR QUANTITIES AND LENGTHS	VD	AION #A024 83+ 27K-LE PROVIDE FIXTURE WITH PLASTIC SHIELD	LED TAPE STRIP	3
14894	6	LED PICTURE LIGHT TRADITIONAL - 24IN 610MM - BRONZE	VD	DOLAN HOSPITALITY #547667	INTEGRAL LED	10
15057	7	TROFFER - LED RECESSED - 24X48IN - 600X1200MM - WHITE - 3900LM	VD	INDY #S2X4BL-3935U-WH3	INTEGRAL LED	40
19023	66	CAN - LED MOUNTING FRAME - 2IN 50MM - NEW CEILING	VD	JUNO #2NCFM		
19044	2	LED EXIT SIGN WITH EMERGENCY LIGHT - WHITE AND RED	VD	NAVILITE #NXPCL3RWH	INTEGRAL LED	5
19047	3	LED EXIT SIGN WITH EMERGENCY LIGHT - BLACK AND GREEN	VD	NAVILITE #NXPCL3GBL	INTEGRAL LED	5
19057	2	LED EMERGENCY LIGHT DOUBLE - BLACK	VD	CONFIRM MODEL NUMBER WITH VENDOR	INTEGRAL LED	5
19115	59	CAN - LED ADJUSTABLE GIMBAL WITH DRIVER - 2IN 50MM - BLACK - 1000LM SPOT	VD	JUNO #2LEDDRIVER-G2-10LM-120-FRPC #2LEDTRIM-G2-ADJ-27K-90CRI-SP-BL	INTEGRAL LED	12
19117	7	CAN - LED ADJUSTABLE GIMBAL WITH DRIVER - 2IN 50MM - BLACK - 1000LM FLOOD	VD	JUNO #2LEDDRIVER-G2-10LM-120-FRPC #2LEDTRIM-G2-ADJ-27K-90CRI-FL-BL	INTEGRAL LED	12
20748	2	SCONCE - KUZCO PLUTO TRIPLE - CHROME	VD	DOLAN HOSPITALITY SKU# 708905	INTEGRAL LED	25

**LIGHTING DESIGN PLAN NOTES**

- ALL FIXTURES IN WORK ROOM, BACK AND FRONT LINE, ABOVE CONDIMENT CART, AND ANY OTHER AREAS WHERE EXPOSED FOOD, CLEAN EQUIPMENT OR UTENSILS, OR UNWRAPPED SINGLE SERVICE ITEMS WILL BE EXPOSED, SHALL HAVE SHATTERPROOF LAMPS IF THE FIXTURE IS NOT LENSED. ARCHITECT OF RECORD TO INCLUDE APPROPRIATE LAMPS / FIXTURES ON DRAWINGS AND SCHEDULES, AND COMPLY WITH ANY ADDITIONAL JURISDICTIONAL LIGHTING REQUIREMENT.
- PROVIDE GROMMET AT ALL CEILING PENETRATIONS FOR FIXTURES/SUPPORTS.
- CENTER EMERGENCY/EXIT LIGHTS ABOVE DOORS, UNLESS OTHERWISE NOTED.
- ADJUST FOCUS OF ALL TRACK AND RECESSED DIRECTIONAL LIGHTING TO FULLY ILLUMINATE ARTWORK, MENU BOARDS, AND SERVICE BAYS.
- IF PENDANT CYLINDER IS SUSPENDED WITH EXCEEDS 48" (1220MM) FROM CEILING, REPLACE WITH SURFACE MOUNTED CYLINDER MANS AND SUSPENSION. GENERAL CONTRACTOR SUPPLIED CONDUIT AND J-BOX TO DIMENSIONED HEIGHT.
- REFER TO POWER PLAN FOR PANELBOARD LOCATION.

**RESPONSIBILITY LEGEND**

SB	STARBUCKS	GC	GENERAL CONTRACTOR	VD	VENDOR	LL	LANDLORD
----	-----------	----	--------------------	----	--------	----	----------


**KEY NOTES**

- ELECTRICAL CONTRACTOR TO VERIFY THAT A WEATHERPROOF SWITCH IS PROVIDED BY THE SIGN COMPANY. IF NOT ONE MUST BE PROVIDED AND INSTALLED BY THE ELECTRICAL CONTRACTOR.
- ELECTRICAL CONTRACTOR TO PROVIDE DIRECT ACCESSIBLE POWER FOR ALL ELECTRICAL SIGNAGE WITHIN 6" OF THE SIGN LOCATION PROVIDE CONDUIT AND STUB THRU WALL, J-BOX AND ANY REQUIRED O.C.P. CIRCUIT THROUGH NEW LIGHTING CONTROL PANEL (SEE DETAILS ON E-502 AND E-601).
- SWITCH BANK LOCATION: SEE CONTROL ZONE DETAIL ON THIS SHEET. SWITCHES SHALL SERVE AS LOCAL OFF SWITCH.
- LED LIGHT STRIP: REFER TO ARCHITECTURAL DETAILS FOR ADDITIONAL MOUNTING INFORMATION.
- PROVIDE 3A CURRENT LIMITING DEVICE (CLD) #RCLF118L-TCL3BL CIRCUIT ALL SALES/SEATING AREA TRACK VIA THIS CLD.
- WALL MOUNTED OCCUPANCY SENSOR (LEVITON IPS02 1LW) SHALL CONTROL THE LIGHTS IN THIS ROOM. SET FOR 5 MINUTE TIME DELAY.
- LOCATION OF LIGHTING CONTACTORS/TIME SWITCH (SEE CONTROL ZONE SCHEDULE THIS SHEET AND LIGHTING CONTROL DIAGRAM ON E-601).
- EXIT SIGNS, EMERGENCY LIGHTS AND NIGHT LIGHTS SHALL BE CIRCUITED TO LOCAL CIRCUIT AHEAD OF ANY CONTROLS.
- PROVIDE 120V CONNECTION TO MOP SIGNAGE; CONTROL WITH BACK BAR/ PREP AREA ACCENT LIGHTS.
- EXISTING EXTERIOR NORMAL AND EMERGENCY EGRESS LIGHTING TO REMAIN: MAINTAIN EXISTING CIRCUITING AND CONTROLS.

**CONTROL ZONE SCHEDULE**

- a - BACK BAR/PREP AREA
  - b - BACK BAR ACCENT LIGHTS
  - c - 60% SEATING LIGHTS
  - d - 80% SEATING LIGHTS
  - e - SALES/SEATING TRACK\*
  - f - SEATING ACCENT LIGHTS
  - g - BACK OF HOUSE
  - T - 2 HR MAX TIMED OVERRIDE
- |                 |                 |                 |                  |
|-----------------|-----------------|-----------------|------------------|
| \$ <sup>6</sup> | \$ <sup>5</sup> | \$ <sup>4</sup> | \$ <sup>3</sup>  |
| \$ <sup>2</sup> | \$ <sup>1</sup> | \$ <sup>0</sup> | \$ <sup>-1</sup> |
- \* - PROVIDE COMPATIBLE DIMMER FOR SALES/SEATING TRACK LIGHTING (COORDINATE DIMMER REQUIREMENTS WITH VENDOR)

**2 LIGHTING SWITCHBANK DETAIL**

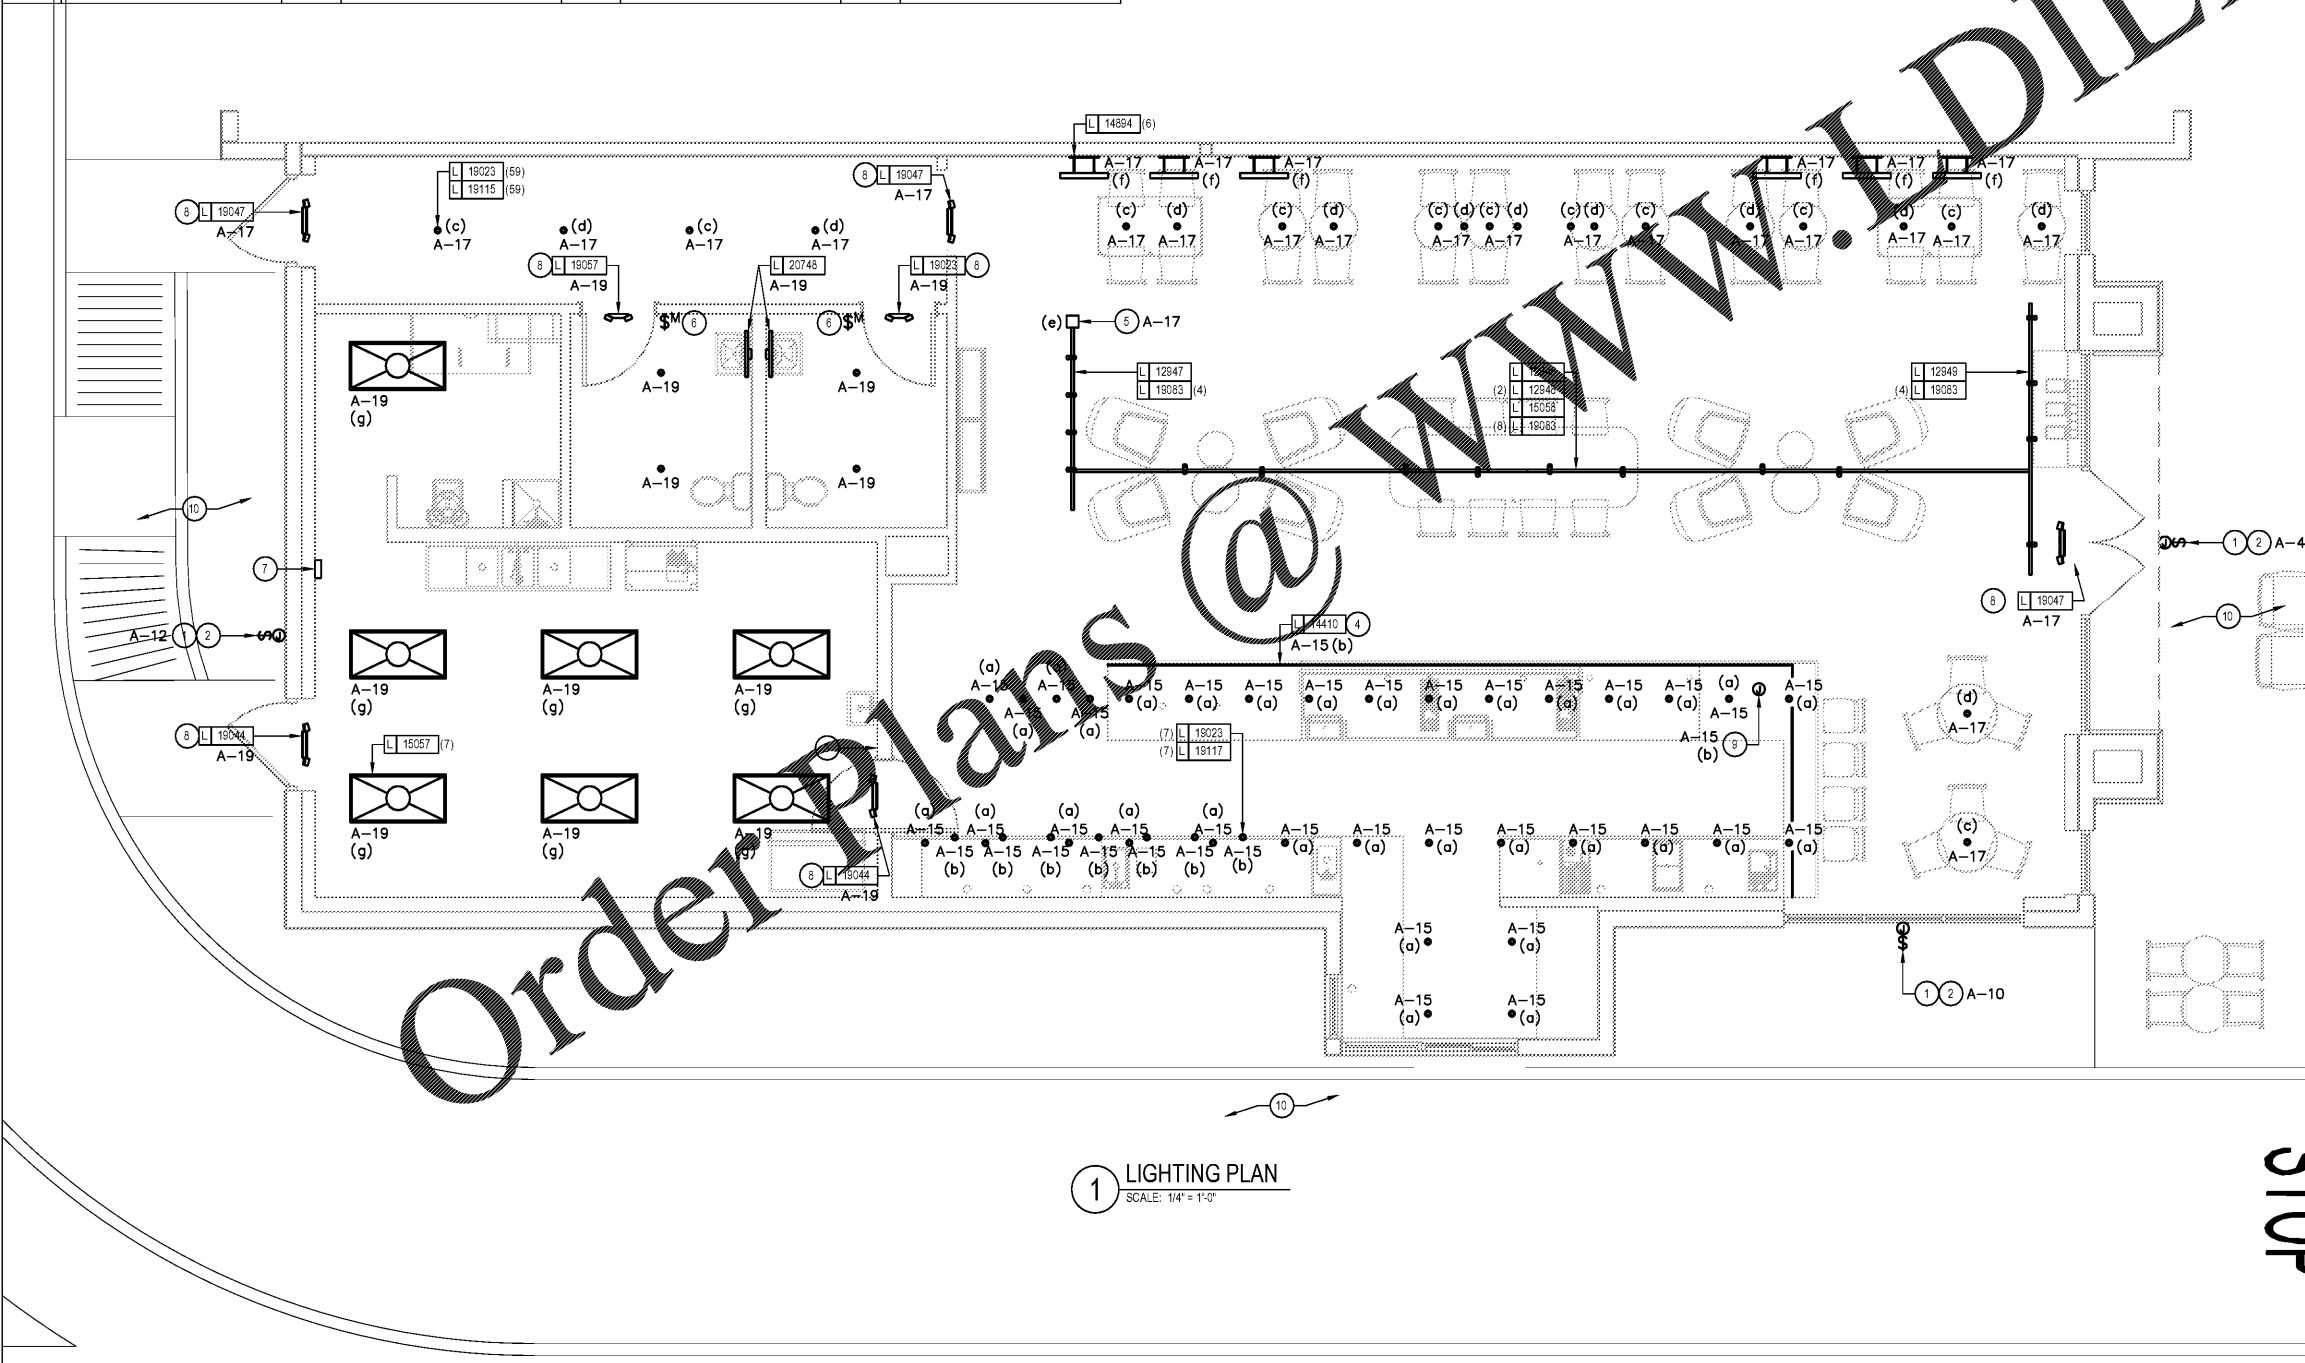

**STARBUCKS**  
2401 UTAH AVENUE SOUTH  
SEATTLE, WASHINGTON 98134  
(206) 318-1575

THESE DRAWINGS AND THE PROJECT MANUAL ARE CONFIDENTIAL AND SHALL REMAIN THE SOLE PROPERTY OF STARBUCKS CORPORATION, WHICH IS THE OWNER OF THE COPYRIGHT IN THIS WORK. THEY SHALL NOT BE REPRODUCED (IN WHOLE OR IN PART), SHARED WITH THIRD PARTIES OR USED IN ANY MANNER ON OTHER PROJECTS OR EXTENSIONS TO THIS PROJECT WITHOUT THE PRIOR WRITTEN CONSENT OF STARBUCKS CORPORATION. THESE DRAWINGS AND SPECIFICATIONS ARE INTENDED TO EXPRESS DESIGN INTENT FOR A PROTOTYPICAL STARBUCKS STORE (WHICH IS SUBJECT TO CHANGE AT ANYTIME) AND DO NOT REFLECT ACTUAL SITE CONDITIONS. NEITHER PARTY SHALL HAVE ANY OBLIGATION NOR LIABILITY TO THE OTHER (EXCEPT STATED ABOVE) UNTIL A WRITTEN AGREEMENT IS FULLY EXECUTED BY BOTH PARTIES.

STARBUCKS TEMPLATE VERSION | 2019.01.11

**Design Forum Architects Inc.**

2585 Byrne Rd  
Miamisburg, OH 45342  
Tel: (614) 804-7700

Donald J. Rathman  
Architect in Charge  
License: AR0017303

**Design Forum Engineering**

2585 Byrne Rd  
Miamisburg, OH 45342  
Tel: (614) 804-7700

Timothy L. Harwarding, PE  
Professional Engineer  
License: 62078

**FOR CONSTRUCTION**

PROJECT NAME:  
**HARDEN & POLK**

PROJECT ADDRESS:  
1310 LAKESIDE VILLAGE CIR  
LAKELAND, FL 33803

STORE #: 2965  
PROJECT #: 21120-060  
ISSUE DATE: 08/10/2020  
DESIGNER: RAI MONTERO  
PRODUCTION DESIGNER: PAUL HARLOR  
CHECKED BY: RAI MONTERO

Revision Schedule		
Rev	Date	Description

SHEET TITLE:  
**LIGHTING DESIGN PLAN**  
SCALE: AS SHOWN

SHEET NUMBER:  
**E-102**

Order Plans @

WWW.DIline.com

**STOP**