


**SIGNAGE IS FOR REFERENCE ONLY**

SIGNAGE APPROVALS SHALL BE ACQUIRED UNDER SEPARATE SIGN PERMIT SUBMITTALS. SIGNAGE IS NOT INCLUDED IN THE SCOPE OF THE BUILDING PERMIT.

**LEGEND**

- \*\*\*\*\* EXISTING LANDSCAPE AREA
- EXISTING CONCRETE WALKWAY
- ===== EXISTING 6" (150MM) CONCRETE CURB

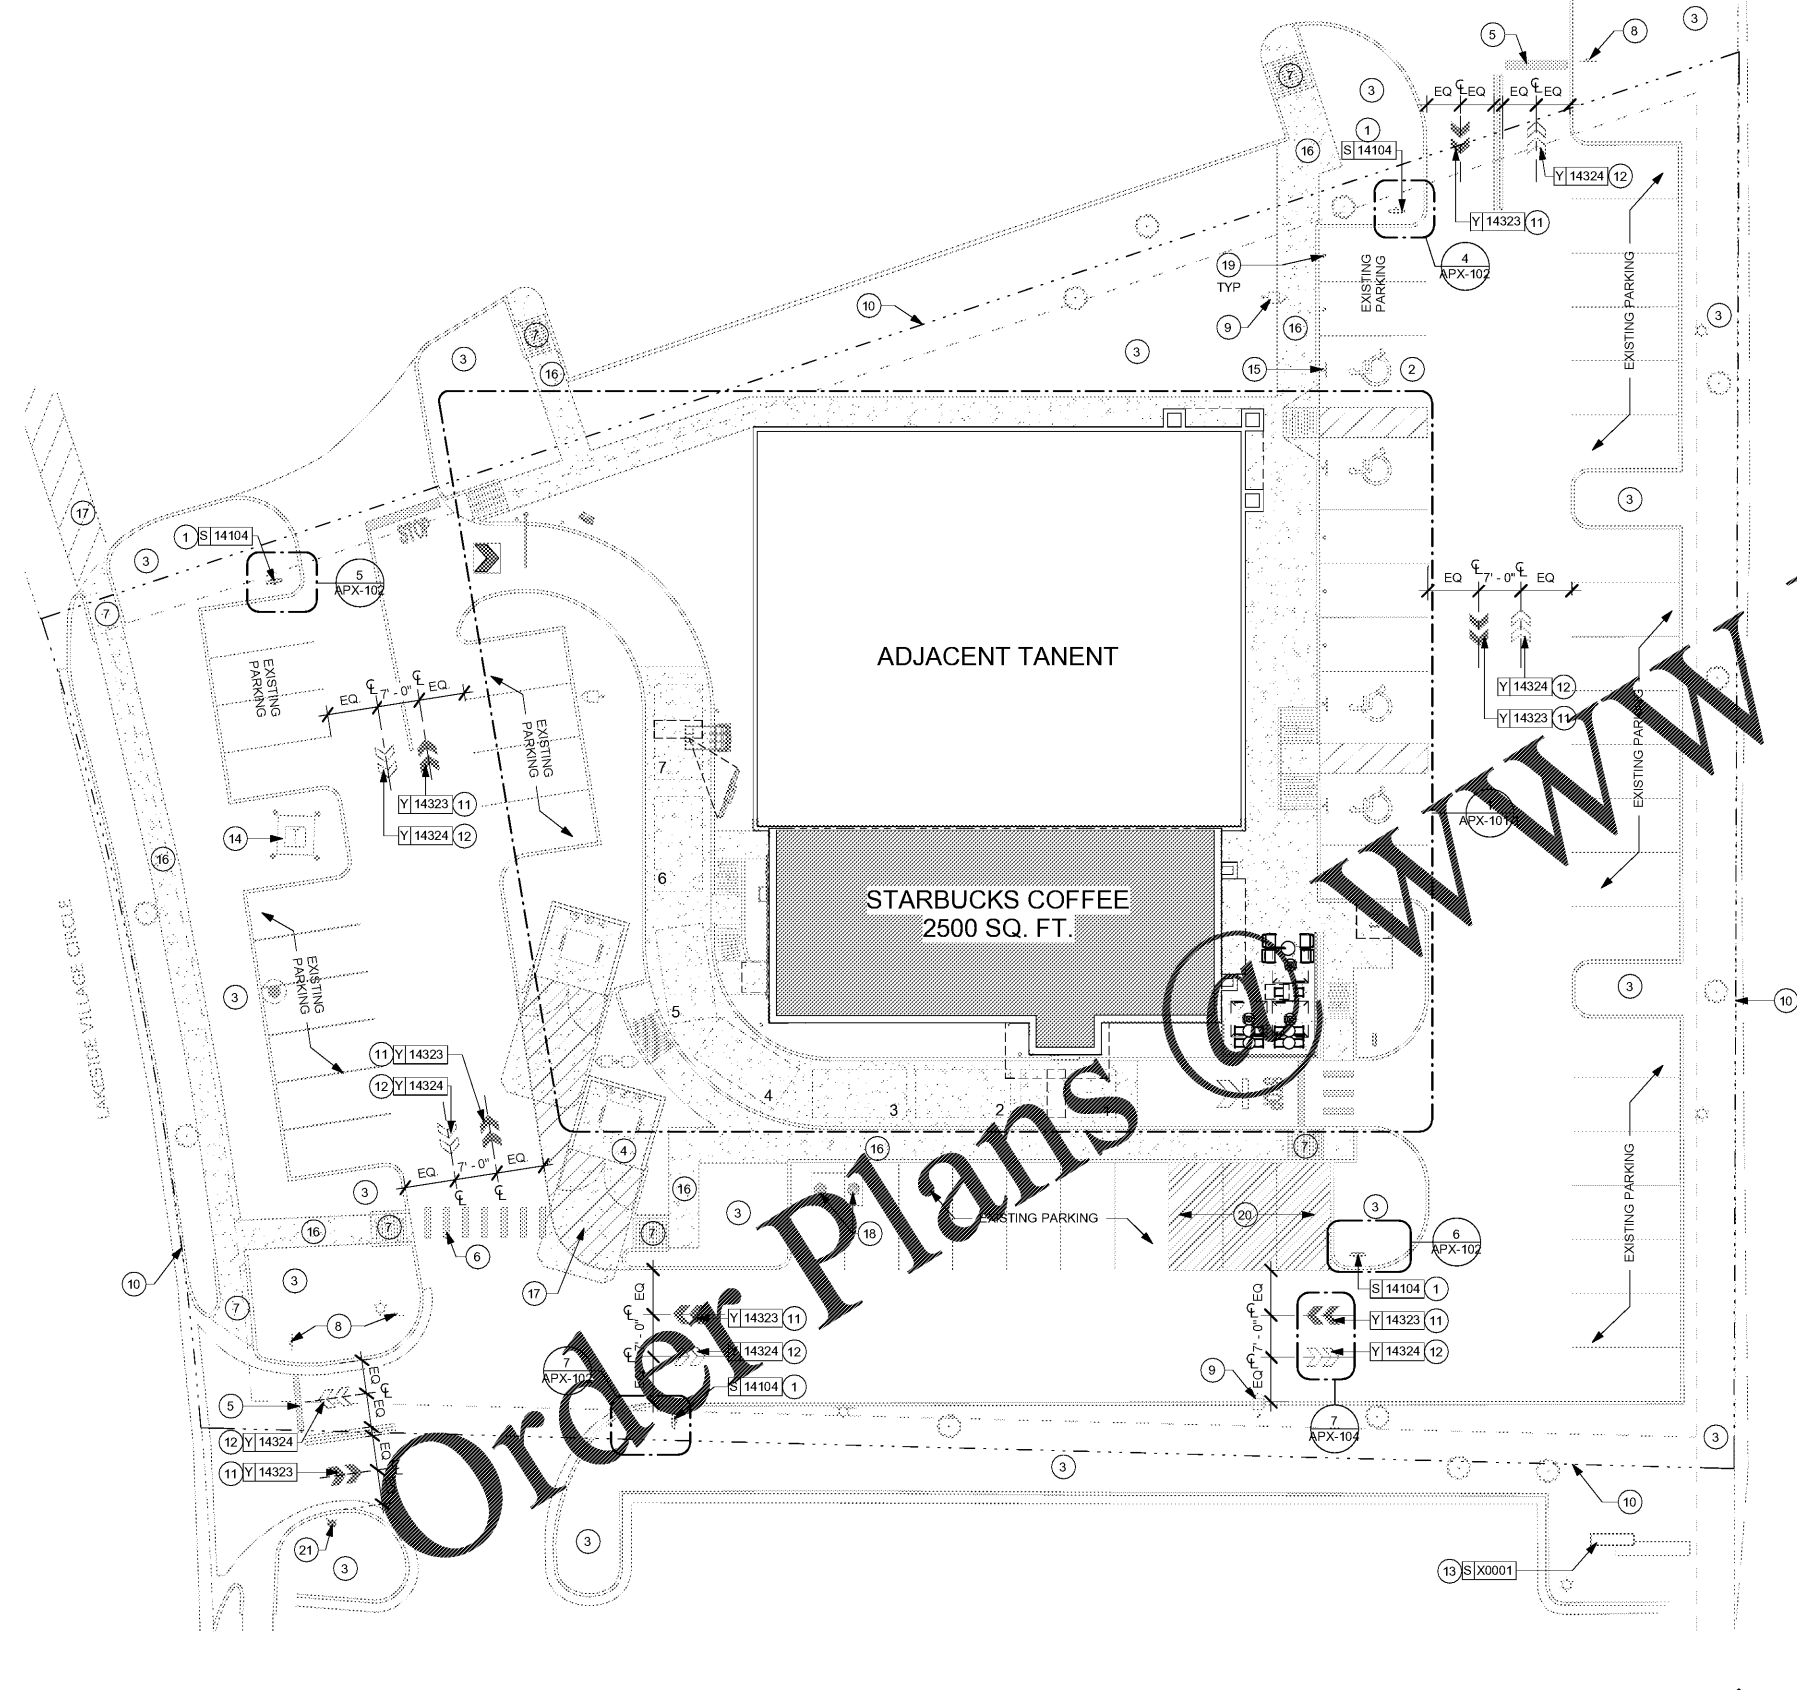

**1 ARCHITECTURAL SITE PLAN**  
Scale: 1/16" = 1'-0"

**RESPONSIBILITY LEGEND**

FURN. BY	INST. BY
SB - FURNISHED BY STARBUCKS	GC - INSTALLED BY GENERAL CONTRACTOR
GC - INSTALLED BY GENERAL CONTRACTOR	SB - INSTALLED BY STARBUCKS
	VD - INSTALLED BY VENDOR

**NOTE:** ALL RESPONSIBILITIES TO BE CONFIRMED WITH STARBUCKS CONSTRUCTION MANAGER PRIOR TO ORDERING / CONSTRUCTION.

**KEYED NOTES**

- SIGNAGE VENDOR TO INSTALL FREESTANDING, ILLUMINATED DRIVE-THRU DIRECTIONAL SIGNAGE. EXISTING CONCRETE FOOTING AND CONDUIT. SEE DETAIL: 4/APX-104.
- EXISTING ADA PARKING AND PARKING SYMBOL.
- EXISTING LANDSCAPING.
- EXISTING TRASH ENCLOSURE WITH CONCRETE PAD.
- EXISTING STOP BAR.
- EXISTING CROSSWALK.
- EXISTING ADA RAMP.
- EXISTING \* STOP\* SIGN.
- EXISTING LIGHT POLE.
- PROPERTY LINE.
- EXISTING DRIVE PAVEMENT DOUBLE ARROW-GREEN. SEE DETAIL: 7/APX-104.
- EXISTING EXIT PAVEMENT DOUBLE ARROW-WHITE. SEE DETAIL: 7/APX-104.
- EXISTING MONUMENT SIGN.
- EXISTING TRANSFORMER WITH CONCRETE PAD.
- EXISTING ADA PARKING SIGN.
- EXISTING SIDEWALK.
- EXISTING STRIPING.
- EXISTING GREASE INTERCEPTOR.
- EXISTING NON-ILLUMINATED CIRCULAR BOLLARD AT PARKING/TRASH ENCLOSURE.
- EXISTING MOP PARKING.
- EXISTING FIRE HYDRANT.

**GENERAL NOTES**

- REFER TO EXTERIOR ELEVATIONS SHEET APX-20 FOR BUILDING SIGNAGE LOCATION AND DESIGN. REFER TO ELECTRICAL PLANS FOR ELECTRICAL REQUIREMENTS.
- LANDSCAPING TO BE PROVIDED PER ZONING CODE AND SUSTAINABILITY REQUIREMENTS.
- DRIVE-THRU EQUIPMENT INCLUDING VEHICLE PROTECTION LOW BEAMLESS COMMUNICATION AND MONITORS SHALL BE COORDINATED BY STARBUCKS CONSTRUCTION MANAGER. REFER TO ELECTRICAL DRAWINGS FOR ADDITIONAL REQUIREMENTS.
- PROVIDE 6" (150MM) THICK CONCRETE PAVING THE LENGTH OF THE DRIVE-THRU LANE, EXTENT TO INCLUDE DRIVE-THRU ENTRY POINT THROUGH WINDOW STANDING PAD.
- GENERAL CONTRACTOR TO APPLY CONCRETE SEALER TO ALL EXTERIOR CONCRETE PATIO AND WALKWAY SURFACES.
- GENERAL CONTRACTOR TO VERIFY ALL EXISTING ELEVATIONS AND BUILDING CONDITIONS IN FIELD PRIOR TO START OF CONSTRUCTION.
- PROVIDE DETECTABLE WARNING (IF APPLICABLE PER LOCAL CODE) AT TRANSITION FROM SIDEWALK TO DRIVE AISLE.
- ACCESSIBLE PARKING SPACES AND ACCESS AISLES SHALL HAVE SURFACE SLOPE NOT TO EXCEED 2% IN ALL DIRECTIONS.
- REFER TO ELECTRICAL DRAWINGS FOR SITE RELATED ELECTRICAL WORK.
- SCRAPE AND REPAINT ALL EXISTING PAINTED SITE FEATURES, INCLUDING, BUT NOT LIMITED TO CURBS, BOLLARDS, RAILINGS AND SITE LIGHTING BASES.
- SEE SHEET APX-102 FOR ARCHITECTURAL SITE DETAILS.

WWW.LDILLINE.COM

**EXTERIOR SIGNAGE SCHEDULE - "S"**

DESIGN ID	COUNT	DESCRIPTION	FURN. BY	INST. BY	COMMENTS
<b>SIGNAGE - DISK</b>					
13164	1	SIGN - DISK SF ILLUMINATED FLUSH MOUNTED EVOLVED - 60IN 1525MM	SB	VD	
<b>SIGNAGE - DRIVE THRU</b>					
14091	1	SIGN - DT DIRECTIONAL EXIT SIGN ILLUMINATED ARROW SERIES - 46IN 1170MM	SB	VD	SEE DETAIL: 5 & 6/APX-104
14104	4	SIGN - DT DIRECTIONAL ILLUMINATED ARROW SERIES WITH LOGO - 46IN 1170MM	SB	VD	SEE DETAIL: 4 & 6/APX-104
14106	1	SIGN - DT CLEARANCE BAR ARROW SERIES FREESTANDING	SB	VD	SEE DETAIL: 2 & 3/APX-104
<b>SIGNAGE - MONUMENT SIGN</b>					
X0001	1	MONUMENT SIGN	EXIST	EXIST	
<b>SIGNAGE - WORDMARK</b>					
18495	1	SIGN - WORDMARK STARBUCKS FLUSH MOUNTED - 14IN 355MM	SB	VD	
18497	1	SIGN - WORDMARK STARBUCKS FLUSH MOUNTED - 18IN 455MM	SB	VD	

**SITE SCHEDULE - "Y"**

DESIGN ID	COUNT	DESCRIPTION	FURN. BY	INST. BY	COMMENTS
<b>EXTERIOR MENU</b>					
14116	1	MENU BOARD - DT DIGITAL ORDER SCREEN - FLAT BLACK MT0028	SB	VD	SEE DETAIL: 1/APX-103.1
14119	1	MENU BOARD - DT 5 PANEL FREESTANDING - 108X65IN 2745X1650MM - FLAT BLACK MT0028	SB	VD	SEE DETAIL: 1/APX-103
14120	1	MENU BOARD - DT PRE MENU FREESTANDING - 36X65IN 915X1650MM - FLAT BLACK MT0028	SB	VD	SEE DETAIL: 4/APX-103
15700	1	MENU BOARD - DT DIGITAL ORDER SCREEN CONTROL BOX	SB	VD	SEE DETAIL: 5/APX-103.1
<b>OTHER</b>					
10042	2	BIKE RACK HOOP	EXIST	EXIST	SEE DETAIL: 10/APX-104
10163	1	DT WINDOW SHELF - 56IN OBSIDIAN PAPERSTONE	EXIST	EXIST	SEE DETAIL: 7/APX-103
14095	1	DT WAYFINDING GRAPHIC EXIT ARROW - WHITE	EXIST	EXIST	SEE DETAIL: 8/APX-104
14101	1	DT WAYFINDING GRAPHIC ENTRY ARROW - GREEN	EXIST	EXIST	SEE DETAIL: 9/APX-104
14163	1	DT ORDER POINT CANOPY FREESTANDING - FLAT BLACK MT0028	SB	VD	SEE DETAIL: 2/APX-103.1
14323	7	DT WAYFINDING GRAPHIC DIRECTIONAL DOUBLE ARROW - GREEN	EXIST	EXIST	REFERENCE PAINT P936 FOR SPECIFICATIONS; SEE DETAIL: 7/APX-104
14324	7	DT WAYFINDING GRAPHIC DIRECTIONAL DOUBLE ARROW - WHITE	EXIST	EXIST	REFERENCE PAINT P935 FOR SPECIFICATIONS; SEE DETAIL: 7/APX-104
X4001	5	CIRCULAR BOLLARD - 6" DIA	EXIST	EXIST	SEE DETAIL: 1/APX-104
X4002	1	PATIO RAILING	EXIST	EXIST	SEE DETAIL: 2/APX-105



**STARBUCKS**  
2401 UTAH AVENUE SOUTH  
SEATTLE, WASHINGTON 98134  
(206) 318-1575

THESE DRAWINGS AND THE PROJECT MANUAL ARE CONFIDENTIAL AND SHALL REMAIN THE SOLE PROPERTY OF STARBUCKS CORPORATION, WHICH IS THE OWNER OF THE COPYRIGHT IN THIS WORK. THEY SHALL NOT BE REPRODUCED IN WHOLE OR IN PART, SHARED WITH THIRD PARTIES OR USED IN ANY MANNER ON OTHER PROJECTS OR EXTENSIONS TO THIS PROJECT WITHOUT THE PRIOR WRITTEN CONSENT OF STARBUCKS CORPORATION. THESE DRAWINGS AND SPECIFICATIONS ARE INTENDED TO EXPRESS DESIGN INTENT FOR A PROTOTYPED STARBUCKS STORE (WHICH IS SUBJECT TO CHANGE AT ANYTIME) AND DO NOT REFLECT ACTUAL SITE CONDITIONS. NEITHER PARTY SHALL HAVE ANY OBLIGATION OR LIABILITY TO THE OTHER EXCEPT AS STATED ABOVE UNTIL A WRITTEN AGREEMENT IS FULLY EXECUTED BY BOTH PARTIES.

STARBUCKS TEMPLATE VERSION: I2020-02-10

**Design Forum Architects Inc.**  
2506 Byers Rd  
Miamisburg, OH 45342  
Tel: (844) 804-7700  
Donald J. Rehrman  
Architect In Charge  
License: AR0017303

**Design Forum Engineering**  
2506 Byers Rd  
Miamisburg, OH 45342  
Tel: (844) 804-7700  
Timothy L. Hadering, PE  
Professional Engineer  
License: 62078

PROJECT NAME:  
**HARDEN & POLK**

PROJECT ADDRESS:  
1310 LAKESIDE VILLAGE CIR  
LAKELAND, FL 33803

STORE #: 2965  
PROJECT #: 21120-060  
ISSUE DATE: 08/17/20  
DESIGNER: RAI MONTERO  
PRODUCTION DESIGNER: ANDY MCLOUD  
CHECKED BY: RAI MONTERO

**Revision Schedule**

Rev	Date	By	Description

SHEET TITLE:  
**ARCHITECTURAL SITE PLAN**  
SCALE: 1/16" = 1'-0"

SHEET NUMBER:  
**APX-101**