




8801 JM Keynes Drive  
Suite 365  
Charlotte, NC 28262  
704.248.2022  
www.biloba.co

Mechanical and Electrical Engineer  
**McKnight Smith Ward Griffin Engineers**  
4223 South Boulevard  
Charlotte, NC 28209  
704.527.2112  
NC Certificate of Licensure: F-0595

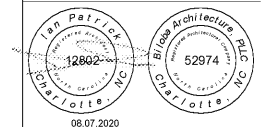

06.07.2020  
Drawn: CADD  
Checked: IWP  
Date: August 7, 2020  
Revisions:

Copyright 2020. All rights reserved. Printed or electronic drawings and documentation may not be reproduced in any form without written permission from Biloba Architecture, PLLC.

**Brown Hall Renovation**

Laurel Street, Brown Hall  
Greensboro, NC 27411  
SCO ID No. 20-22082-01A


Project Number 106

**Floor and Reflected Ceiling Plan**

Sheet

**A102**

Plate of

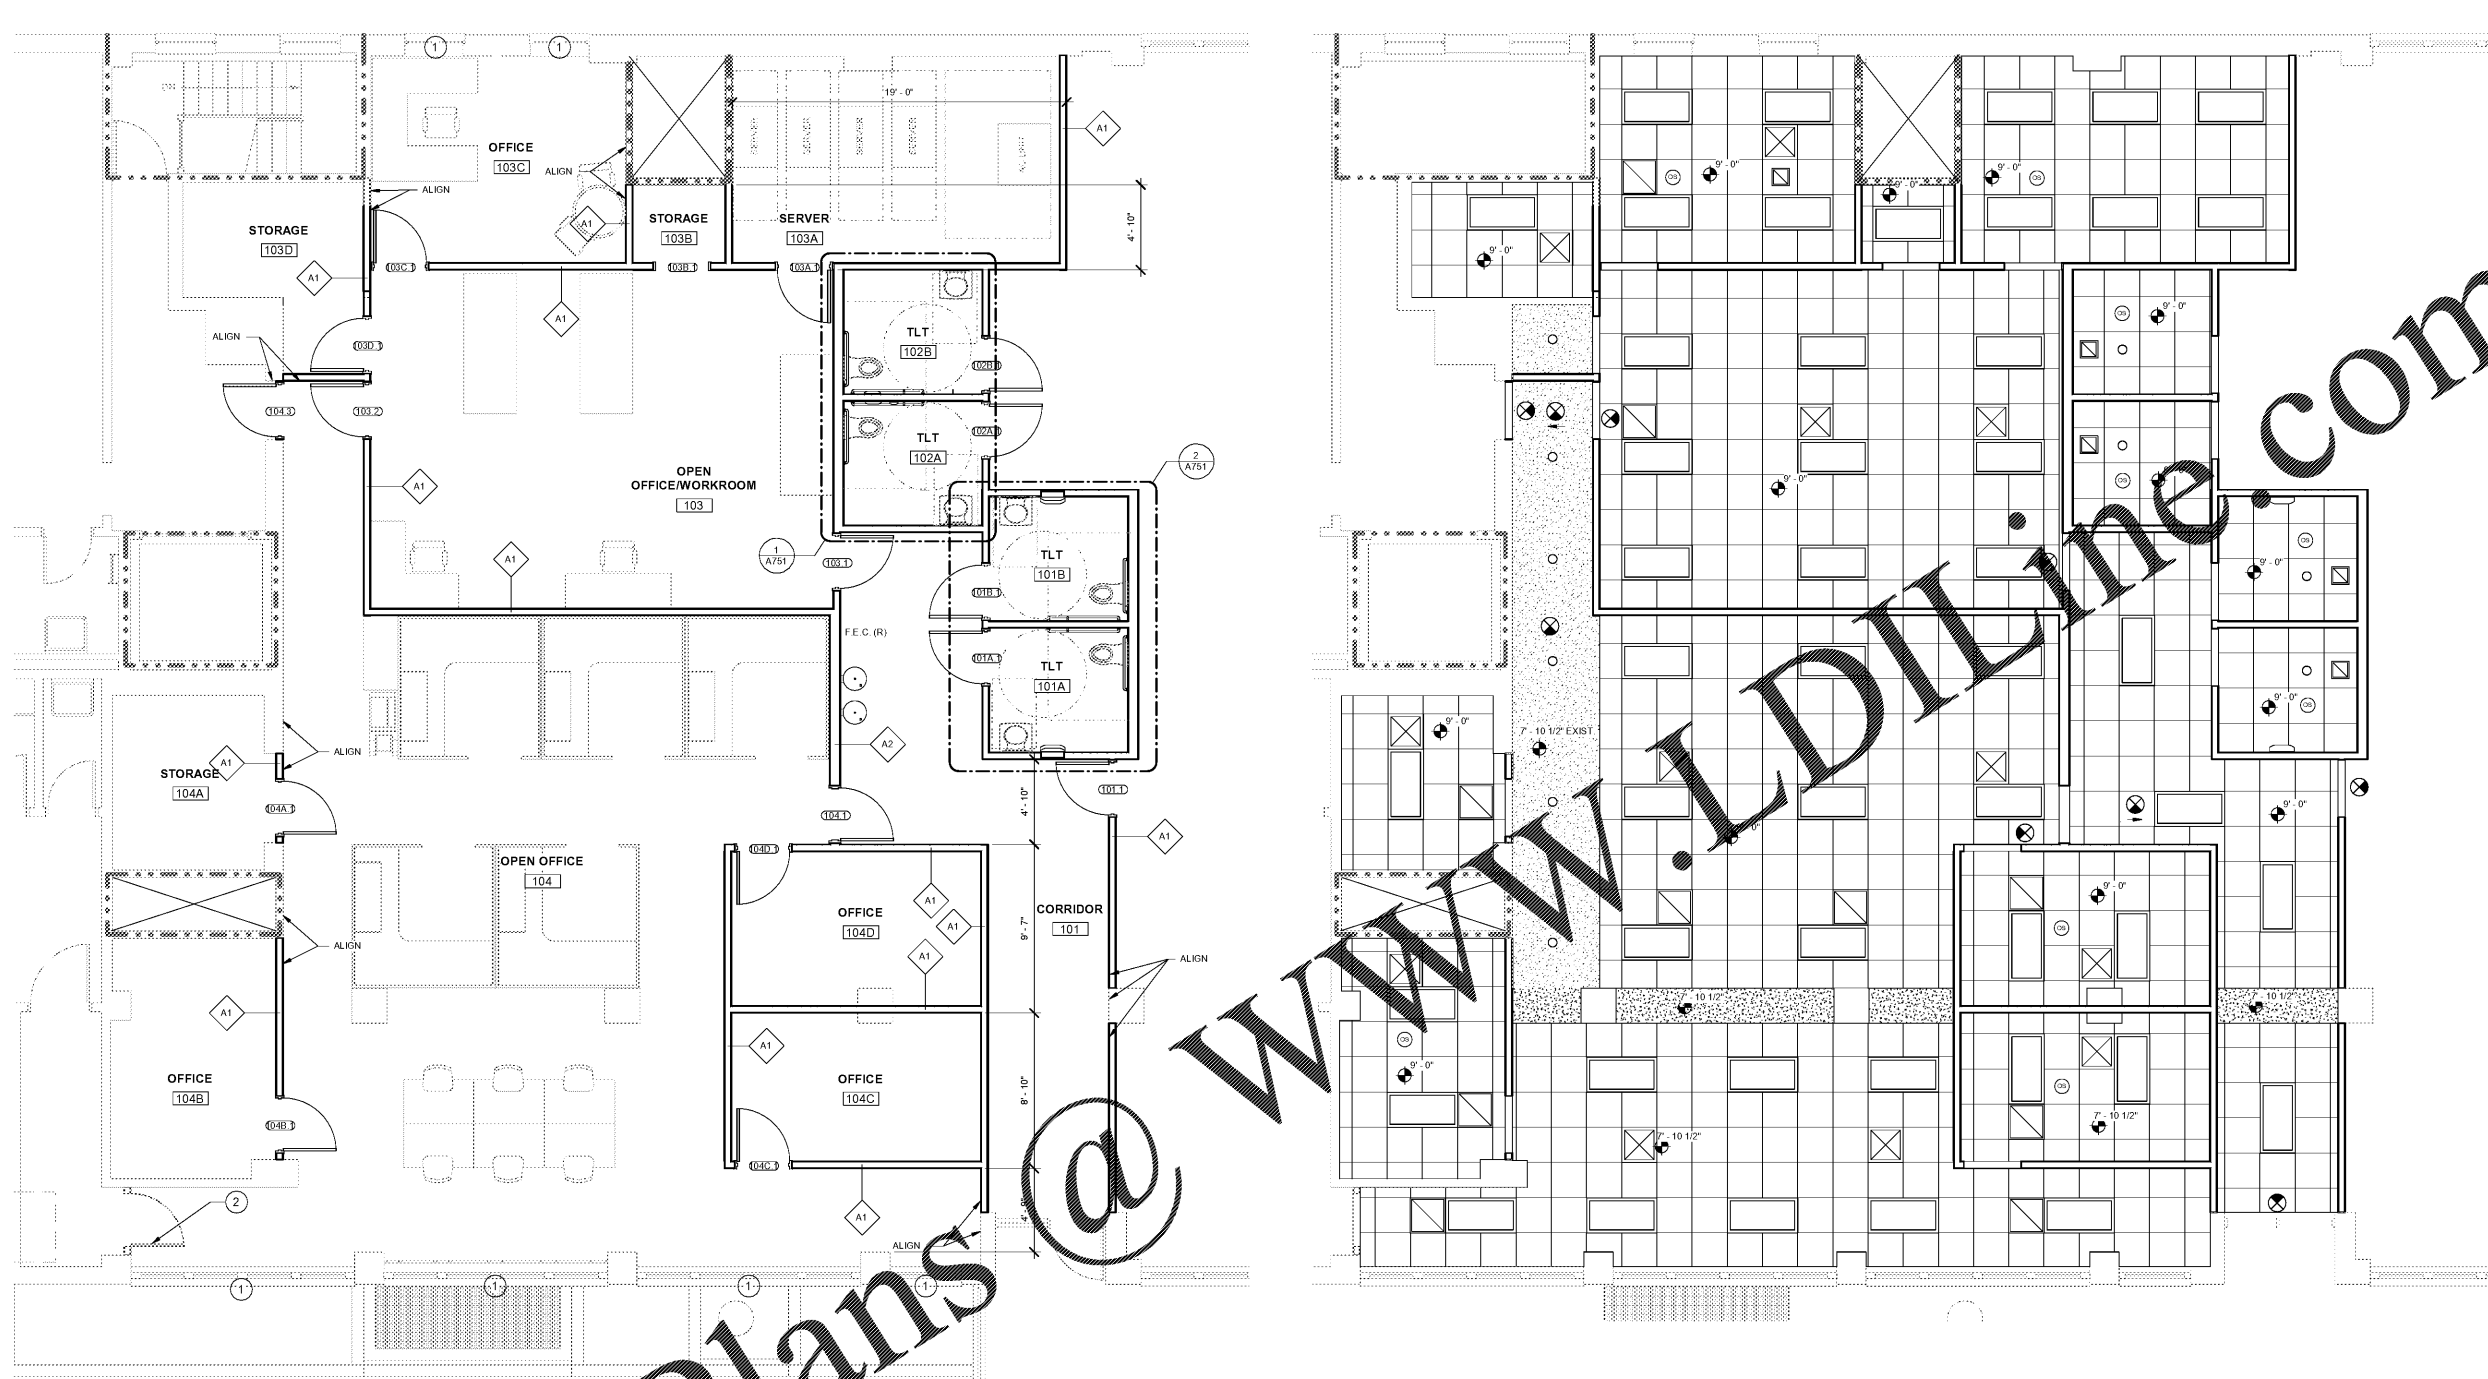

1 SECOND FLOOR NEW WORK  
1/4" = 1'-0"

FURNITURE SHOWN FOR REFERENCE ONLY; FURNITURE N.I.C.

**GENERAL FLOOR PLAN LEGEND**

- PARTITION TYPE
- DOOR NUMBER
- FIRE EXTINGUISHER CABINET (RECESSED)
- 2 HOUR FIRE RATED PARTITION

**GENERAL FLOOR PLAN NOTES**

1. DIMENSIONS ARE TO COLUMN CENTERLINES OR FINISH FLOOR, UNLESS OTHERWISE NOTED.
2. ALL PARTITIONS ARE TO BE "A1" UNLESS OTHERWISE NOTED.
3. SEE ENCLOSED PLANS FOR PARTITION TYPES NOT SHOWN ON FLOOR PLAN.

**NEW WORK KEYNOTES**

NUMBER	DESCRIPTION
1	NEW HORIZONTAL LOUVER BLINDS
2	REFINISH DOOR TO MATCH NEW DOORS

2 REFLECTED CEILING PLAN  
1/4" = 1'-0"

**REFLECTED CEILING PLAN LEGEND**

- ACOUSTICAL PANEL CEILING
- GYP. BD. CEILING/SOFFIT
- SUPPLY AIR GRILLE
- RETURN AIR GRILLE
- RECESSED DOWNLIGHT
- 2 X 4 CEILING LIGHT
- EXIT SIGN - CEILING MOUNTED
- EXIT SIGN - WALL MOUNTED
- OCCUPANCY SENSOR

**GENERAL NOTES**

1. CEILING HEIGHT DIMENSIONS ARE FROM FINISH FLOOR.
2. ALL CEILING ELEMENTS (LIGHT FIXTURES, DIFFUSERS, SPRINKLER HEADS, SMOKE AND HEAT DETECTORS, EXIT SIGNS, AND OTHER DEVICES) ARE TO BE INSTALLED IN THE CENTER OF CEILING PANELS UNLESS OTHERWISE NOTED. SEE MECHANICAL, FIRE PROTECTION, AND ELECTRICAL DRAWINGS FOR TYPE, QUANTITY, AND CONNECTION INFORMATION.
3. CEILING PANELS ARE TO BE CENTERED WITHIN THE SPACE AND SYMMETRICALLY CUT AT WALLS UNLESS INDICATED GRAPHICALLY OR NOTED OTHERWISE.
4. FOR WALL MOUNTED DEVICES, SEE INTERIOR ARCHITECTURAL ELEVATIONS AND ELECTRICAL DRAWINGS FOR ADDITIONAL INFORMATION.
5. PAINT ALL DUCTWORK VISIBLE ABOVE SUPPLY AND RETURN GRILLES MATTE BLACK.

Order Plans @ WWW.DIline.com