



8801 JM Keynes Drive
Suite 365
Charlotte, NC 28262
704.248.2922
www.biloba.co


ELECTRICAL and Electrical Engineer
McKnight Smith Ward Griffin Engineers
4223 South Boulevard
Charlotte, NC 28202
704.527.2112
NC Certificate of License: F-2695
MSWG PROJECT #20-027



08-07-2020

Drawn MGC
Checked BSC
Date August 7, 2020
Revisions

Order Plans @ www.LDILine.com

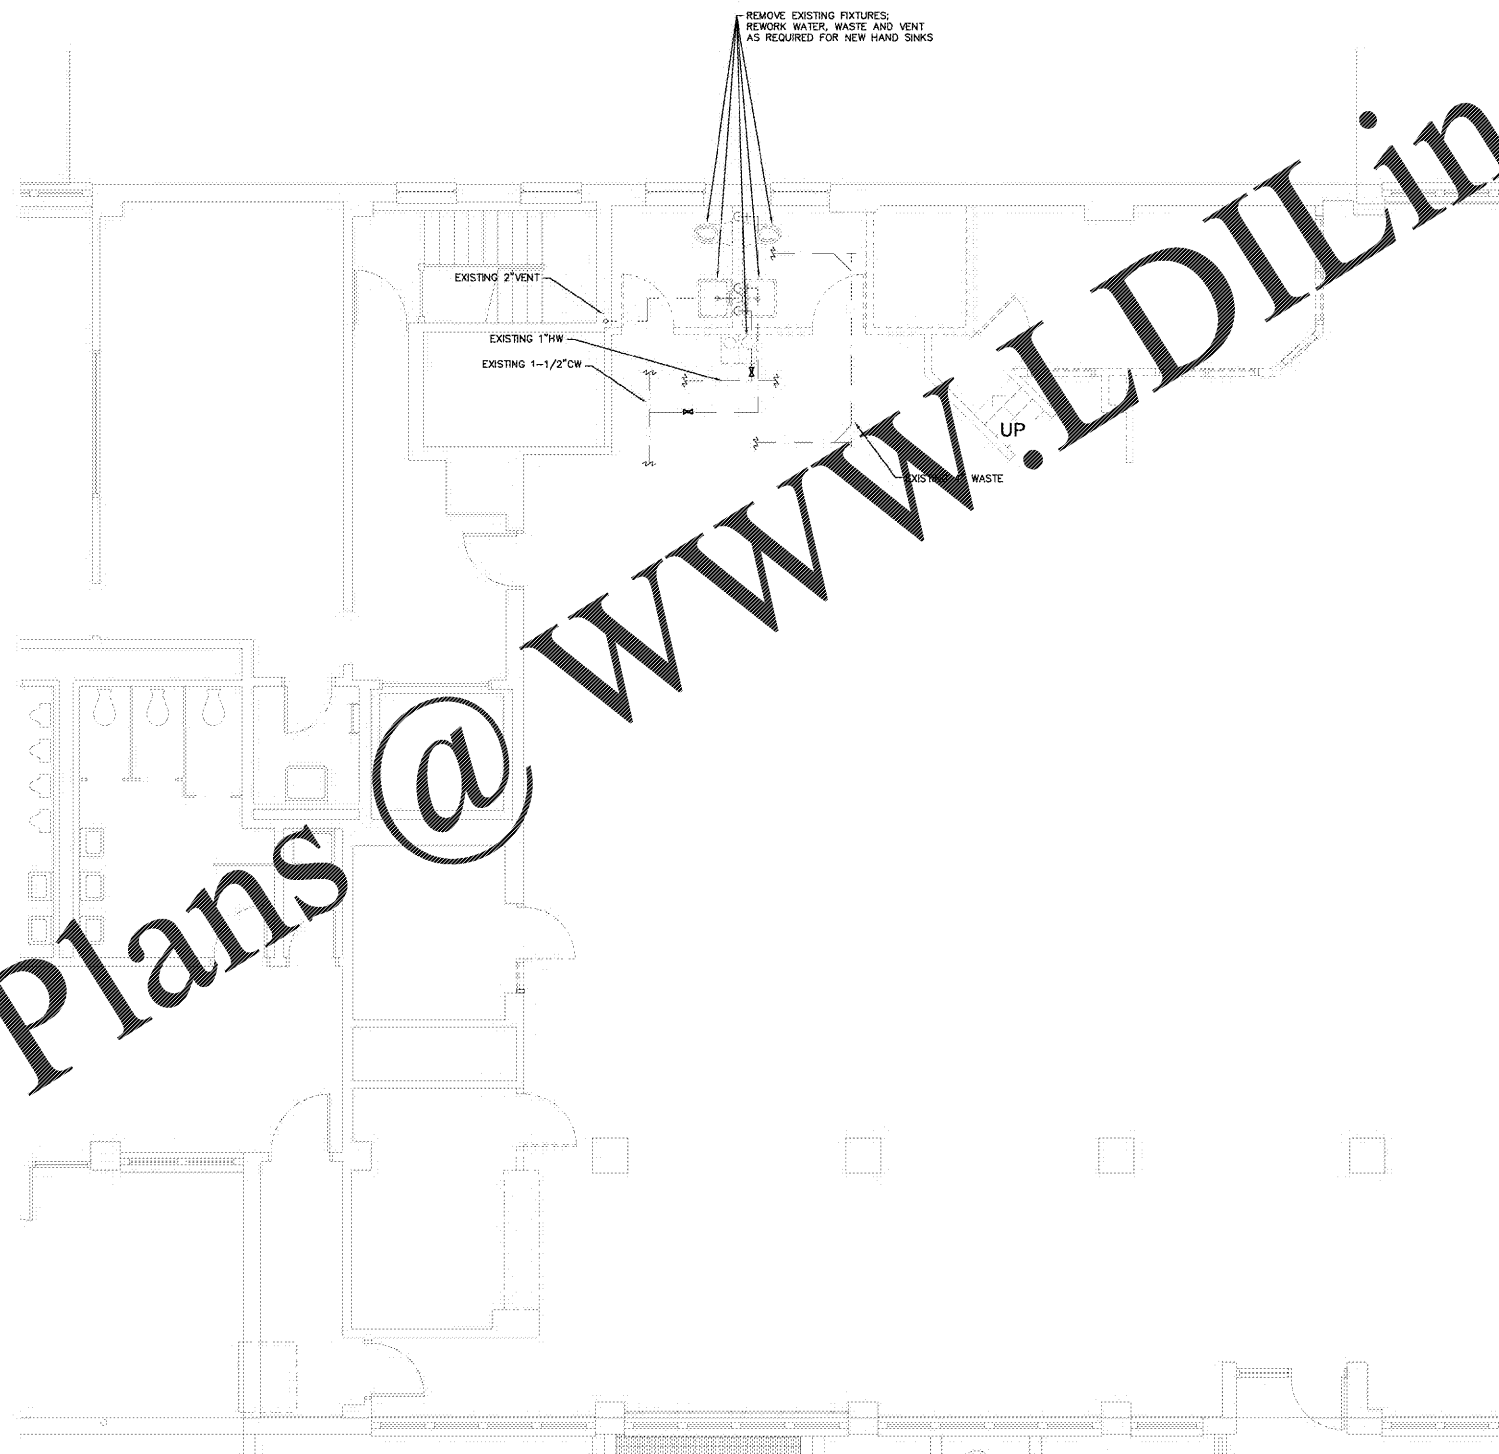

1 FLOOR PLAN - DEMOLITION
SCALE: 1/4" = 1'-0"

NOTE: THE CONTRACTOR IS RESPONSIBLE FOR VERIFYING ALL EXISTING CONDITIONS. SUBMISSION OF BIDS IS CONSIDERED VERIFICATION THAT THE CONTRACTOR HAS VISITED THE SITE. NO EXTRAS WILL BE ALLOWED DUE TO LACK OF KNOWLEDGE OF THE EXISTING CONDITIONS.

Copyright 2020. All rights reserved. Printed or electronic drawings and documentation may not be reproduced in any form without written permission from Biloba Architecture, PLLC.

Brown Hall Renovation

1801 E. Market Street
Greensboro, NC 27411
SCO ID No. 20-22082-01A

Project Number 106

Title
**Floor Plan -
Demolition**

Sheet

P101

Plate of