



8601 JM Keynes Drive
 Suite 365
 Charlotte, NC 28262
 704.248.2922
 www.biloba.co

ELECTRICAL and Electrical Engineer
McKnight Smith Ward Griffin Engineers
 4223 South Boulevard
 Charlotte, NC 28202
 704.527.2112
 NC Certificate of License: F-2595
 MSWG PROJECT #20-027



08-07-2020

Drawn: MDK
 Checked: MPA
 Date: August 7, 2020
 Revisions:


Copyright 2020. All rights reserved. Printed or electronic drawings and documentation may not be reproduced in any form without written permission from Biloba Architecture, PLLC.

Brown Hall Renovation
 1801 E. Market Street
 Greensboro, NC 27411
 SCO ID No. 20-22082-01A

Project Number: 106
 Title: Upper Level Electrical Plan - Lighting

Sheet: E201

WALL RATING LEGEND
 --- 2 HOUR FIRE RATED PARTITION
 Plate of

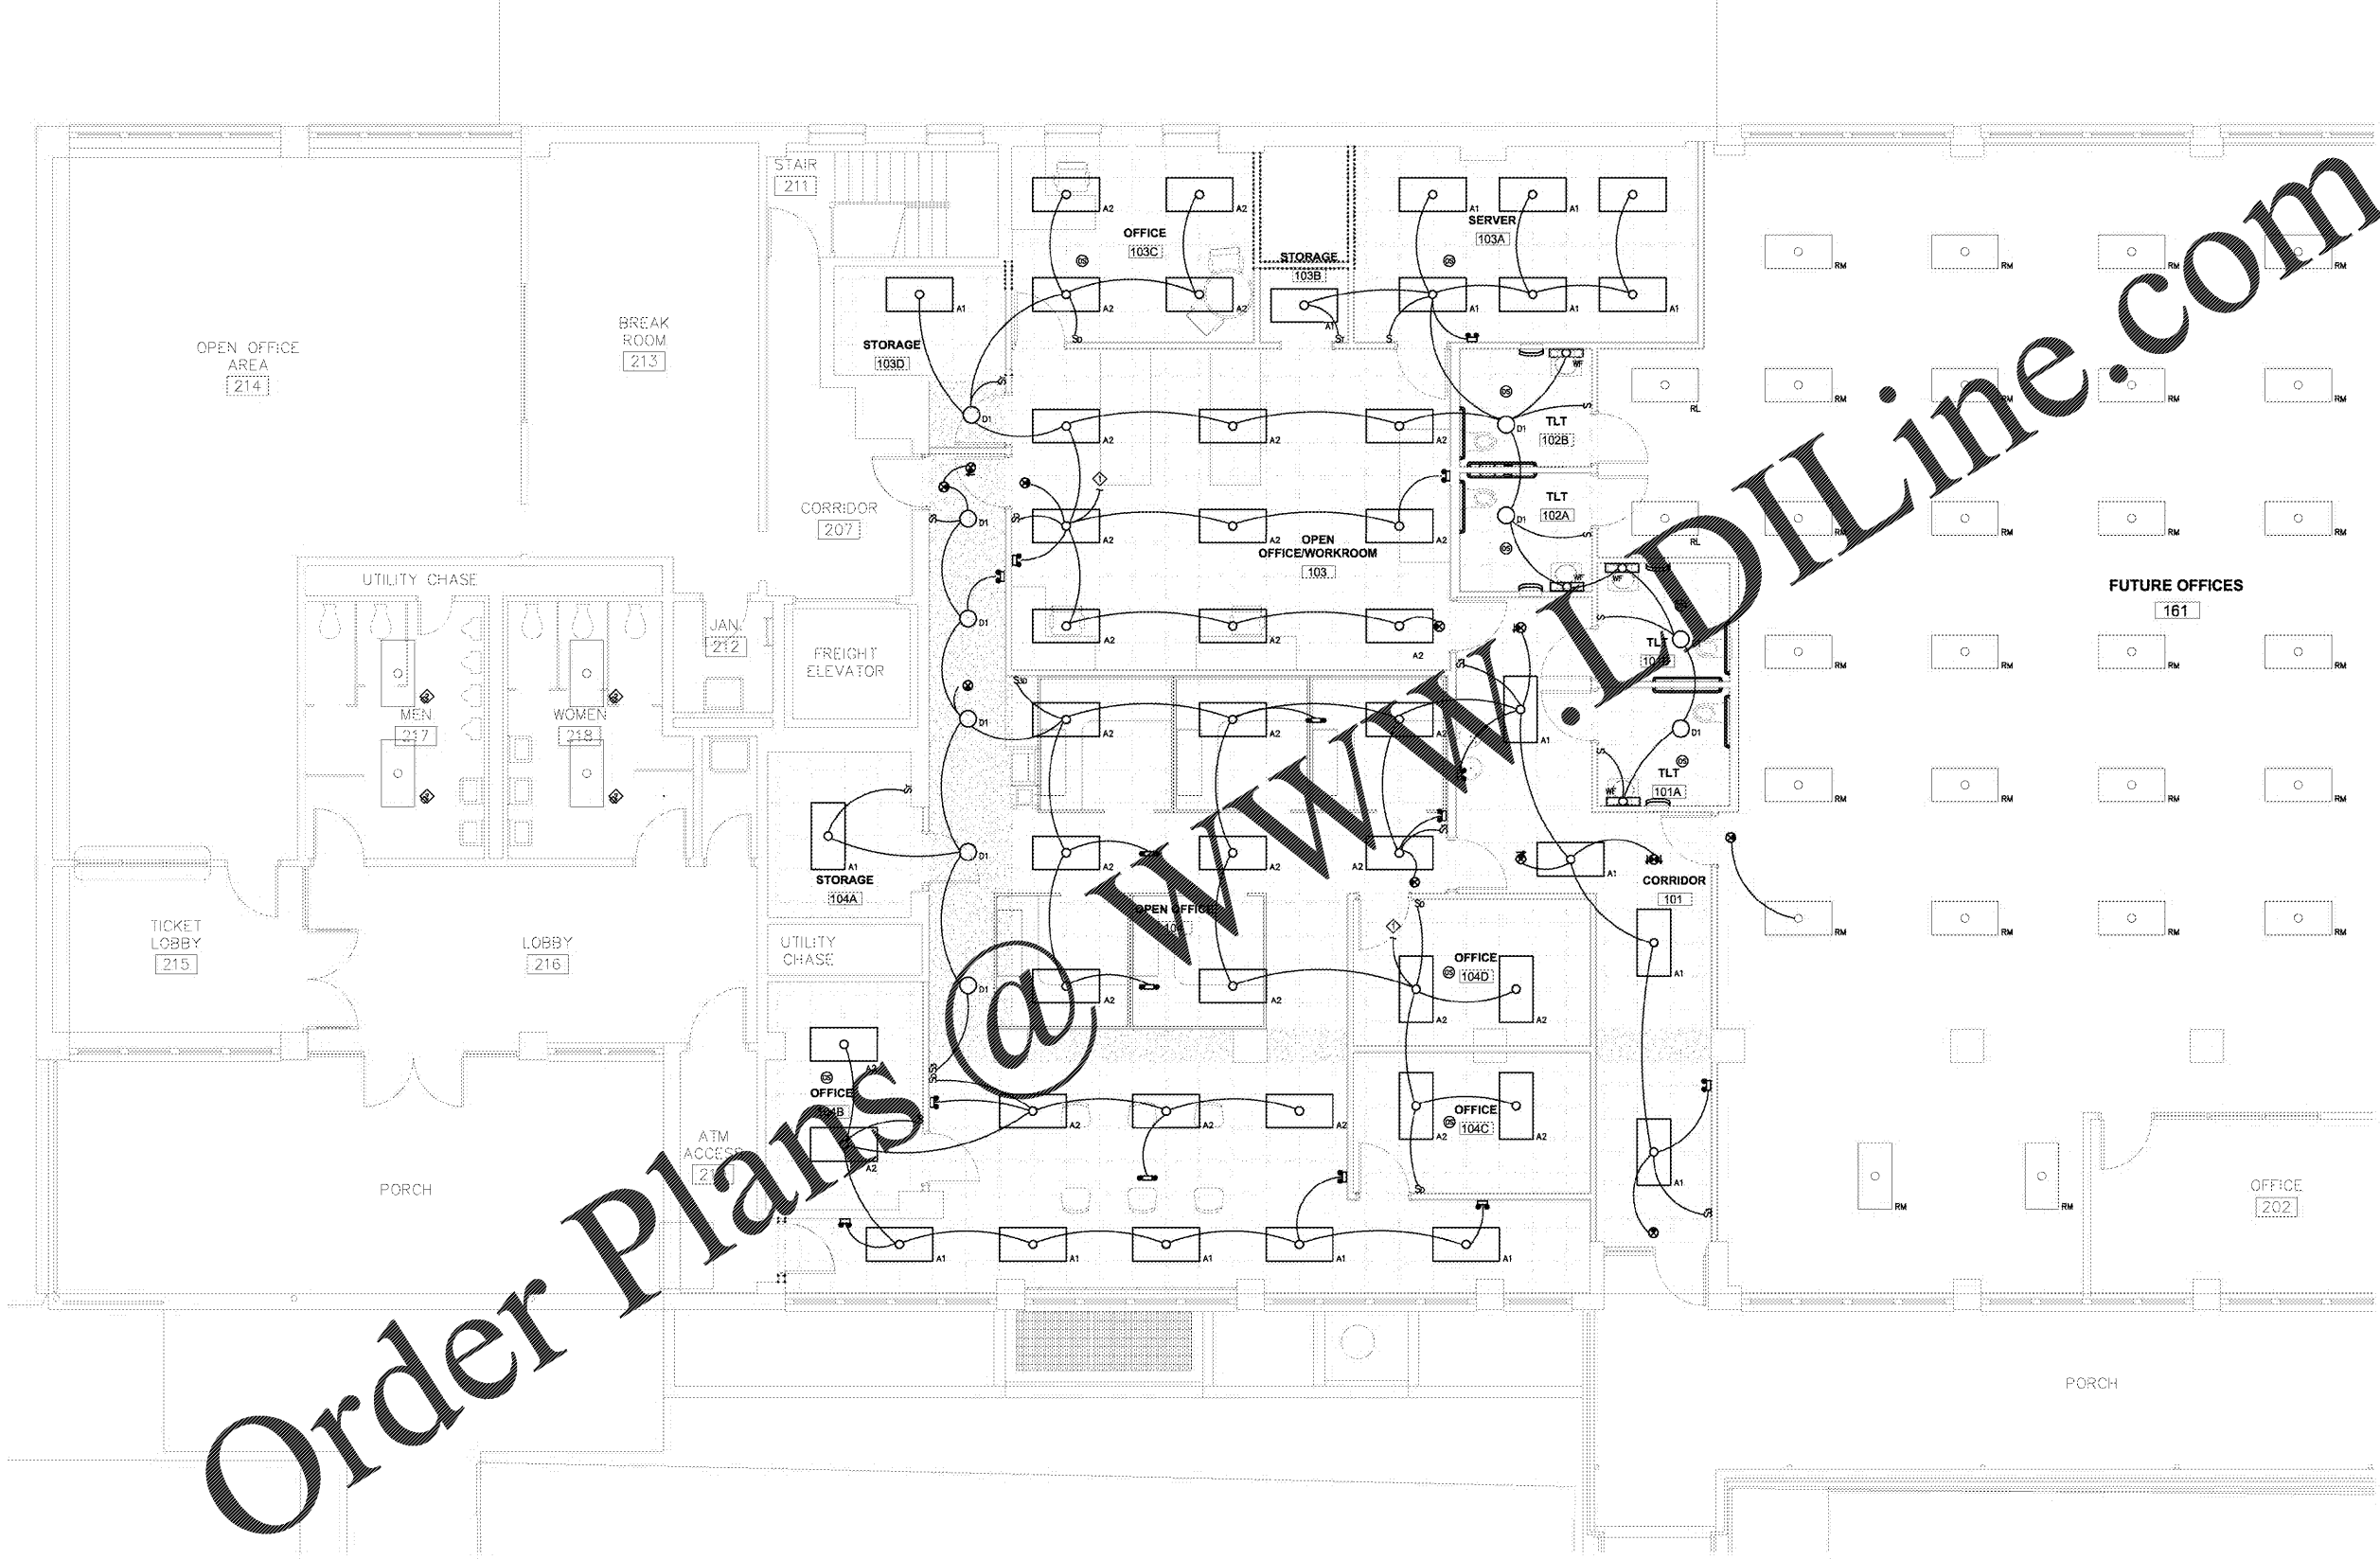

WWW.DILine.com
 Order Plans

1 UPPER LEVEL ELECTRICAL PLAN - LIGHTING
 SCALE: 1/4" = 1'-0"

RENOVATION LEGEND
 RL - EXISTING TO BE RELOCATED
 RM - EXISTING TO REMAIN

NOTES:
 1. CONNECT TO EXISTING 120V LIGHTING CIRCUIT IN THIS AREA WITH 2#12, 1#12G, 1/2" C.
 2. UNDER BASE BID, EXISTING LIGHT FIXTURE TO REMAIN. UNDER ALTERNATE NO. 4, REPLACE EXISTING FLUORESCENT LIGHT FIXTURE WITH NEW SURFACE MOUNTED LIGHT FIXTURE SWI.