


**GENERAL NOTES:**

- DO NOT SCALE DRAWINGS. VERIFY ALL CONDITIONS AND DIMENSIONS BEFORE PROCEEDING. NOTIFY ARCHITECT IF DISCREPANCIES ARE ENCOUNTERED.
- ALL GYPSUM WALLBOARD CEILINGS ARE ATTACHED DIRECTLY TO CEILING FRAMING UNLESS NOTED OTHERWISE.
- COORDINATE FINAL FIXTURE LOCATIONS WITH OTHER TRADES. CENTER FIXTURES IN GRIDS OR ROOM UNLESS NOTED OTHERWISE.
- PROVIDE MOISTURE RESISTANT GYPSUM WALLBOARD IN ALL TOILETS.
- SEE ELECTRICAL DRAWINGS FOR COORDINATION OF ALL ELECTRICAL ITEMS SHOWN IN CEILING PLAN.
- SEE MECHANICAL DRAWINGS FOR COORDINATION OF ALL MECHANICAL ITEMS SHOWN IN CEILING PLAN.
- ALL CEILING HEIGHTS SHOWN ON PLAN ARE A.F.F.
- REFER TO FINISH SCHEDULE AND IDENTIFICATION FOR CEILING MATERIAL CLARIFICATION.
- PROVIDE 6" ACOUSTICAL BATT INSULATION ABOVE ALL LAY-IN CEILINGS.

 
**CEILING LEGEND:**

- 9'-0" CEILING HEIGHT
- 2x4 RECESSED LED
- 1x6.5 DENTAL TRACK LIGHT
- 48" LED FIXTURE
- LIGHT FIXTURE - RECESSED CAN LIGHT
- CEILING MOUNTED EXIT SIGN
- SMOKE DETECTOR
- SPRINKLER HEAD- CENTER IN CEILING TILE
- WALL SCONCE TO BE DETERMINED
- WALL SCONCE HUBBARTON FORGE FLUX SCONCE #303090
- PENDANT FIXTURE TO BE DETERMINED
- SUPPLY GRILL
- RETURN GRILL

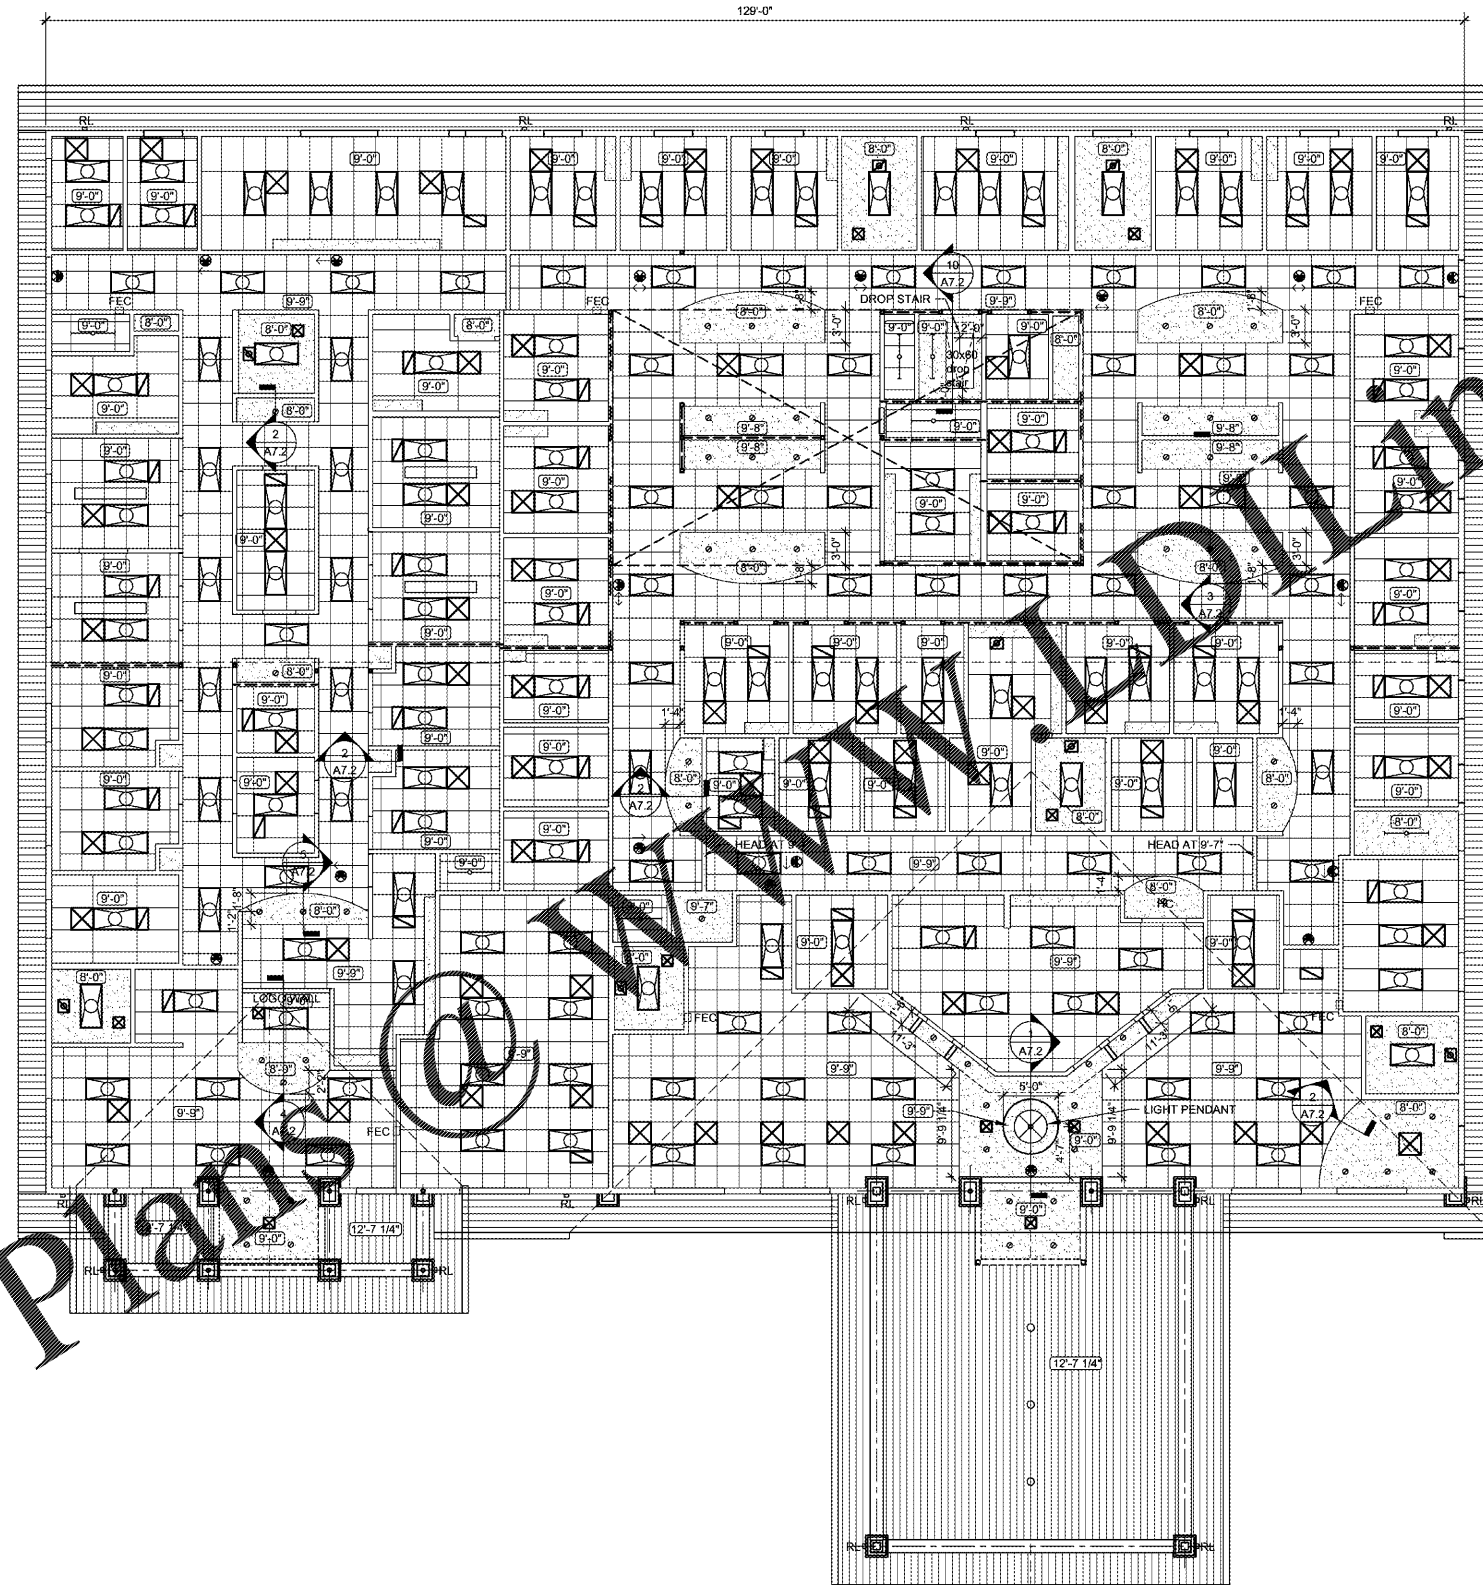

**REFLECTED CEILING PLAN**

SCALE: 1/8" = 1'-0"



ISSUE DATES

INITIAL	DATE
1.	09-04-2020
2.	
3.	
4.	
5.	
6.	