
 


Sprinkler Head Legend	
●	Pendent Sprinkler Head
▼	Sidewall Sprinkler Head
◻	Dry Sidewall Sprinkler Head
○	Upright Sprinkler Head

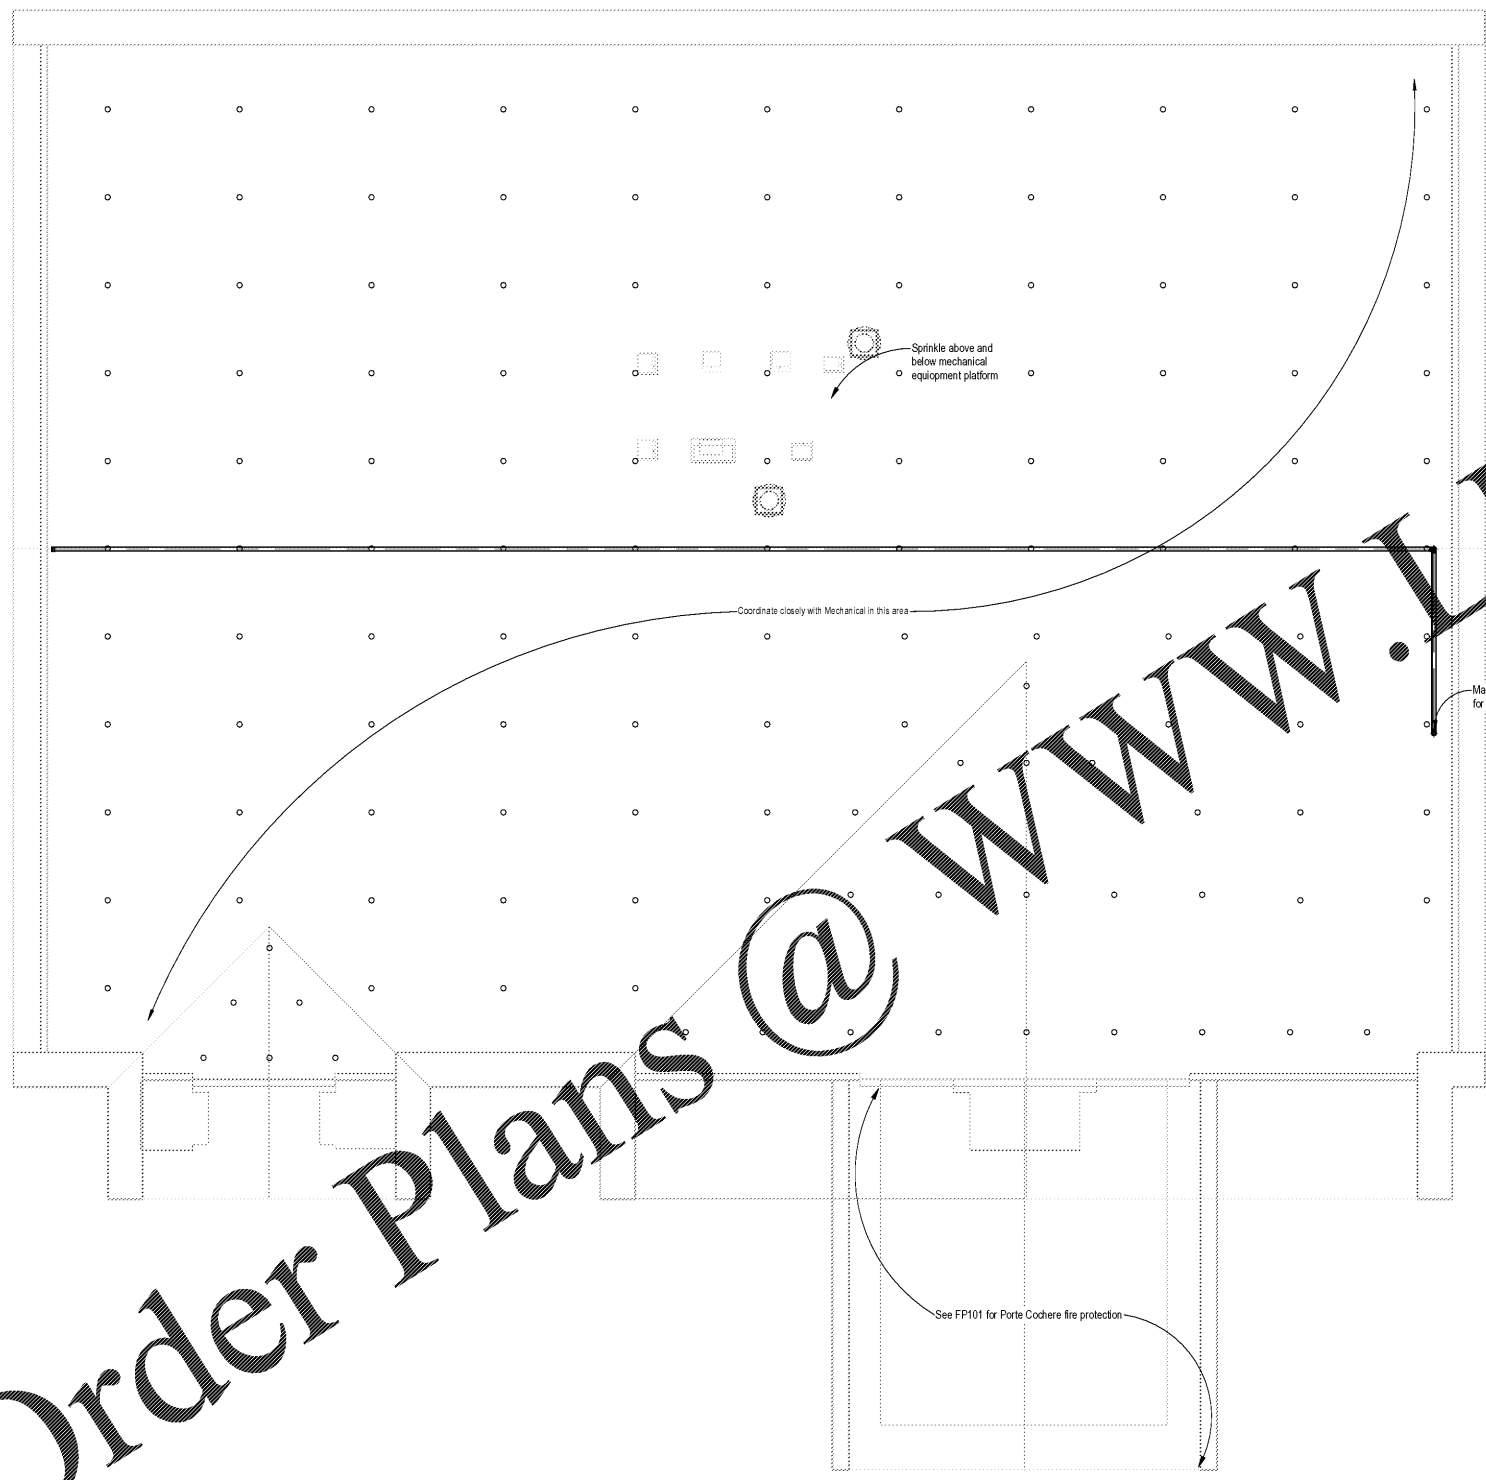


Order Plans @ [www.LDILine.com](http://www.LDILine.com)

**1 ATTIC LEVEL FIRE PROTECTION PLAN**  
SCALE: 1/8" = 1'-0"



**ARTECH**  
1410 COWART STREET  
CHATTANOOGA, TN 37408  
423.265.4313  
WWW.ARTECH.PRO

**GEORGIA MOUNTAINS  
HEALTH SERVICES, INC.**  
HIGHLAND CROSSING SOUTH  
TRACT G  
EAST ELLIJAY, GEORGIA

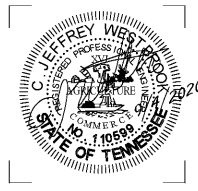

ISSUE DATES  
INITIAL ISSUE 09-04-2020

JOB NO. 19-068 | DWN | CK'D  
jdg | cjw

**March  
Adams &  
Associates**  
Consulting Engineers  
310 Dodds Ave.  
P.O. Box 3689  
Chattanooga, Tennessee 37404  
PH: (423)698-6675  
MAA #: 20109

**FP1.2**  
ATTIC LEVEL FIRE  
PROTECTION