


SHEET NOTES:
 1. All AHU Condensate Lines to be Plan to Mezzanine Drain
 2. (IT Room 154) Will Have a 30" x 60" Mezzanine Access Panel w/ Drop Down Ladder for Installation and Maintenance of AHU's per IMC Section 306.


ARTECH
 1410 COMART STREET
 CHATTANOOGA, TN 37408
 423.265.4313
 WWW.ARTECH.PRO

**GEORGIA MOUNTAINS
 HEALTH SERVICES, INC.**
 HIGHLAND CROSSING SOUTH
 TRACT G
 EAST ELLIJAY, GEORGIA

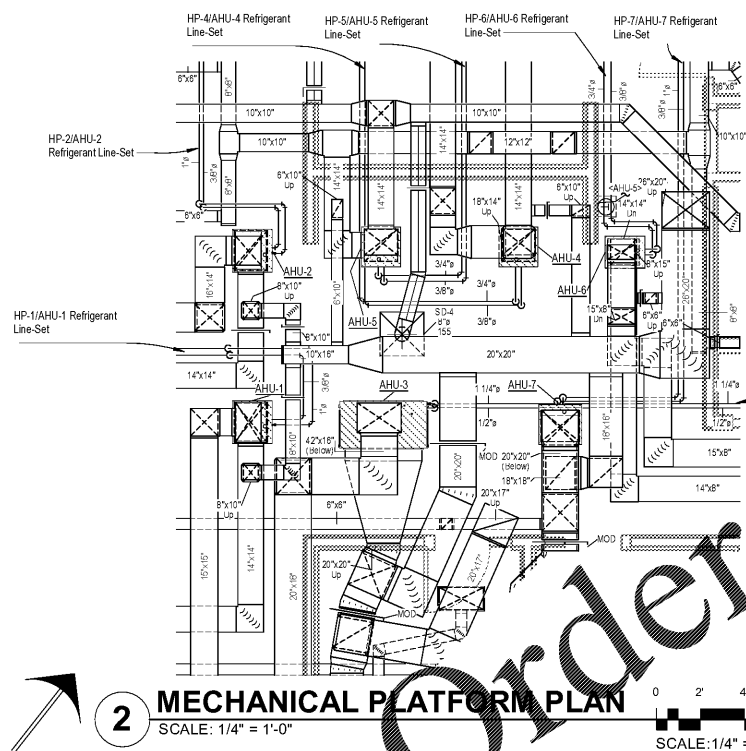

NOTE:
 Coordinate Closely with Fire Protection Contractor on Mechanical Equipment Platform

1 MECHANICAL PLAN
 SCALE: 1/8" = 1'-0"

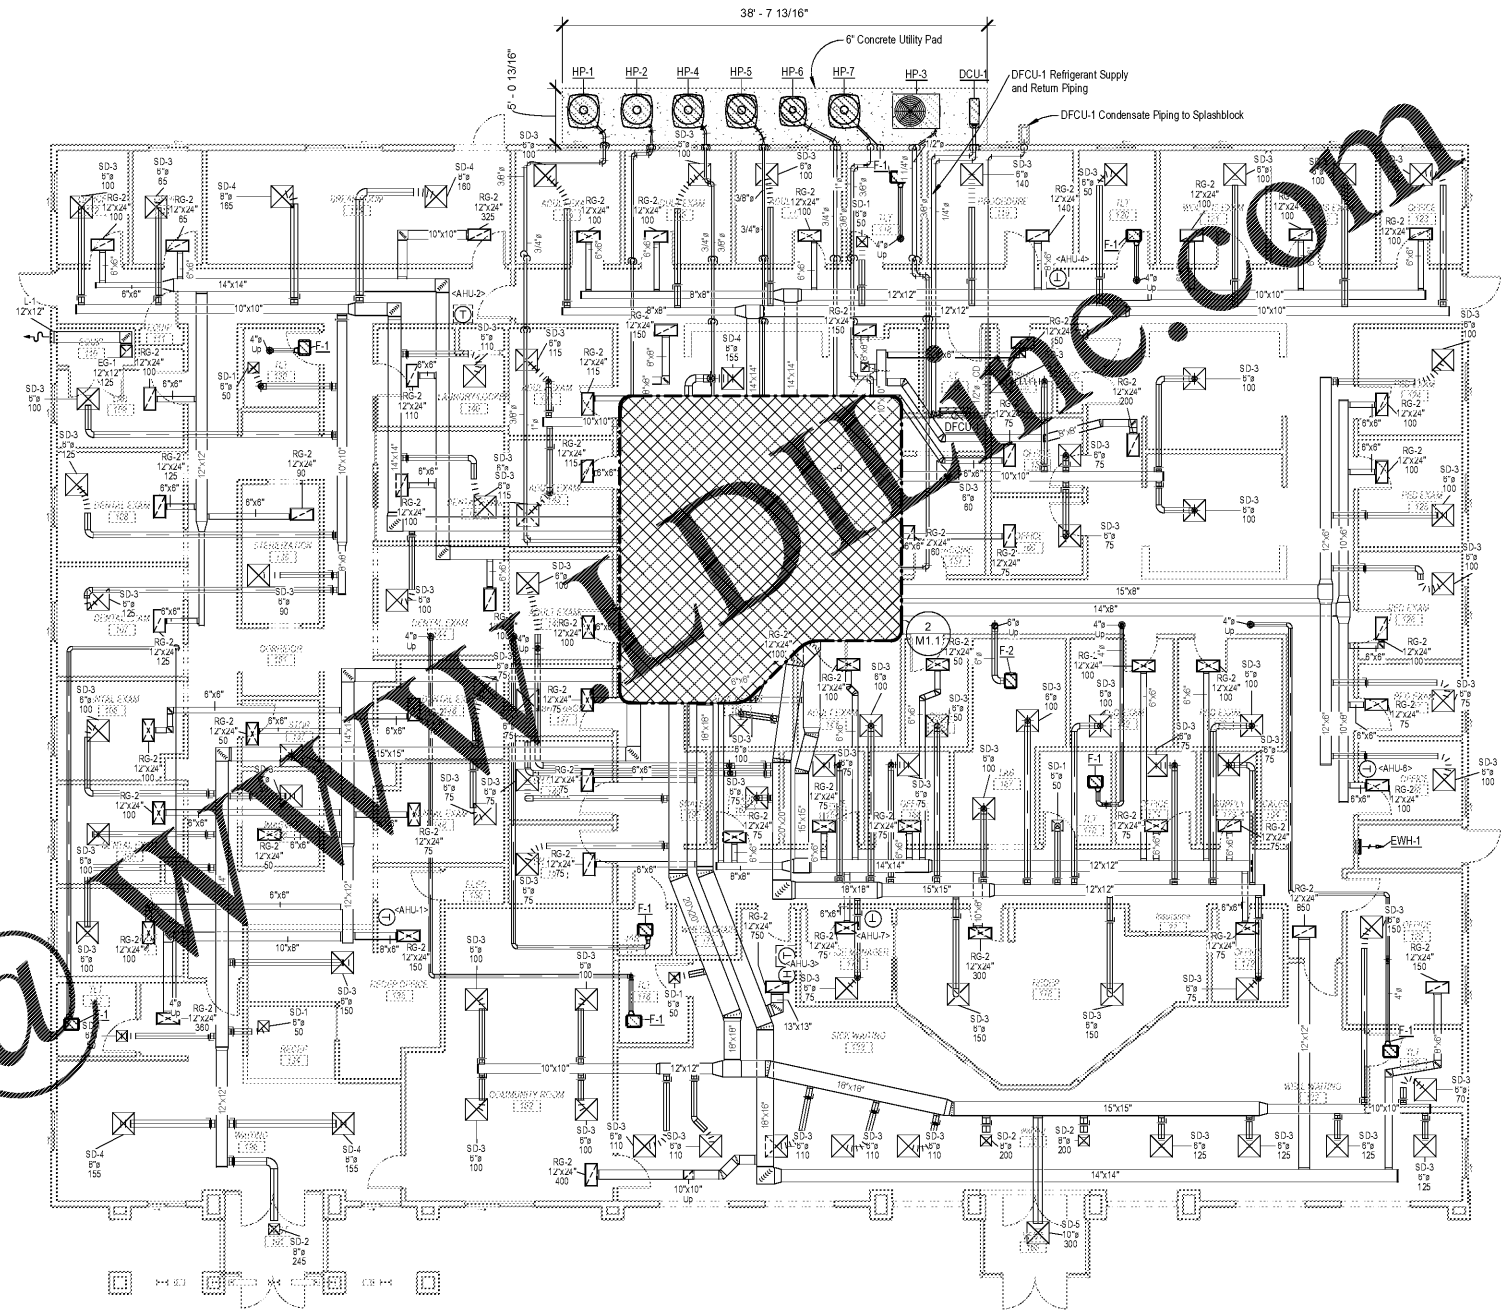

0 4 8 16'
 SCALE: 1/8" = 1'-0"



ISSUE DATES
 INITIAL ISSUE 09/04/2020

JOB NO. 19-068 | DWN JG/BSB | CKD C/JW

March Adams & Associates
 Consulting Engineers
 310 Dodds Ave.
 P.O. Box 3689
 Chattanooga, Tennessee 37404
 PH: (423)698-6675
 MAA #: 20109

M1.1
 MECHANICAL PLAN