



Keynote Legend	
Key Value	Keynote Text
1	Roof Cap - Greenheck RFC-7

Note:
Refer to Manufacturer's Installation Guide for Roof Cap and Ventilator Curbs

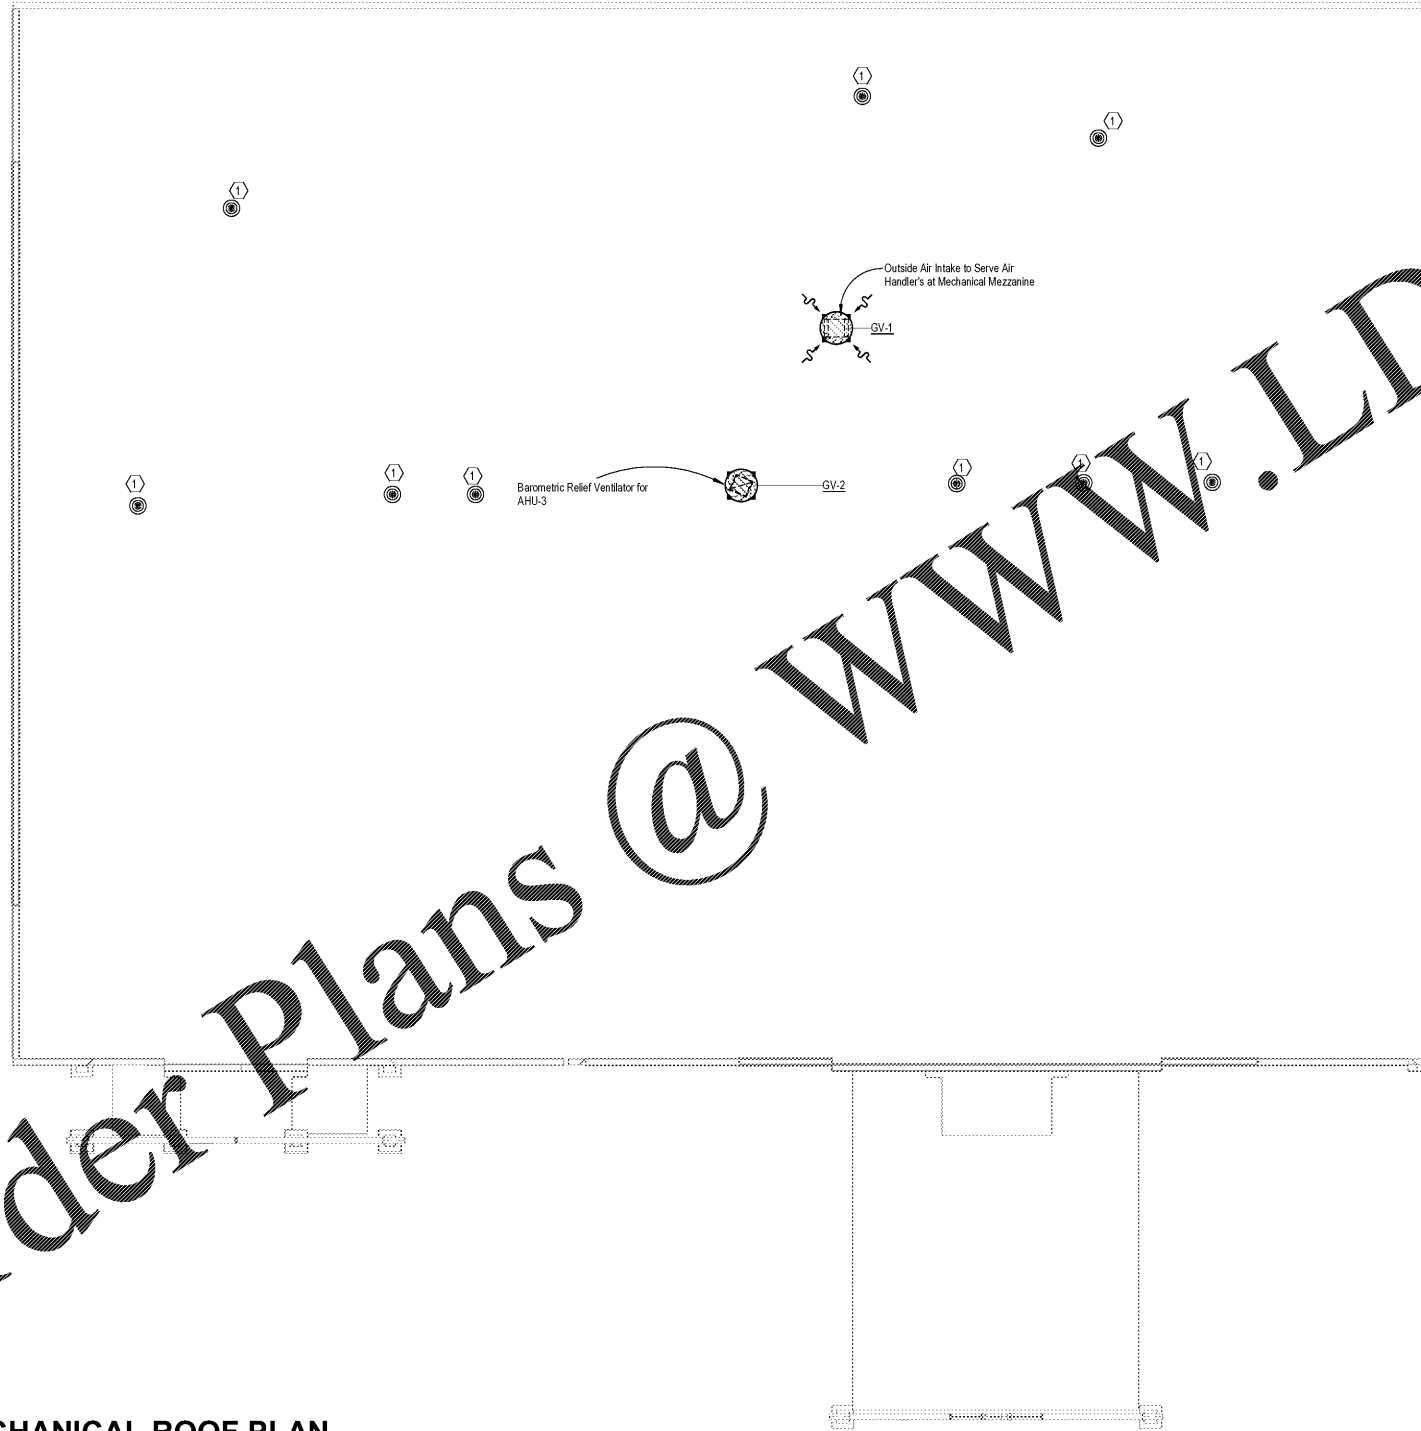

Order Plans @ www.LDILine.com

 1 MECHANICAL ROOF PLAN
SCALE: 1/8" = 1'-0"



ARTECH
1410 COWART STREET
CHATTANOOGA, TN 37408
423.265.4313
WWW.ARTECH.PRO

**GEORGIA MOUNTAINS
HEALTH SERVICES, INC.**
HIGHLAND CROSSING SOUTH
TRACT G
EAST ELLIJAY, GEORGIA



ISSUE DATES
INITIAL ISSUE 09/04/2020

JOB NO. 19-068 | DWN BSB | CK'D CJW
M2.1
MECHANICAL ROOF PLAN

March Adams & Associates
Consulting Engineers
310 Dodds Ave.
P.O. Box 3689
Chattanooga, Tennessee 37404
PH: (423)698-6675
MAA #: 20109