


**GENERAL PLAN NOTES**

1. PROVIDE FOUR EACH TYPE "G" STRIP LIGHTS IN ATTIC SPACE AT HVAC UNITS. SPACE EVENLY BETWEEN UNITS. PROVIDE ON/OFF SWITCH AT ATTIC ACCESS STAIR.


**KEYNOTE LEGEND**

MARK	KEYNOTE TEXT
1	LOCATION FOR LIGHTING CONTROLS FOR WAITING AREA LIGHTING. PROVIDE 0-10V DIMMER FOR CONTROL OF WELL WAITING TYPE 'A' FIXTURES. 0-10V DIMMER FOR CONTROL OF SICK WAITING TYPE 'A' FIXTURES. 0-10V DIMMER FOR CONTROL OF WAITING TYPE 'CL' FIXTURES. SWITCH FOR CONTROL OF WAITING TYPE 'M' FIXTURE. AND SWITCH FOR CONTROL OF WAITING TYPE 'S' FIXTURES. FIELD COORDINATE LOCATION WITH THE OWNER PRIOR TO DOING ANY WORK.
2	RUN CIRCUIT THRU LIGHTING CONTACTOR. CONTACTOR TO BE CONTROLLED BY TIMECLOCK & PHOTOCELL ASSEMBLY.
3	MOUNT FIXTURE ON WALL CENTERED OVER DOOR WITH BOTTOM OF FIXTURE 3" ABOVE DOOR FRAME. COORDINATE WITH AWNING OVER DOOR.
4	MOUNT FIXTURE HIGH ON WALL WITH CENTER OF FIXTURE AT 7'0" A.F.F.
5	MOUNT FIXTURE ON WALL AS HIGH AS POSSIBLE TO LEAVE CEILING CLEAR.
6	REFER TO ARCHITECTURAL ELEVATIONS FOR MOUNTING HEIGHT OF THIS FIXTURE.


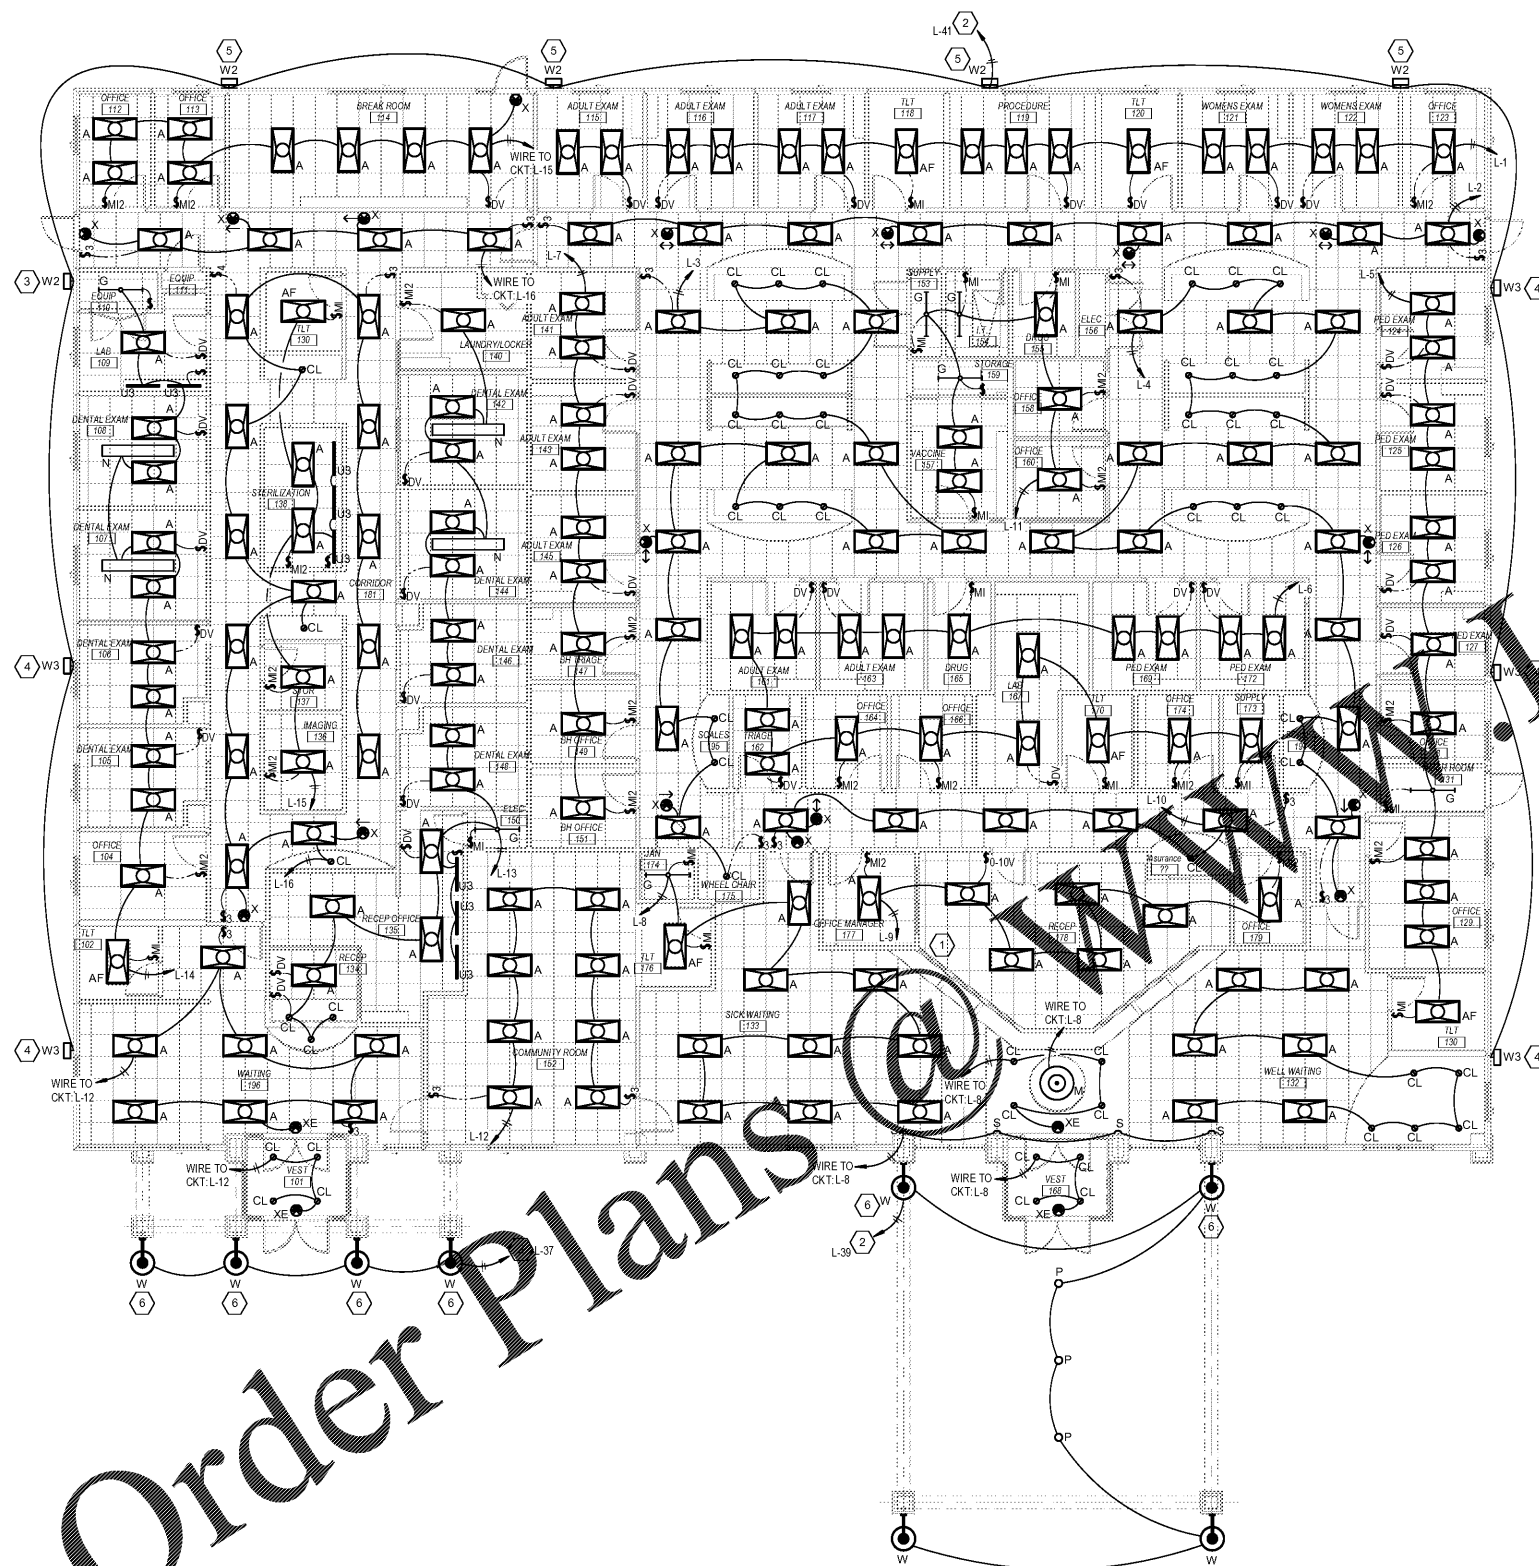


Order Plans @ www.LDILine.com

**1 LIGHTING PLAN**  
SCALE: 1/8" = 1'-0"

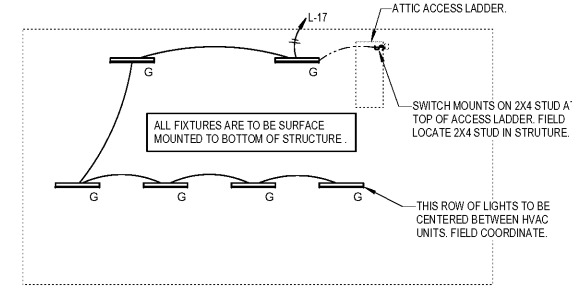

**2 Attic Floor**  
SCALE: 1/8" = 1'-0"

  

**ART TECH**  
 1410 COWART STREET  
 CHATTANOOGA, TN 37408  
 423.285.4313  
 WWW.ARTECH.PRO

**GEORGIA MOUNTAINS HEALTH SERVICES, INC.**  
 HIGHLAND CROSSING SOUTH TRACT G  
 EAST ELLIJAY, GEORGIA

*Steven B. Baber*  
 PROFESSIONAL ENGINEER  
 No. 39815  
 09/04/2020

ISSUE DATES  
INITIAL ISSUE 09-04-2020

JOB NO. 19-068 | DWN JLH | CKD GWE


**March Adams & Associates**  
 Consulting Engineers  
 310 Dodds Ave.  
 P.O. Box 3689  
 Chattanooga, Tennessee 37404  
 PH: (423)698-6675  
 FAX: (423)698-6675  
 MAA #: 20109

E1.1

LIGHTING PLAN