


COLONIAL BLVD.

COLONIAL COUNTRY CLUB BLVD.

Order Plans @ www.edline.com

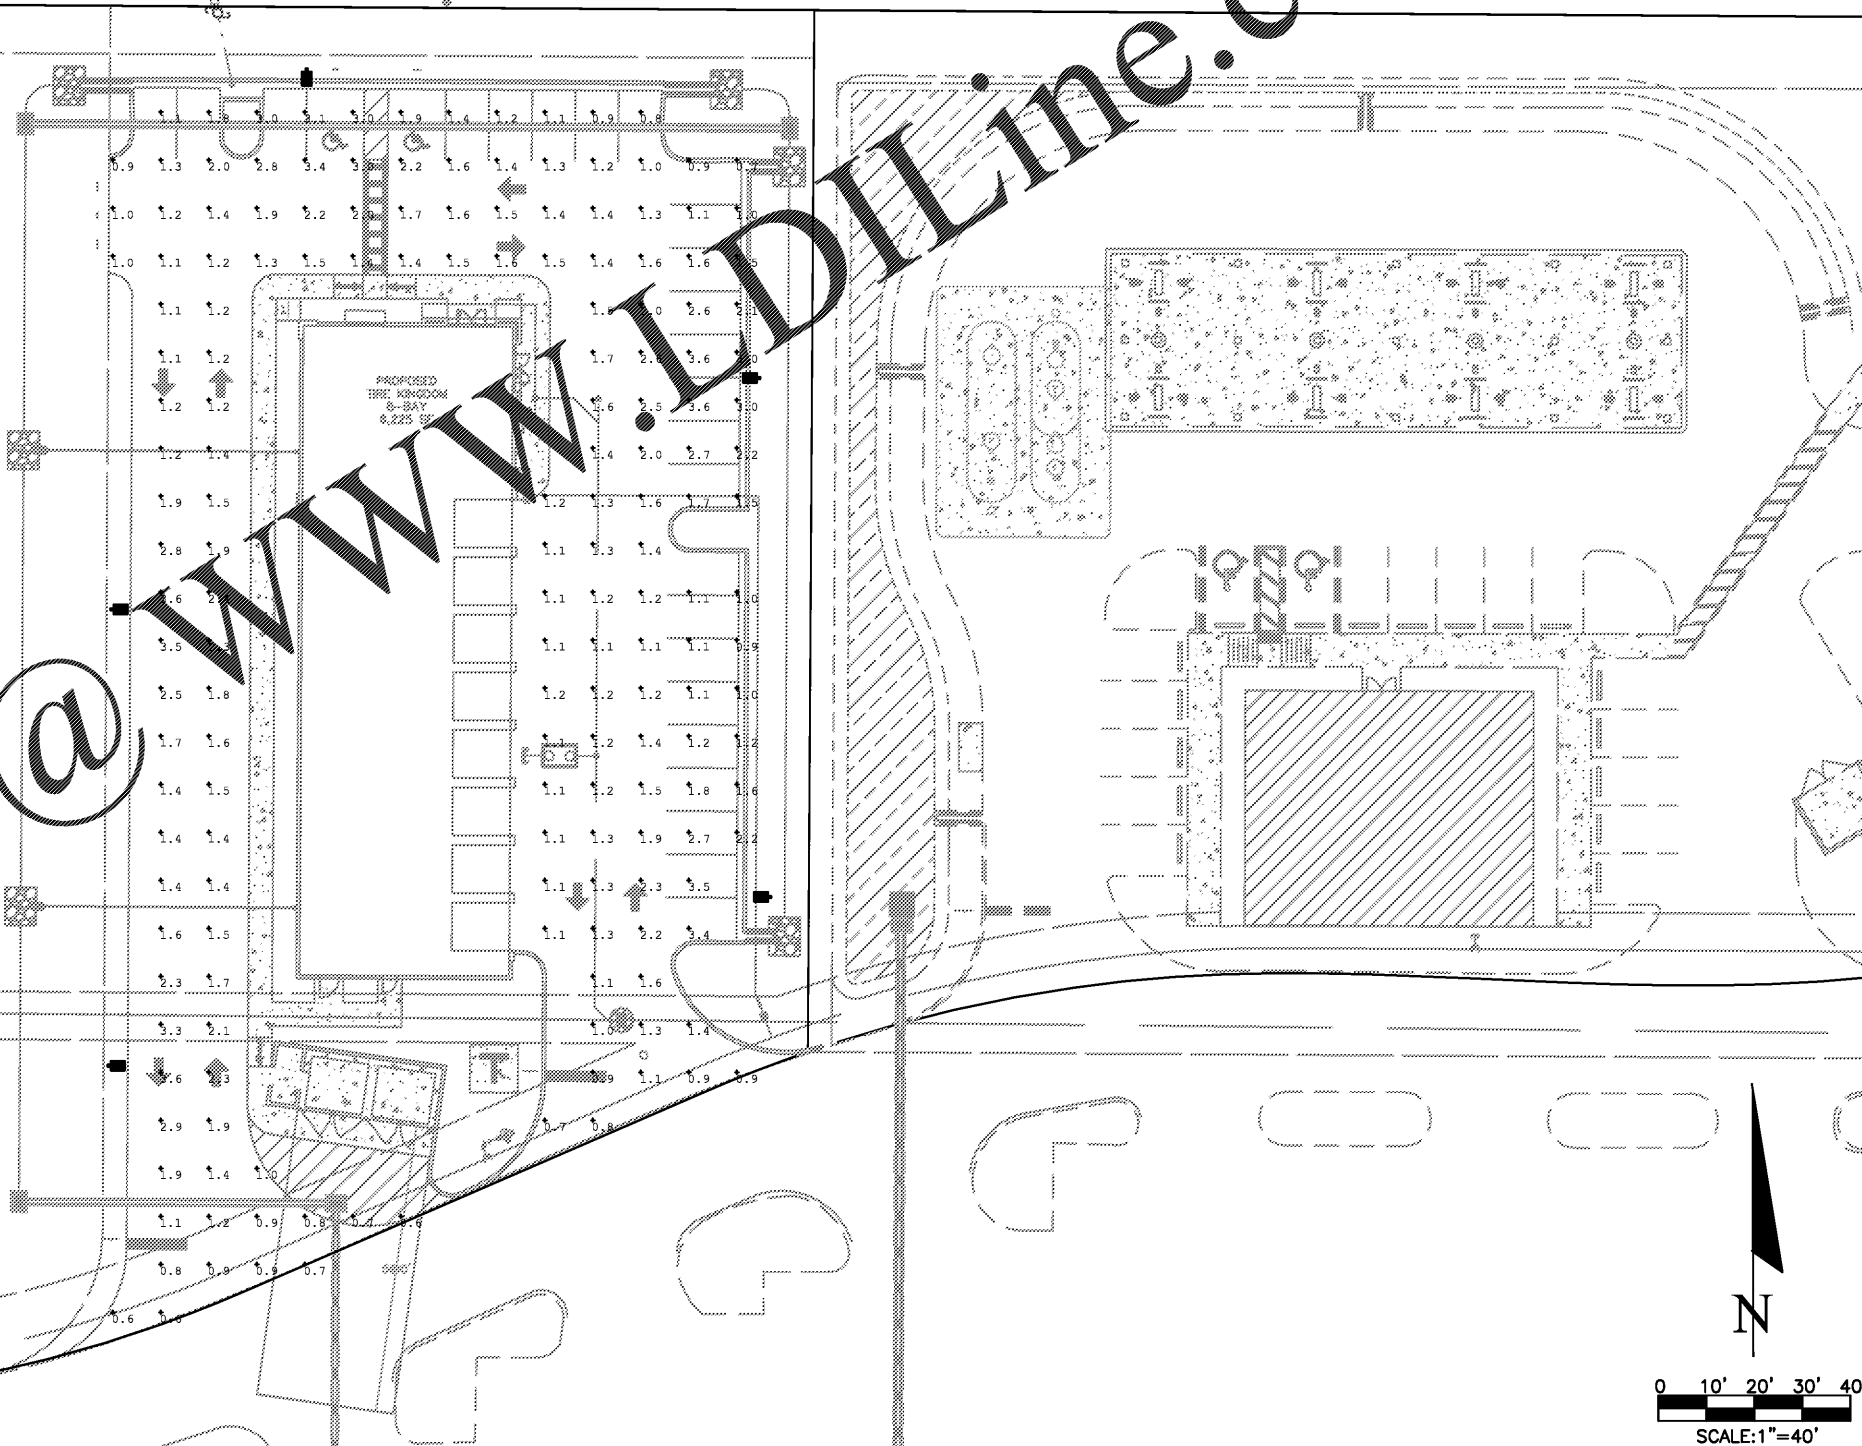

0 10' 20' 30' 40'
SCALE: 1"=40'

JOB NO. F2007.10	DATE	BY	REVISIONS	DESIGNED BY R.C.F.	APPROVED BY:	AUGUST 18, 2020	TRANSPORTATION CONSULTANTS, INC 2726 OAK RIDGE COURT, SUITE 503 FORT MYERS, FLORIDA 33901-9356 (239) 278-3090 CERTIFICATE OF AUTHORIZATION: #27003	PELICAN PRESERVE - OUTPARCEL 1 LIGHTING PLAN	SHEET NO.
				DRAWN BY W.L.F.	REID C. FELLOWS				L-4
				CHECKED BY R.C.F.	P.E. 61673				